


ANNEXURE 2


List of Drawings Attached and their Reference Nos

Sl.No	Name of the Building	Drawing Ref. No
1	Security office	M & S : PD : 11 : 009
2	Fire station	M & S : PD : 11 : 010
3	Material Testing Lab	M & S : PD : 11 : 011
4	Factory Medical Centre	M & S : PD : 11 : 012
5	Factory Canteen	M & S : PD : 11 : 013
6	Transport Garage	M & S : PD : 11 : 014
7	Disposal Yard Office Room	M & S : PD : 11 : 015
8	Weigh Bridge and Control room	M & S : PD : 11 : 016
9	Water Tank	M & S : PD : 11 : 017
10	Compressed Air Plant	M & S : PD : 11 : 018
11	DG Set Building	M & S : PD : 11 : 019
12	Receiving Substation	M & S : PD : 11 : 020
13	Civil Stores Shed	M & S : PD : 11 : 021
14	SS1	M & S : PD : 11 : 022
15	SS2	M & S : PD : 11 : 023
16	MMO Cabin - 1	M & S : PD : 11 : 024
17	MMO Cabin - 2	M & S : PD : 11 : 025
18	Artisans Cabin (2nos)	M & S : PD : 11 : 026
19	Ladies rest room & Sanitation Staff Room -(2nos)	M & S : PD : 11 : 027
20	Toilet 1 & 2	M & S : PD : 11 : 028
21	Toilet 3	M & S : PD : 11 : 029
22	Tool Crib	M & S : PD : 11 : 030
23	Intermediate Stores	M & S : PD : 11 : 031
24	WTC Electrode/oven room	M & S : PD : 11 : 032
25	Accessories room (4 nos)	M & S : PD : 11 : 033
26	NDT office	M & S : PD : 11 : 034
27	RTR X ray hall & Control room (2nos)	M & S : PD : 11 : 035

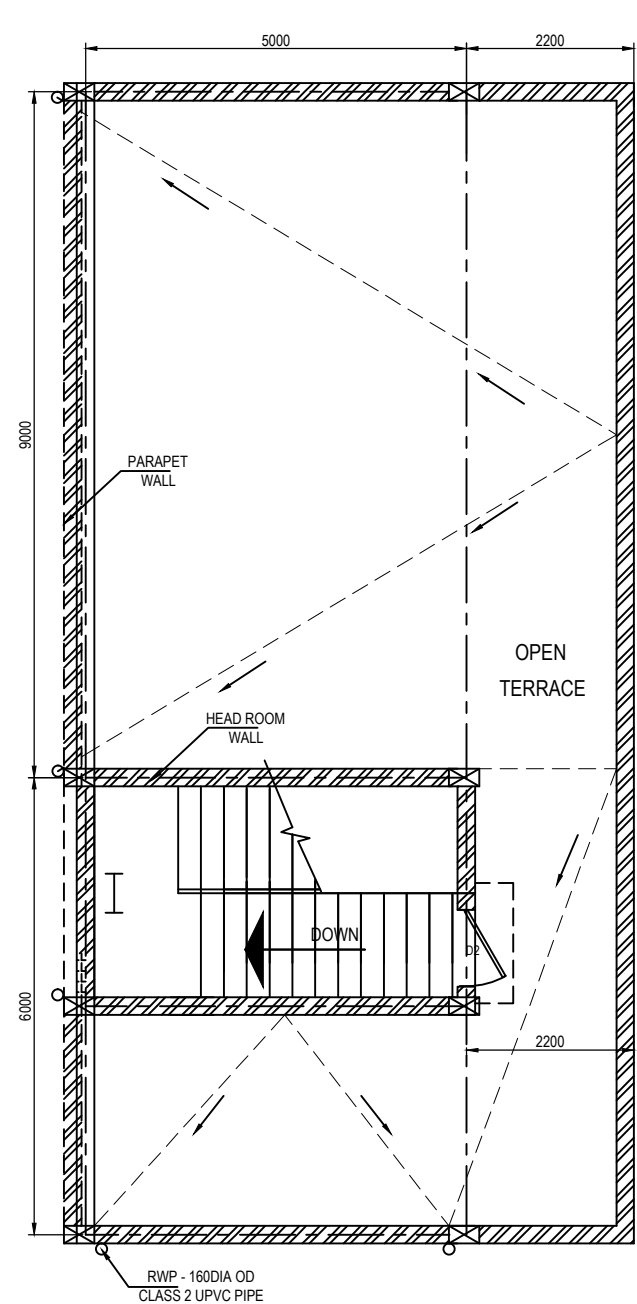


LEGEND:

- 5/15A Plug Socket - 9 nos.
- 5A Plug Socket - 16nos
- 1x28W TL5 Fitting- 22 nos
- 2x28W TL5 Fitting- 15 nos
- 32A AC BOX -7 nos
- 20A AC BOX - 1 no
- Ceiling Fan -12 nos
- Exhaust Fan -5 nos
- 12W 16A SPN MCBDB - 2 nos.
- 8W 16A, 7Seg MCBDB -1 no
- 150W HPSV street light fitting - 4 nos
- PCC - 1 no.
- 8W 32A 4SEG MCBDB - 1 no.
- 2 KVA UPS - 1 no

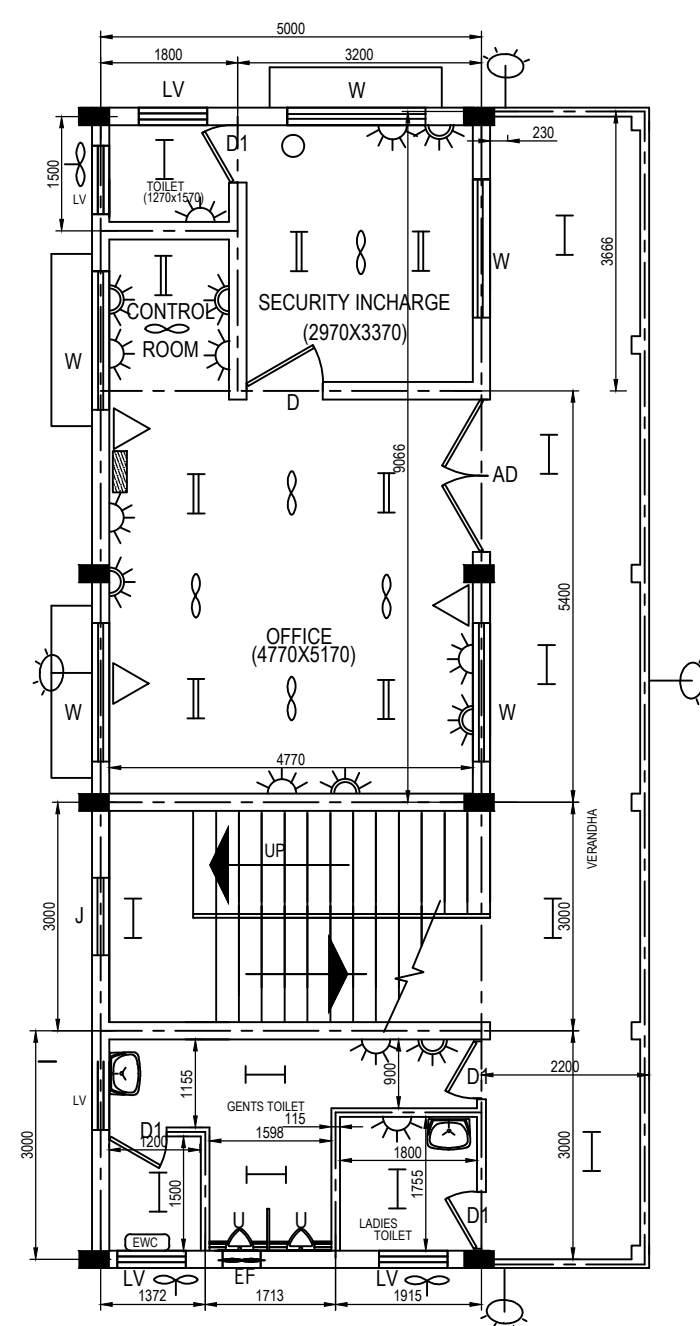

PLAN OF SECURITY OFFICE

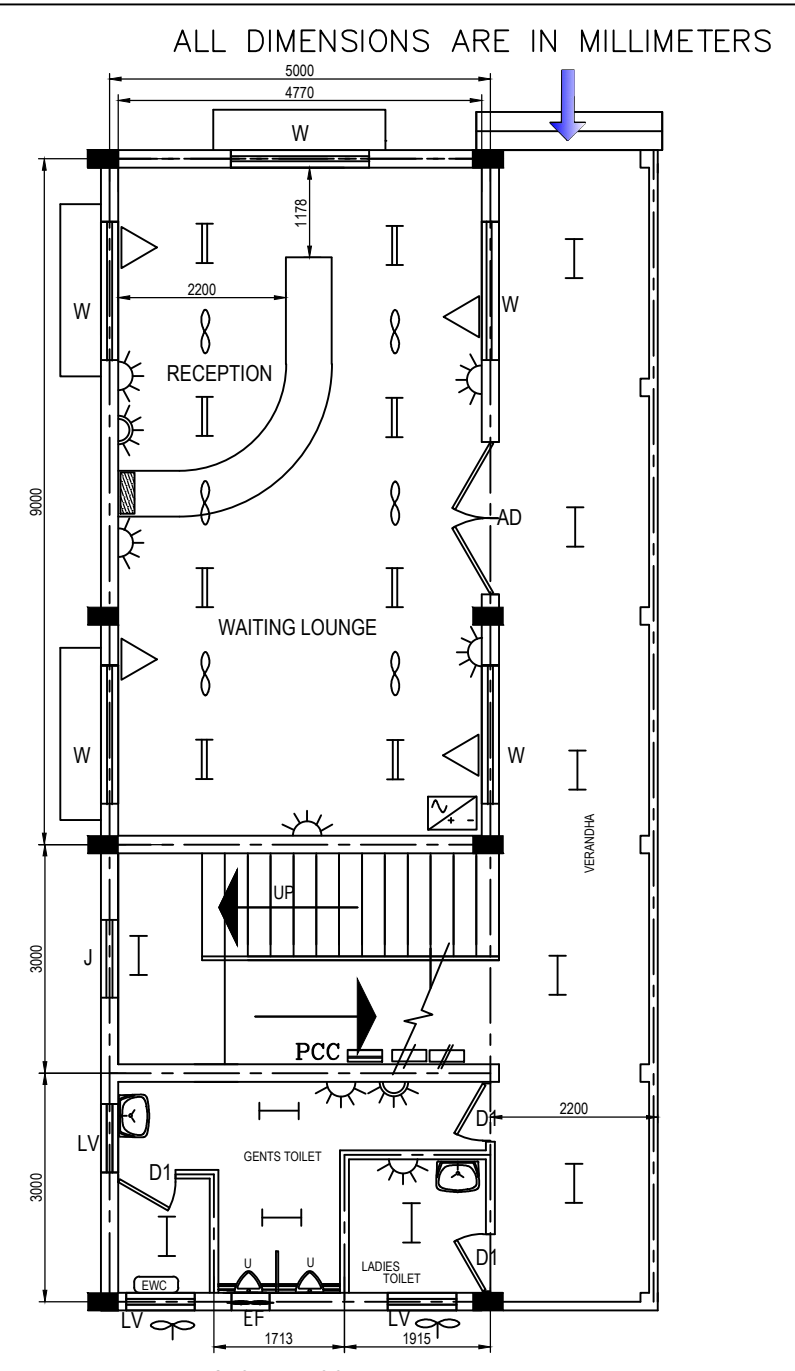

DIMENSION:
 Height - 4000mm (Gnd floor)
 Height - 4000mm (First floor)
 Width - 5000mm
 Length - 15000mm


Note:
 * Maximum 800 W per circuit for point wiring.

CAUTION: The information on this document is the property of BHARAT HEAVY ELECTRICALS LTD. It must not be used directly or indirectly in any way detrimental to the interest of the company.

TYPE OF PRODUCT OR NAME OF CUSTOMER/PROJECT		POWER PLANT PIPING UNIT- THIRUMAYAM			
	Bharat Heavy Electricals Ltd	DRN & CHD	NAME L. Honey Wood Mary	SIGNATURE 	DATE 25.03.2011
	UNIT: HIGH PRESSURE BOILER PLANT TIRUCHIRAPALLI - 620014	APPD	V. Ragu		25.03.2011
TITLE		CARD CODE	DRAWING NO :		REV
ELECTRIFICATION OF SECURITY OFFICE		U 01	M&S: PD: 11: 009		01

ELEVATION

ALL DIMENSIONS ARE IN MILLIMETERS

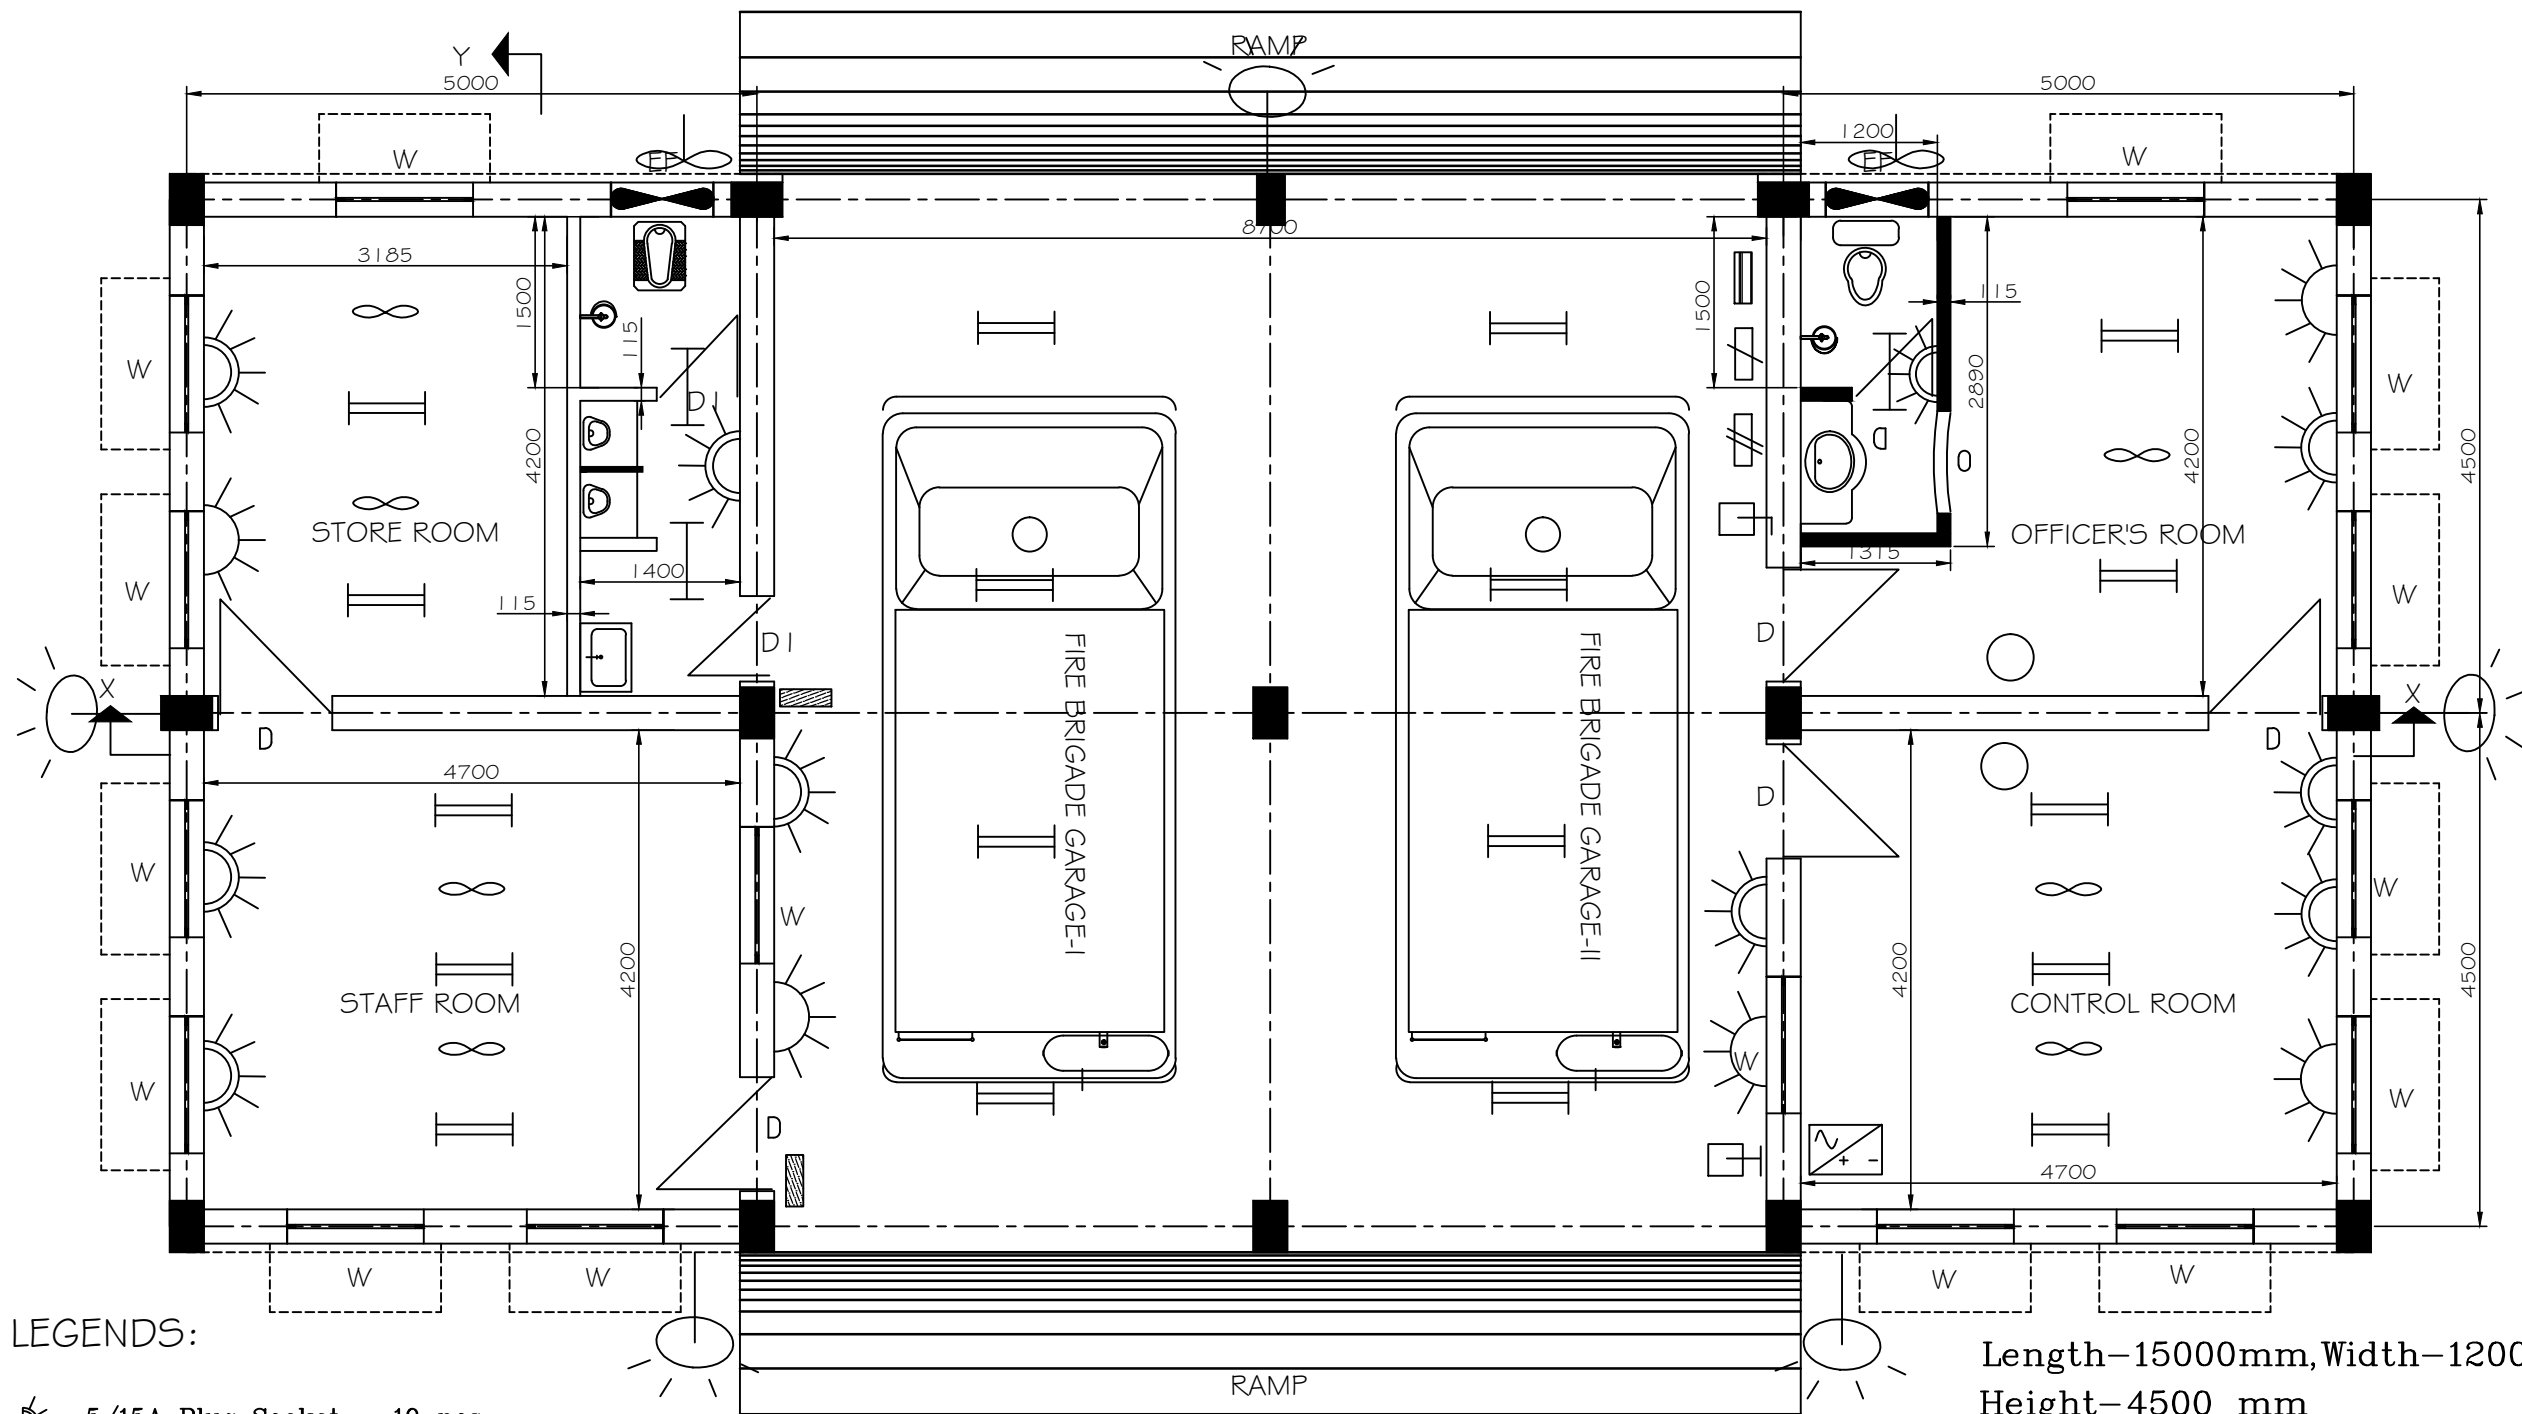

LEGENDS:

- 5/15A Plug Socket - 10 nos
- 5A Plug Socket - 5 nos
- 63A TPN Isolator - 1 no
- Ceiling Fan - 7 nos
- Exhaust Fan - 2 nos
- 32A TPN Isolator - 1 no
- 2 KVA UPS - 1 no
- PCC - 1 no.
- 12W 16A SPN MCB DB - 2 nos.
- 8W 16A, 7Seg MCB DB - 1 no
- 150W HPSV Street Light Fitting-5 nos
- 8W 32A, 4Seg MCB DB - 1 no
- 2x28W TL5 Fitting - 18 nos
- 1x28W TL5 Fitting - 3 nos
- 20A AC box - 2 nos

PLAN

CAUTION: The information on this document is the property of BHARAT HEAVY ELECTRICALS LTD. It must not be used directly or indirectly in any way detrimental to the interest of the company.

TYPE OF PRODUCT OR NAME OF CUSTOMER/PROJECT

POWER PLANT PIPING UNIT- THIRUMAYAM



Bharat Heavy Electricals Ltd
UNIT: HIGH PRESSURE BOILER PLANT
TIRUCHIRAPALLI - 620014

DRN & CHD
APPD

NAME
L. Honey Wood Mary
V. Ragu

SIGNATURE
[Signature]
[Signature]

DATE
01.02.2011
01.02.2011

NO. OF VAR




TITLE
ELECTRIFICATION OF FIRE STATION

CARD CODE
U 01

DRAWING NO :
M&S: PD: 11: 010

REV
00

ALL DIMENSIONS ARE IN MILLIMETRES

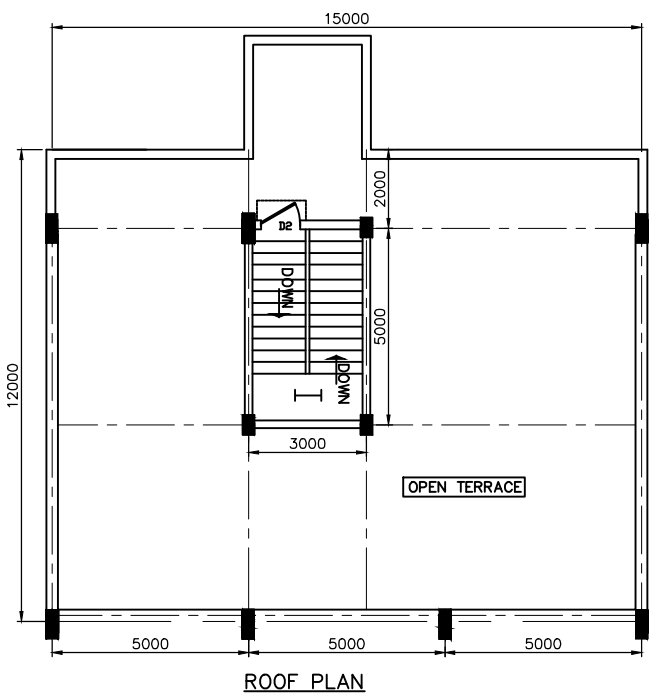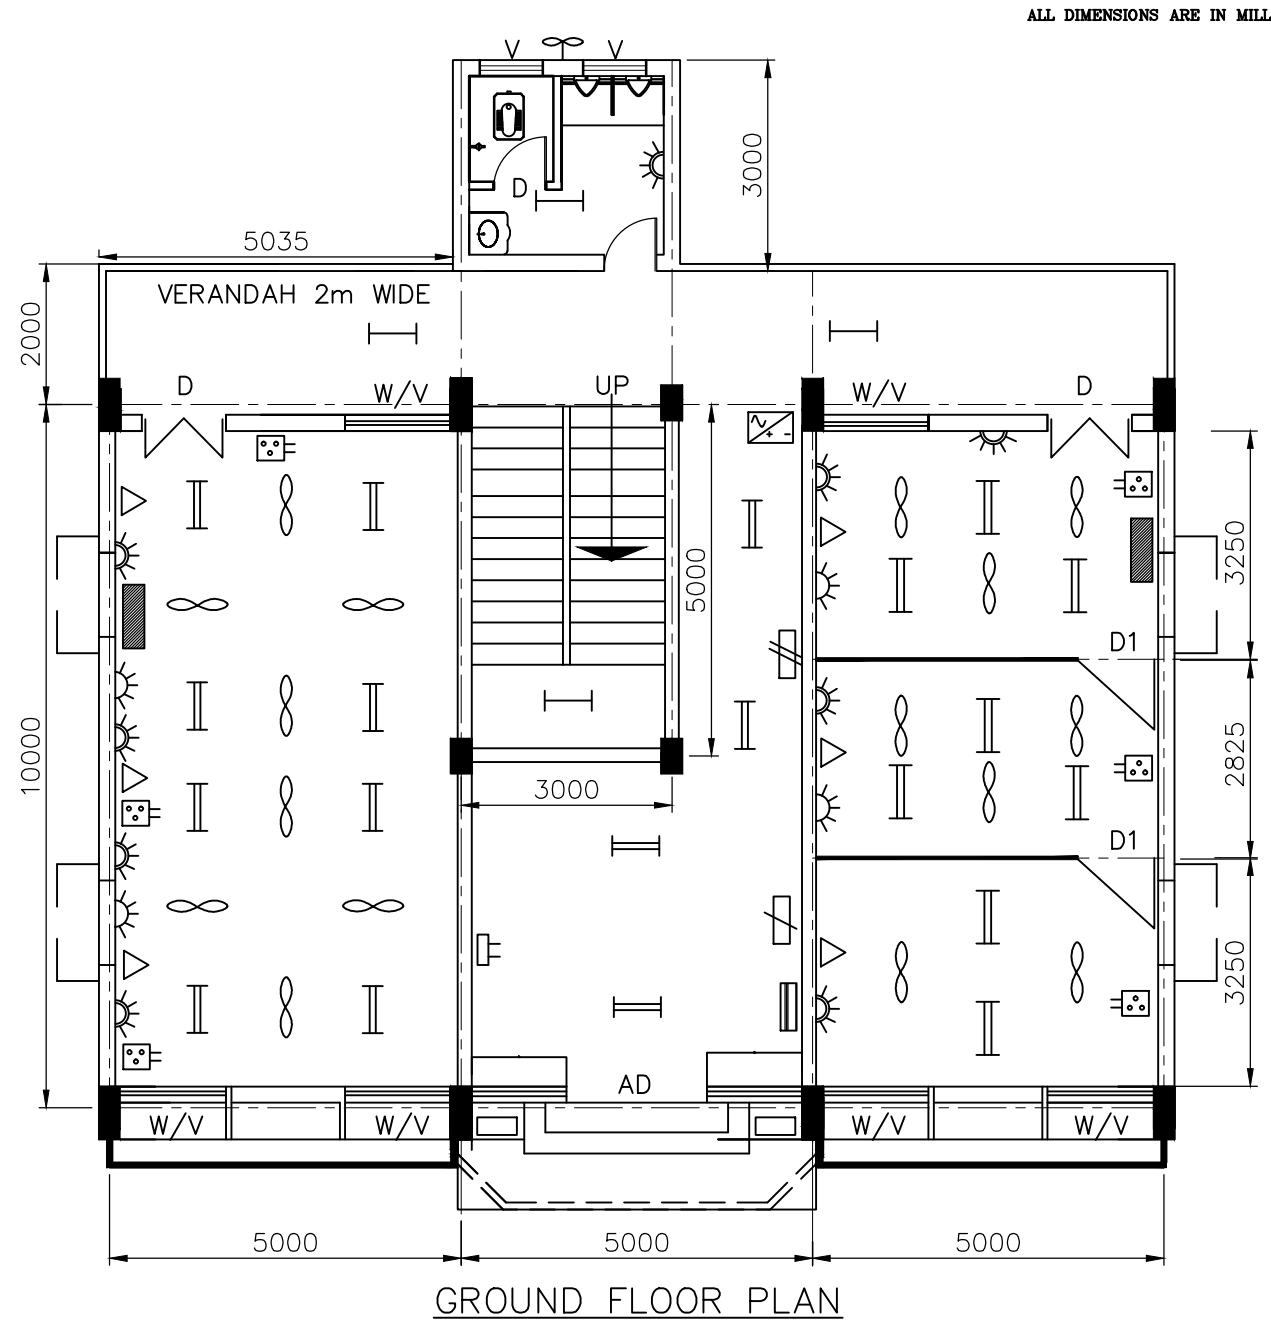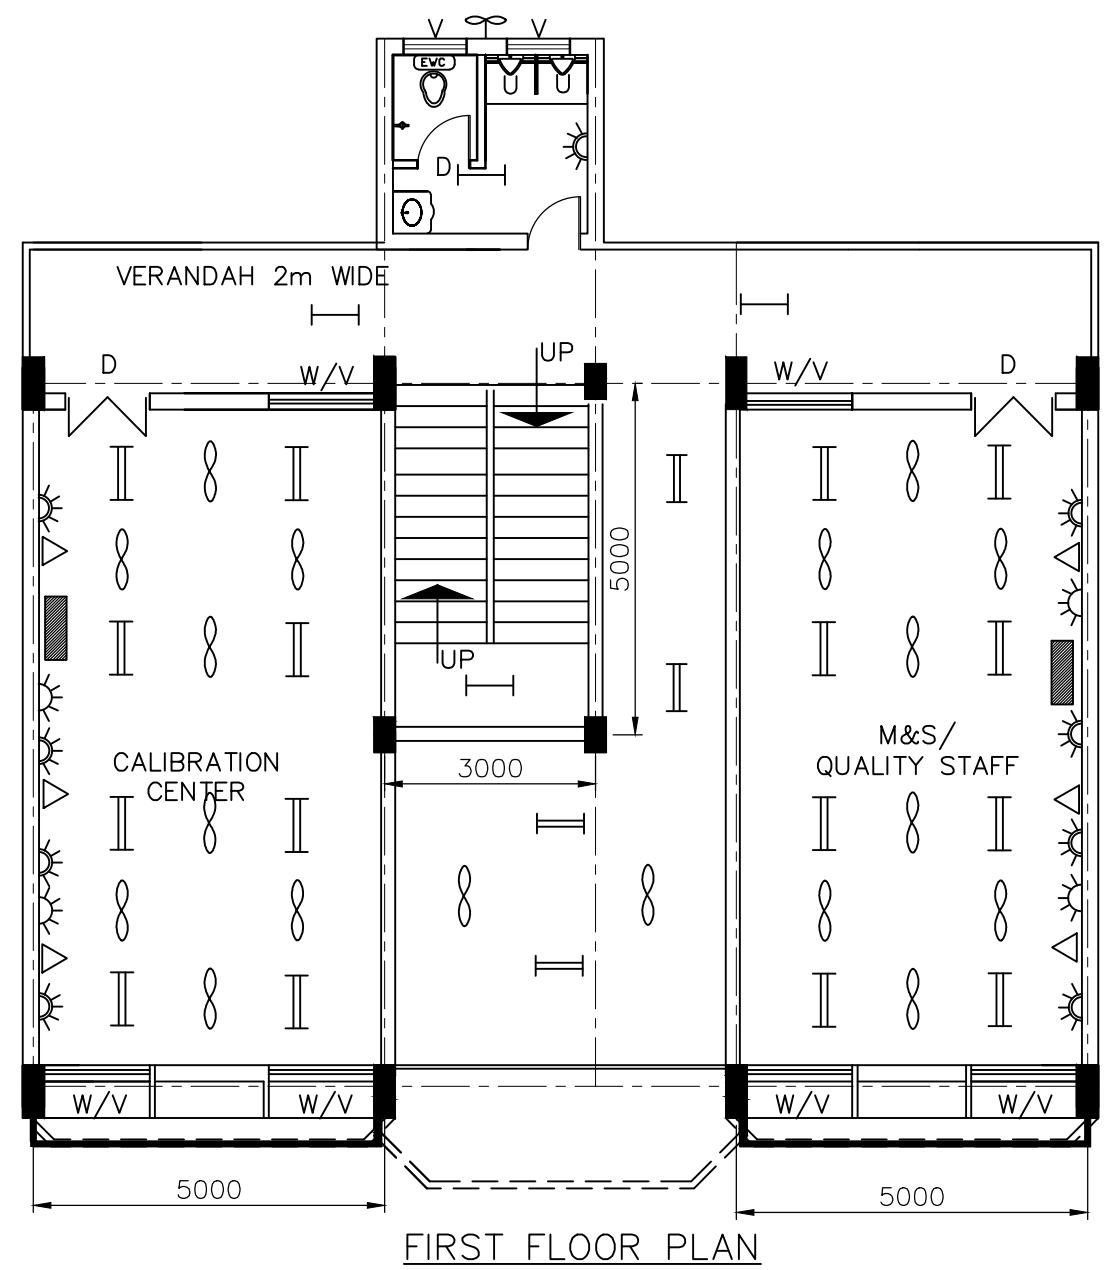


LEGENDS:

- ☀ 5/15A Plug Socket - 18 nos
- ▨ 12W 16A SPN MCB DB - 4 nos.
- = 2x28W TL5 Fitting - 40 nos
- ☀ 5A Plug Socket - 8 nos
- ⚡ 8W 16A, 7Seg MCB DB - 1 no
- = 1x28W TL5 Fitting - 9 nos
- ⊞ 3Pole MCB - 6 nos
- ⚡ 8W 32A, 4Seg MCB DB - 1 no
- ☼ Exhaust Fan - 2 nos
- ∞ Ceiling Fan - 34 nos
- △ 32A AC BOX - 12 nos
- = PCC - 1 no.
- ⊞ 8W TP Output MCB DB - 1 no
- ⊞ 2 KVA UPS - 1 no

DIMENSION:

Height - 4000mm (Gnd floor)
 Height - 4000mm (First floor)
 Width - 12000mm
 Length - 15000mm

CAUTION: The information on this document is the property of BHARAT HEAVY ELECTRICALS LTD. It must not be used directly or indirectly in any way detrimental to the interest of the company.	TYPE OF PRODUCT OR NAME OF CUSTOMER/PROJECT	POWER PLANT PIPING UNIT- THIRUMAYAM				
	 Bharat Heavy Electricals Ltd UNIT: HIGH PRESSURE BOILER PLANT TIRUCHIRAPALLI - 620014	DRN & CHD	NAME <i>L. Honey Wood Mary</i>	SIGNATURE <i>[Signature]</i>	DATE 02.02.2011	NO. OF VAR
	TITLE ELECTRIFICATION OF MATERIAL TESTING LAB	CARD CODE	DRAWING NO : M&S: PD: 11: 011		REV 01	

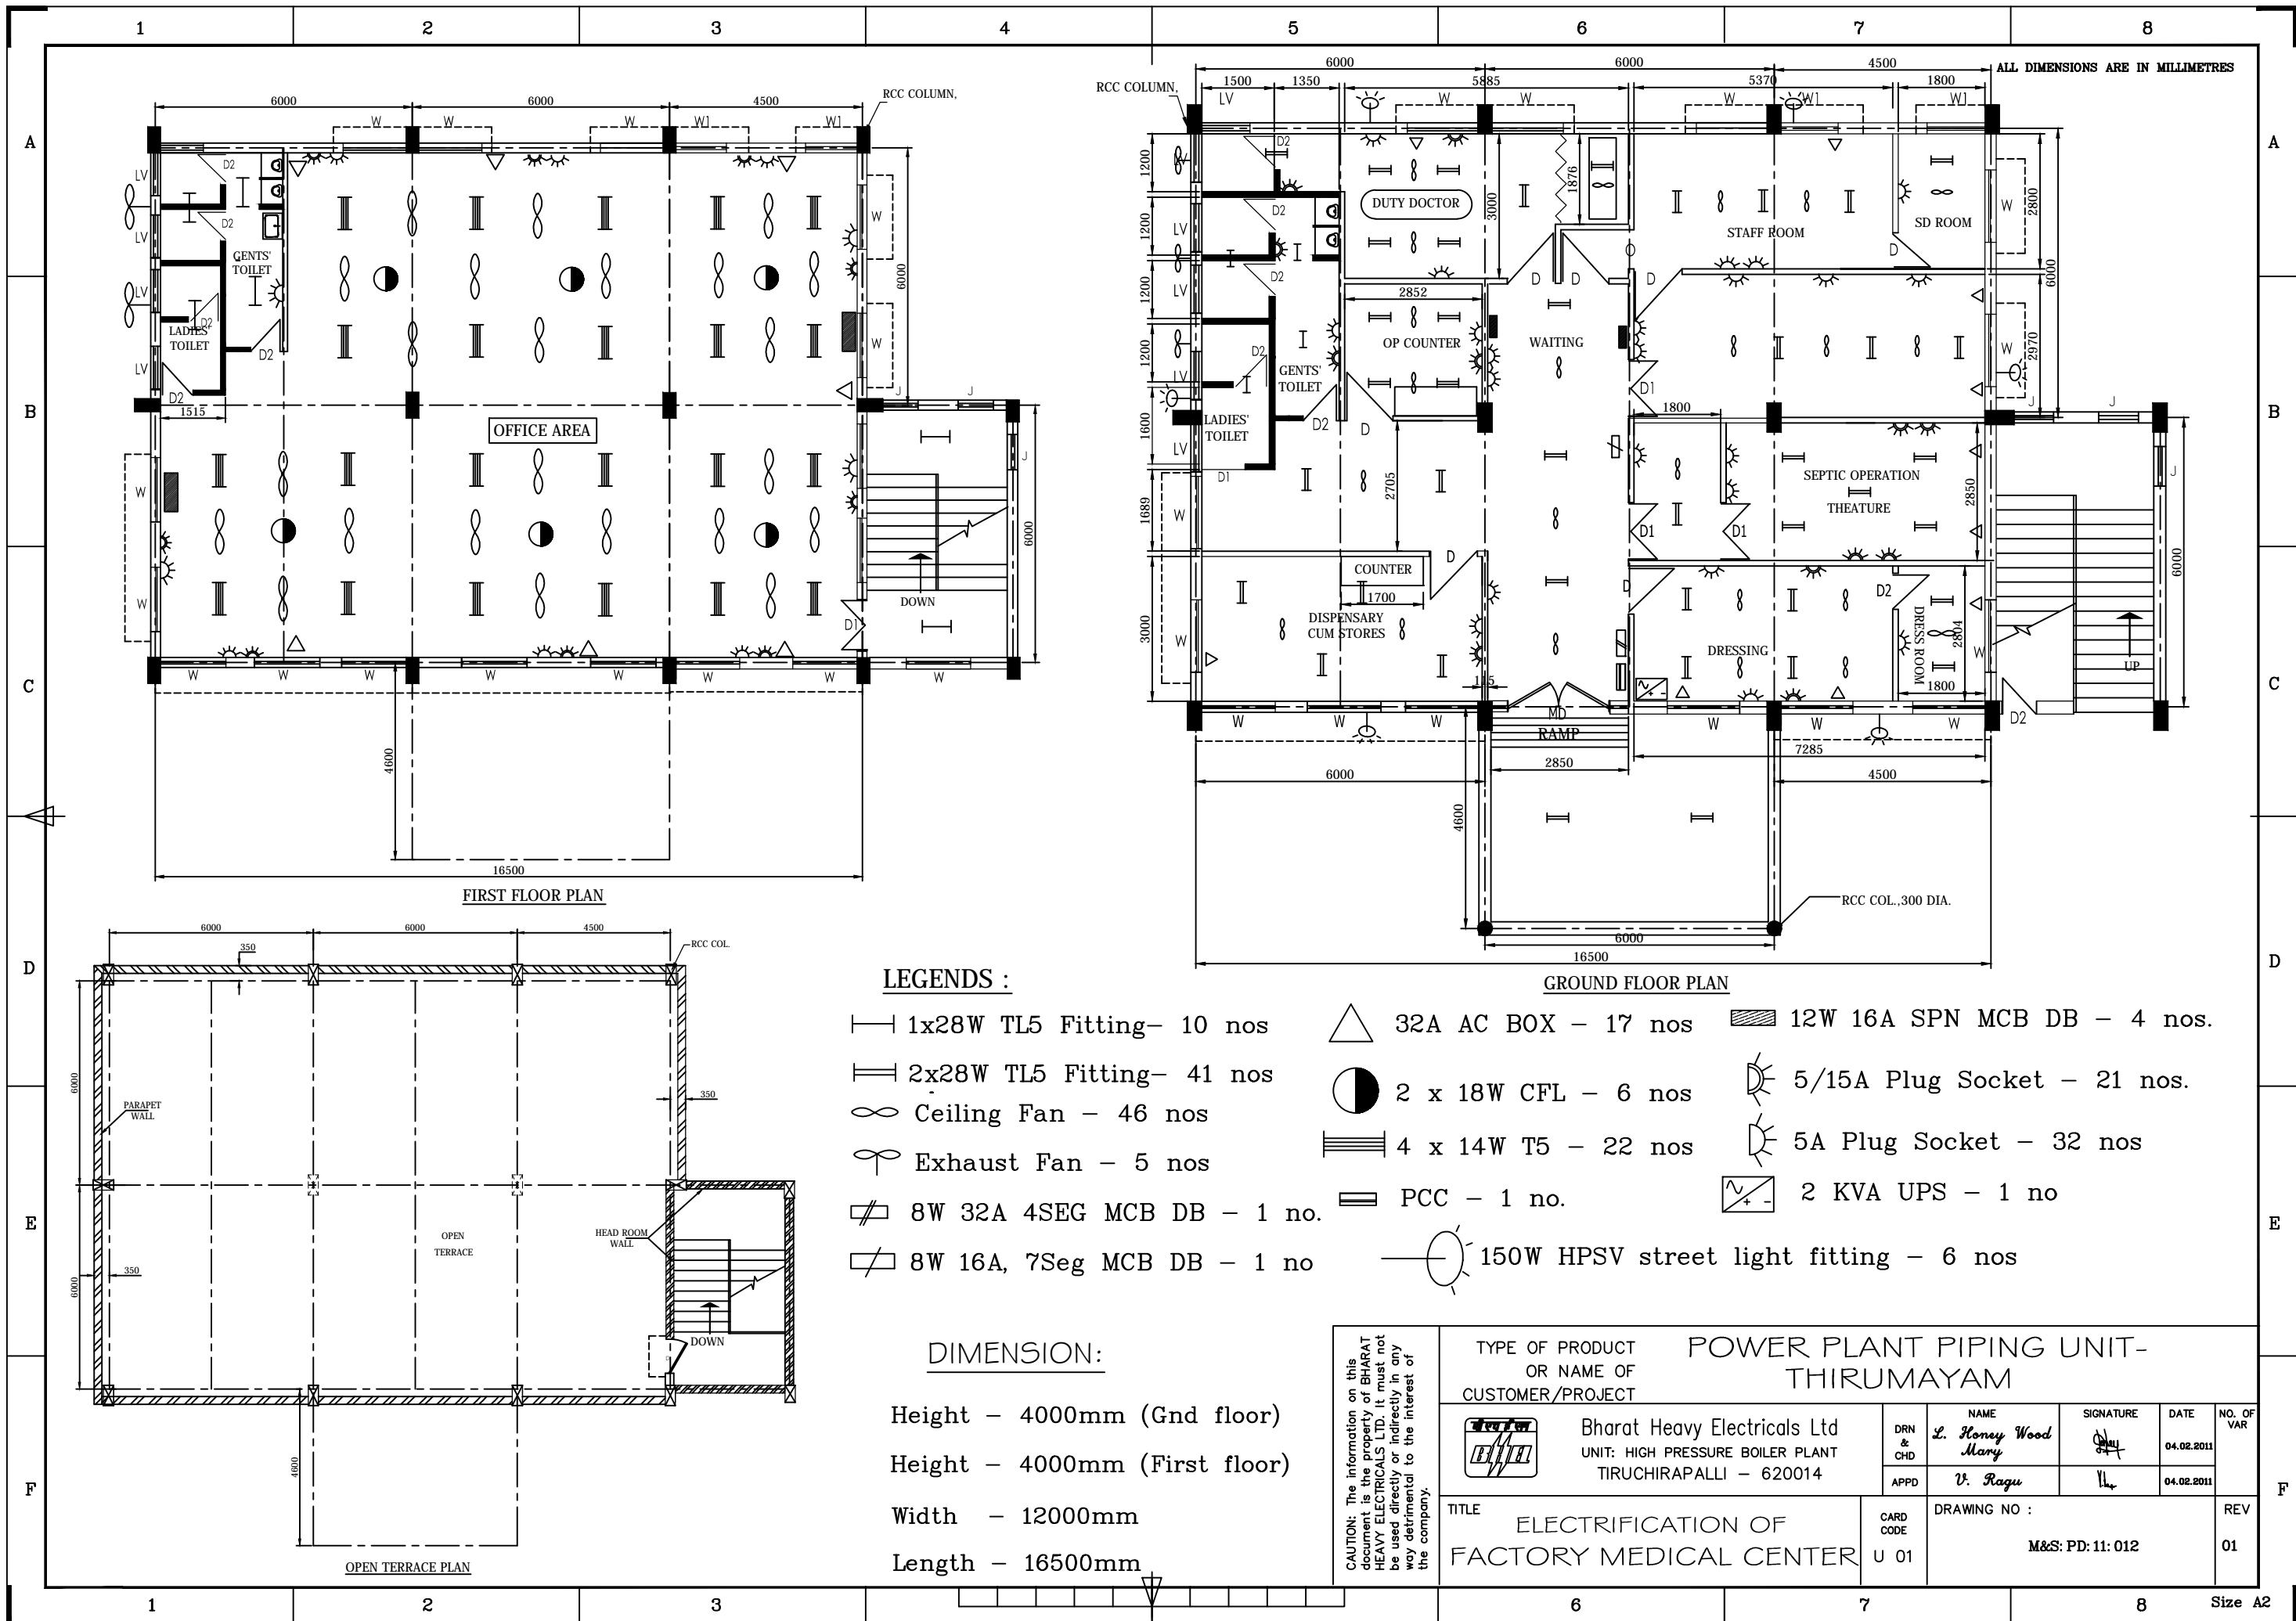

FIRST FLOOR PLAN

GROUND FLOOR PLAN

OPEN TERRACE PLAN


LEGENDS :

- |— 1x28W TL5 Fitting- 10 nos
- |— 2x28W TL5 Fitting- 41 nos
- ∞ Ceiling Fan - 46 nos
- ⊙ Exhaust Fan - 5 nos
- ⊘ 8W 32A 4SEG MCB DB - 1 no.
- ⊘ 8W 16A, 7Seg MCB DB - 1 no
- △ 32A AC BOX - 17 nos
- ◐ 2 x 18W CFL - 6 nos
- ⊘ 4 x 14W T5 - 22 nos
- ≡ PCC - 1 no.
- ⊘ 150W HPSV street light fitting - 6 nos
- ▨ 12W 16A SPN MCB DB - 4 nos.
- ⊘ 5/15A Plug Socket - 21 nos.
- ⊘ 5A Plug Socket - 32 nos
- ⊘ 2 KVA UPS - 1 no

DIMENSION:

- Height - 4000mm (Gnd floor)
- Height - 4000mm (First floor)
- Width - 12000mm
- Length - 16500mm

CAUTION: The information on this document is the property of BHARAT HEAVY ELECTRICALS LTD. It must not be used directly or indirectly in any way detrimental to the interest of the company.	TYPE OF PRODUCT OR NAME OF CUSTOMER/PROJECT		POWER PLANT PIPING UNIT- THIRUMAYAM					
		Bharat Heavy Electricals Ltd UNIT: HIGH PRESSURE BOILER PLANT TIRUCHIRAPALLI - 620014		DRN & CHD	NAME <i>L. Honey Wood Mary</i>	SIGNATURE <i>[Signature]</i>	DATE 04.02.2011	NO. OF VAR
		APPD			APPD	V. Ragu	[Signature]	
TITLE ELECTRIFICATION OF FACTORY MEDICAL CENTER			CARD CODE U 01	DRAWING NO : M&S: PD: 11: 012			REV 01	

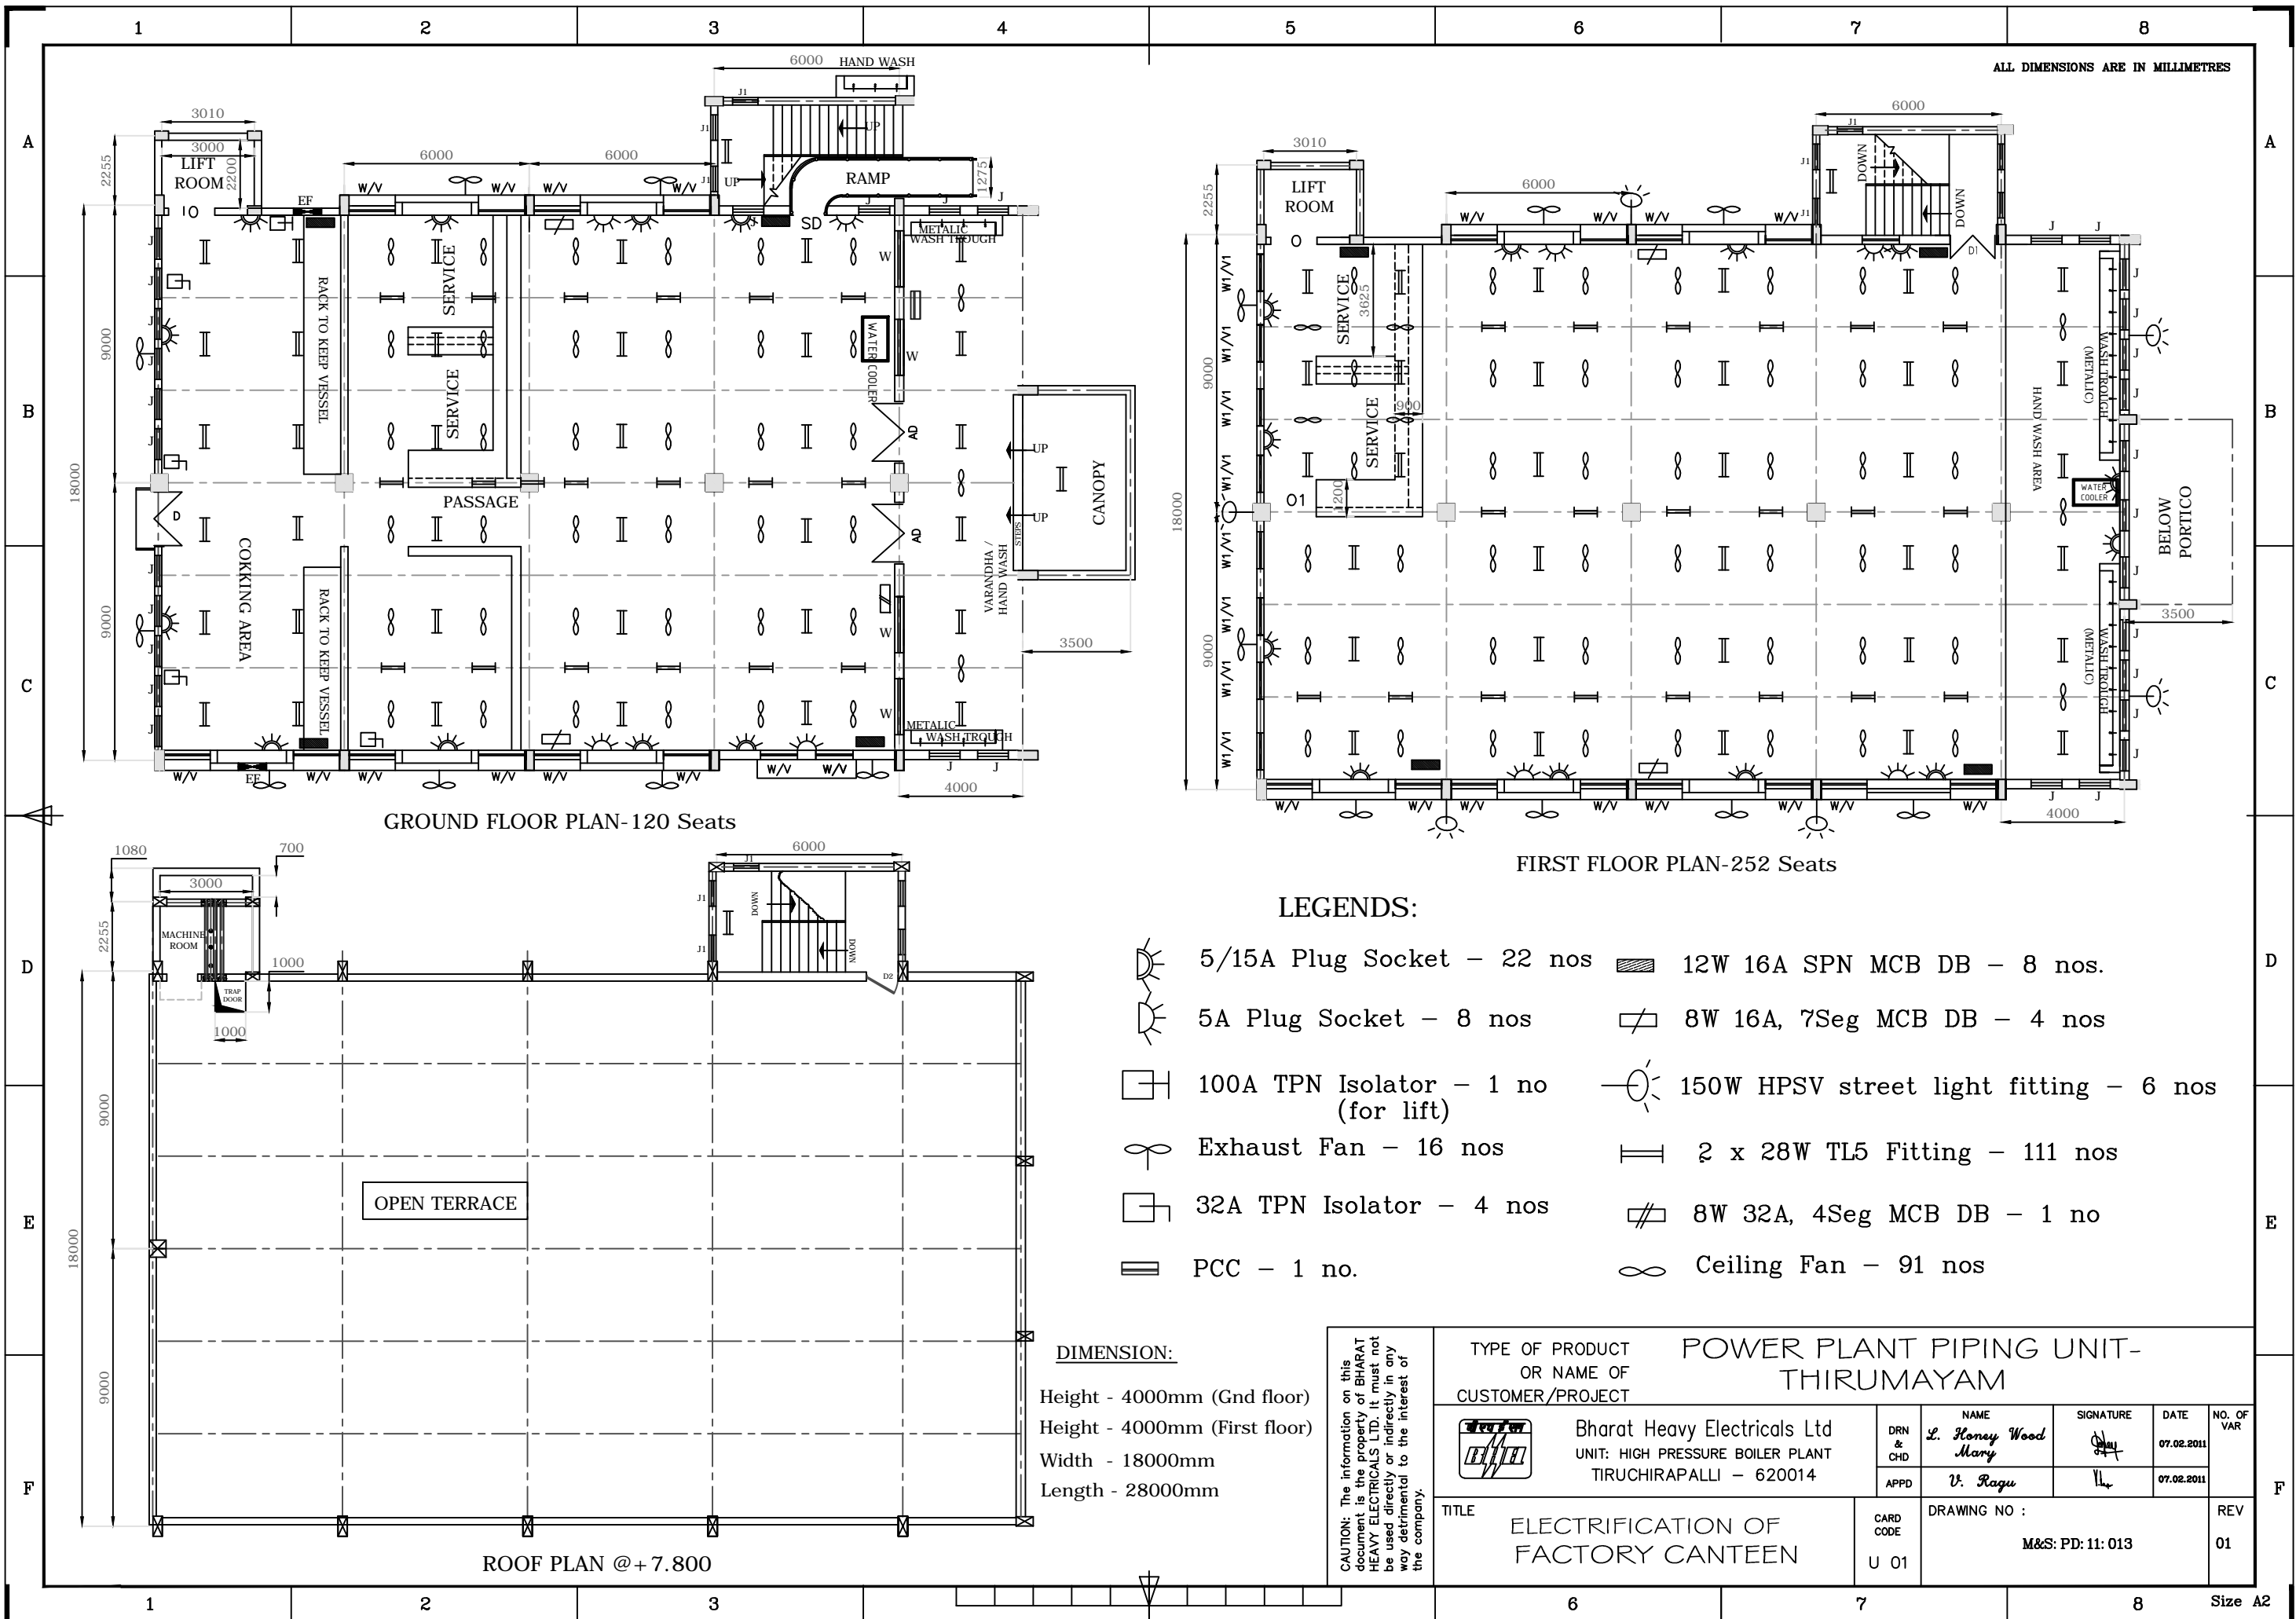

ALL DIMENSIONS ARE IN MILLIMETRES

GROUND FLOOR PLAN-120 Seats

FIRST FLOOR PLAN-252 Seats

ROOF PLAN @+7.800

LEGENDS:

- 5/15A Plug Socket - 22 nos
- 5A Plug Socket - 8 nos
- 100A TPN Isolator - 1 no (for lift)
- Exhaust Fan - 16 nos
- 32A TPN Isolator - 4 nos
- PCC - 1 no.
- 12W 16A SPN MCB DB - 8 nos.
- 8W 16A, 7Seg MCB DB - 4 nos
- 150W HPSV street light fitting - 6 nos
- 2 x 28W TL5 Fitting - 111 nos
- 8W 32A, 4Seg MCB DB - 1 no
- Ceiling Fan - 91 nos


DIMENSION:

Height - 4000mm (Gnd floor)
 Height - 4000mm (First floor)
 Width - 18000mm
 Length - 28000mm

CAUTION: The information on this document is the property of BHARAT HEAVY ELECTRICALS LTD. It must not be used directly or indirectly in any way detrimental to the interest of the company.

TYPE OF PRODUCT OR NAME OF CUSTOMER/PROJECT		POWER PLANT PIPING UNIT- THIRUMAYAM					
	Bharat Heavy Electricals Ltd UNIT: HIGH PRESSURE BOILER PLANT TIRUCHIRAPALLI - 620014		DRN & CHD	NAME <i>L. Honey Wood Mary</i>	SIGNATURE <i>[Signature]</i>	DATE 07.02.2011	NO. OF VAR
			APPD	<i>V. Ragu</i>	<i>[Signature]</i>	07.02.2011	
TITLE		ELECTRIFICATION OF FACTORY CANTEEN		CARD CODE	DRAWING NO : M&S: PD: 11: 013		REV
				U 01			01

ALL DIMENSIONS ARE IN MILLIMETERS

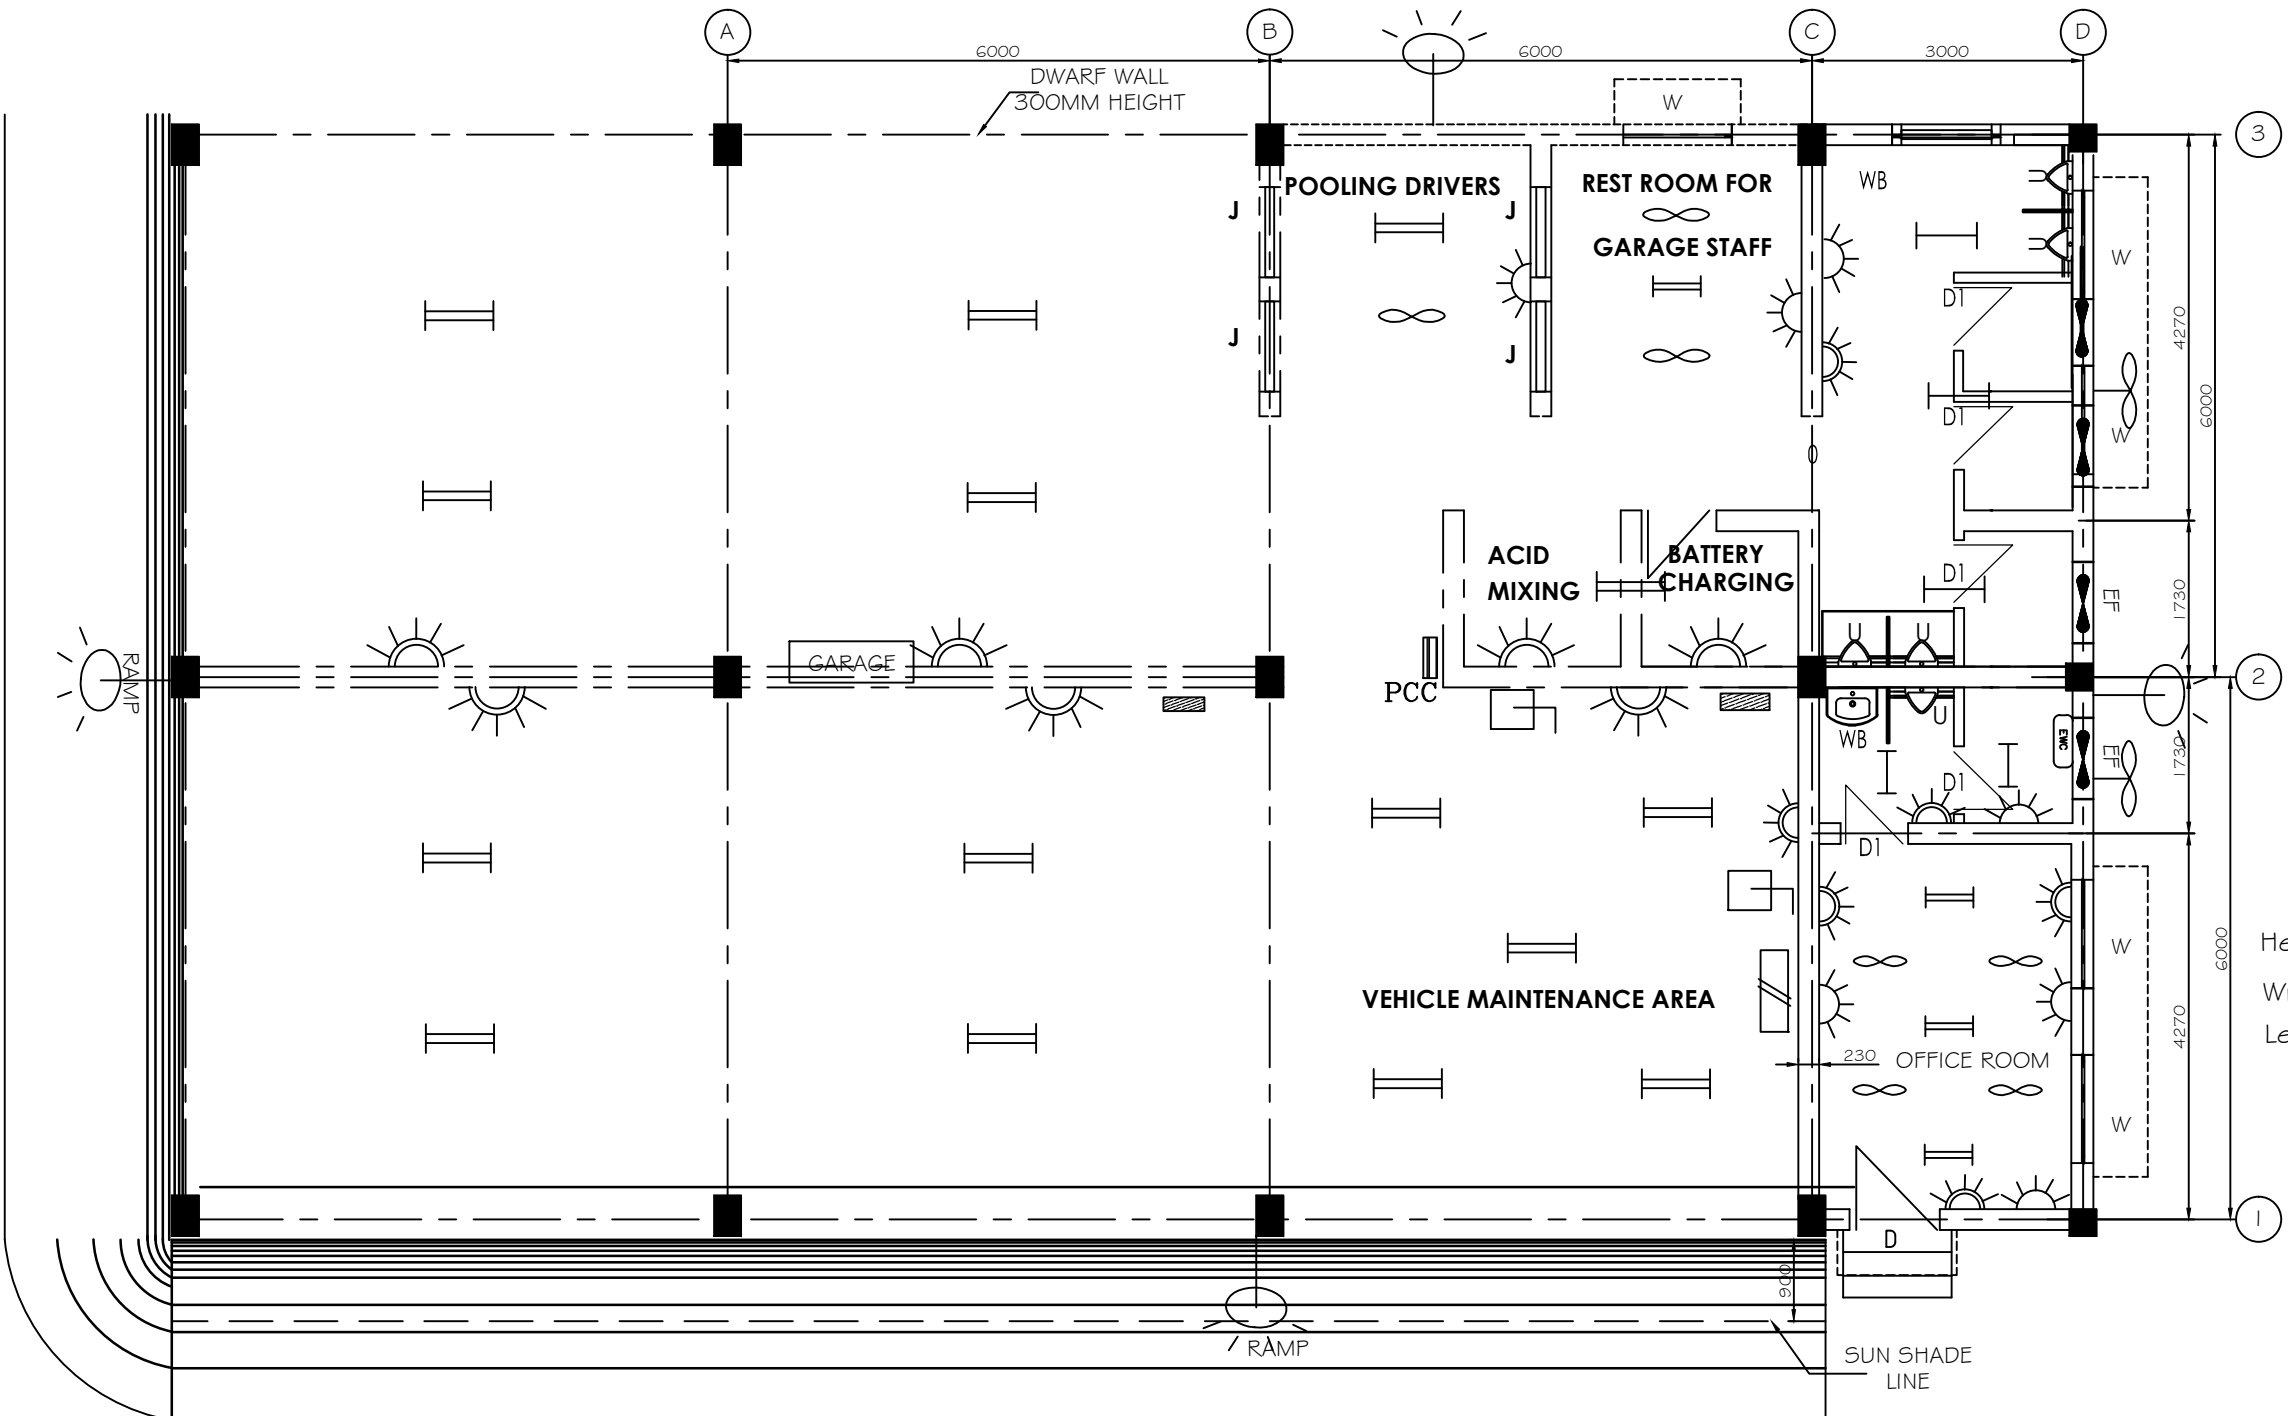

DIMENSION:
 Height - 3600mm
 Width - 12000mm
 Length - 20000mm


LEGENDS:

PLAN

- ☀ 5/15A Plug Socket - 13 nos
- ☀ 150W HPSV Street Light Fitting - 4 nos
- ☀ 5A Plug Socket - 7 nos
- ⚡ 8W 32A, 4Seg MCB DB - 1 no
- ▨ 12W 16A SPN MCB DB - 2 nos.
- ∞ 2x28W TL5 Fitting - 19 nos
- ∞ Ceiling Fan - 7 nos
- ∞ 1x28W TL5 Fitting - 5 nos
- ∞ Exhaust Fan - 2 nos
- ☐ 32A TPN Isolator - 2 nos
- ☐ PCC - 1 no

CAUTION: The information on this document is the property of BHARAT HEAVY ELECTRICALS LTD. It must not be used directly or indirectly in any way detrimental to the interest of the company.

TYPE OF PRODUCT OR NAME OF CUSTOMER/PROJECT		POWER PLANT PIPING UNIT- THIRUMAYAM			
 Bharat Heavy Electricals Ltd UNIT: HIGH PRESSURE BOILER PLANT TIRUCHIRAPALLI - 620014	DRN & CHD	NAME <i>L. Honey Wood Mary</i>	SIGNATURE <i>[Signature]</i>	DATE 09.02.2011	NO. OF VAR
	APPD	<i>V. Ragu</i>	<i>[Signature]</i>	09.02.2011	REV
TITLE ELECTRIFICATION OF TRANSPORT GARAGE		CARD CODE U 01	DRAWING NO : M&S: PD: 11: 014		00

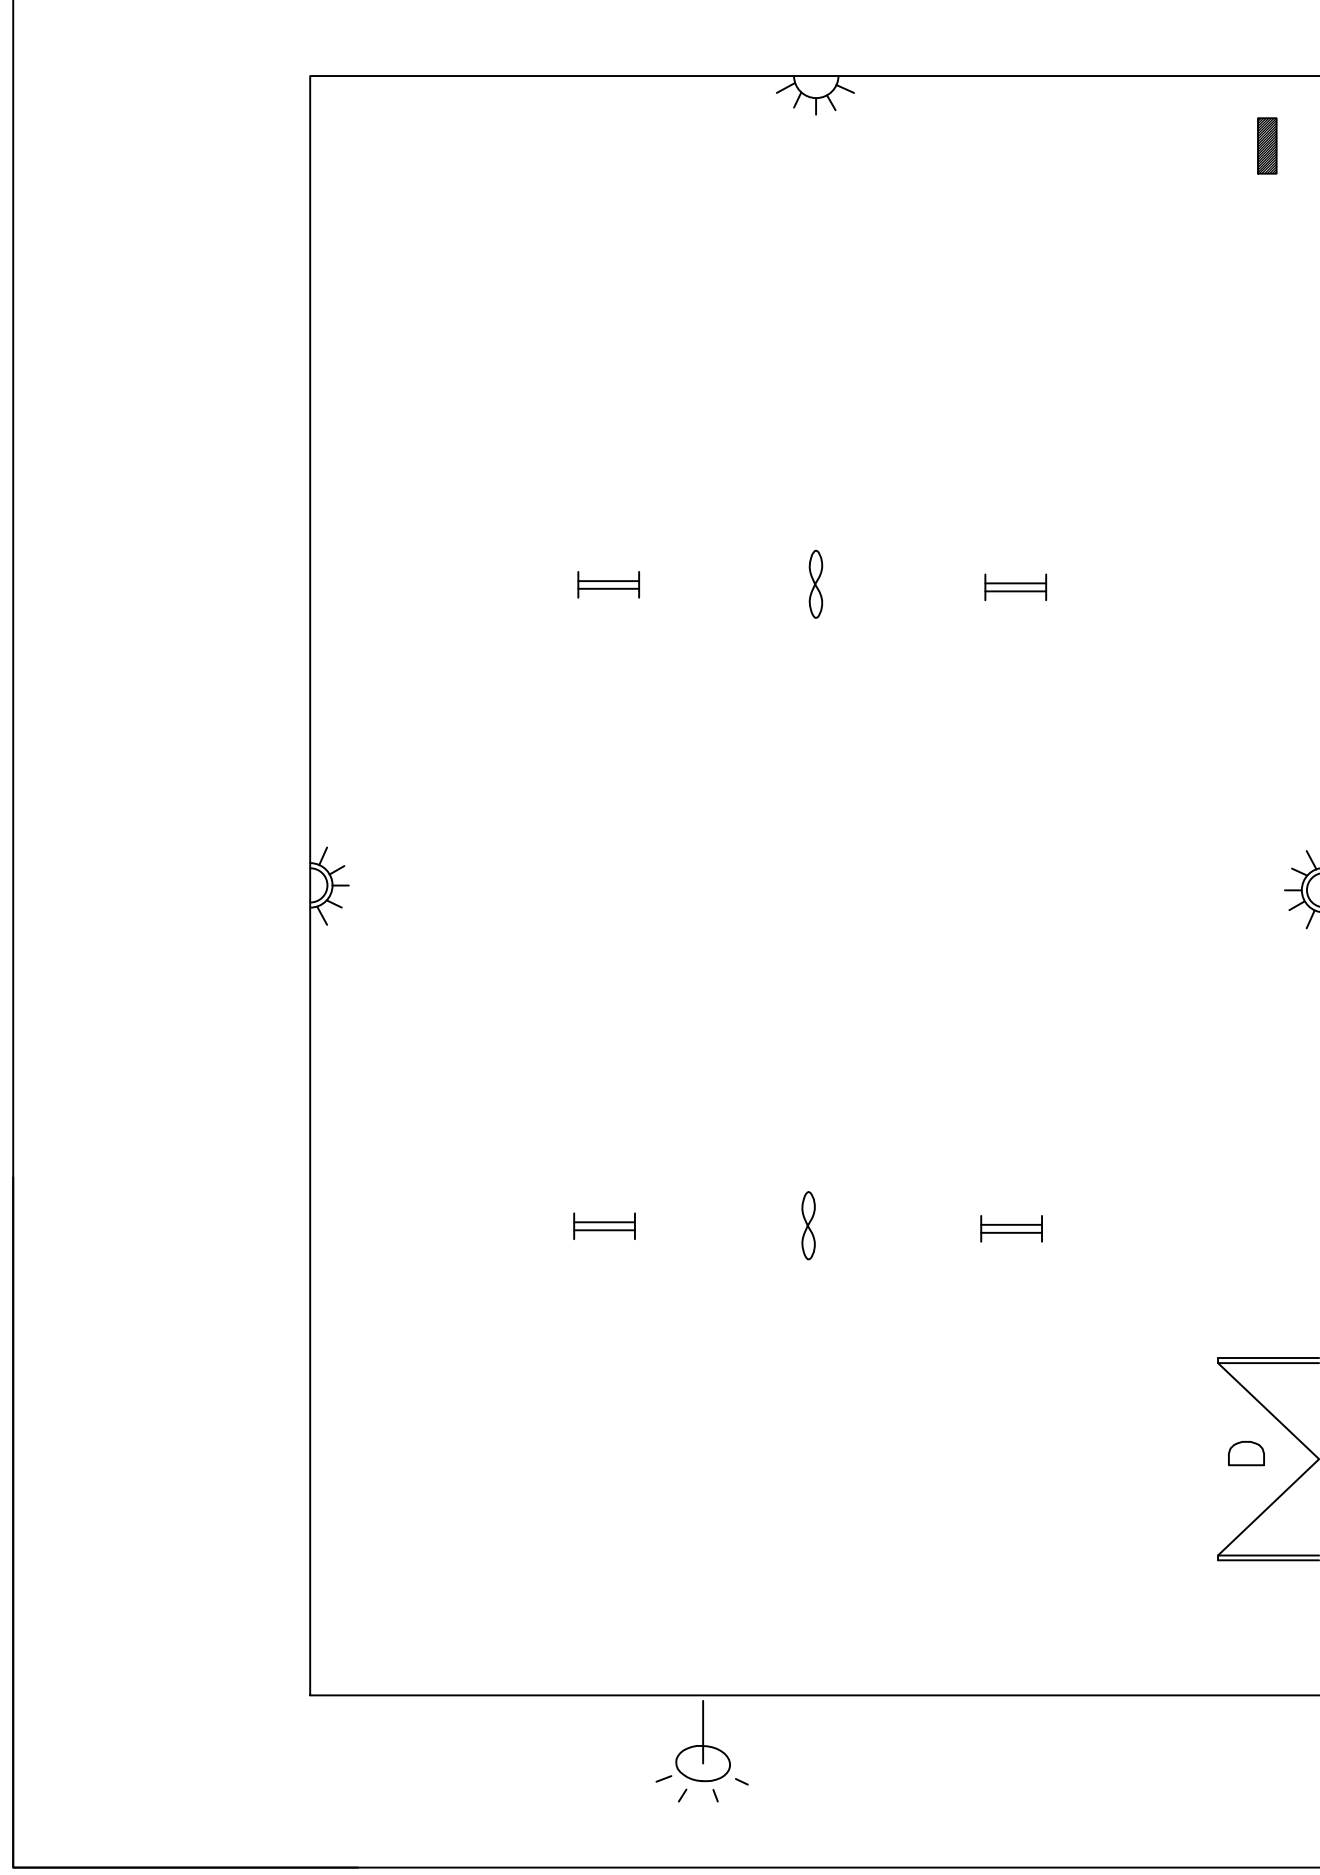

 



 

PLAN OF DISPOSAL YARD OFFICE ROOM

ROOM HEIGHT-3600mm, Width - 5000mm, Length - 8000mm


Note:


* Maximum 800 w per circuit for point wiring.

LEGEND:

-  12W 16A SPN MCB DB - 1 no.  5/15A Plug Socket - 2 nos.
-  5A Plug Socket - 1 no.  150W HPSV street light fitting - 1 no.
-  2x28W TL5 Fitting -4 nos.  Ceiling Fan - 2 nos.

CAUTION: The information on this document is the property of BHARAT HEAVY ELECTRICALS LTD. It must not be used directly or indirectly in any way detrimental to the interest of the company.

TYPE OF PRODUCT OR NAME OF CUSTOMER/PROJECT		POWER PLANT PIPING UNIT- THIRUMAYAM		SIGNATURE		DATE		NO. OF VAR	
 Bharat Heavy Electricals Ltd UNIT: HIGH PRESSURE BOILER PLANT TIRUCHIRAPALLI - 620014		DRN & CHD		NAME		DATE		NO. OF VAR	
		APPD		L. Honey Wood Marry		16.02.2011		16.02.2011	
TITLE		DRAWING NO :		SIGNATURE		DATE		NO. OF VAR	
ELECTRIFICATION OF DISPOSAL YARD OFFICE ROOM		M&S: PD: 11: 015		V. Ragun		16.02.2011		00	
CARD CODE		U 01		REV					

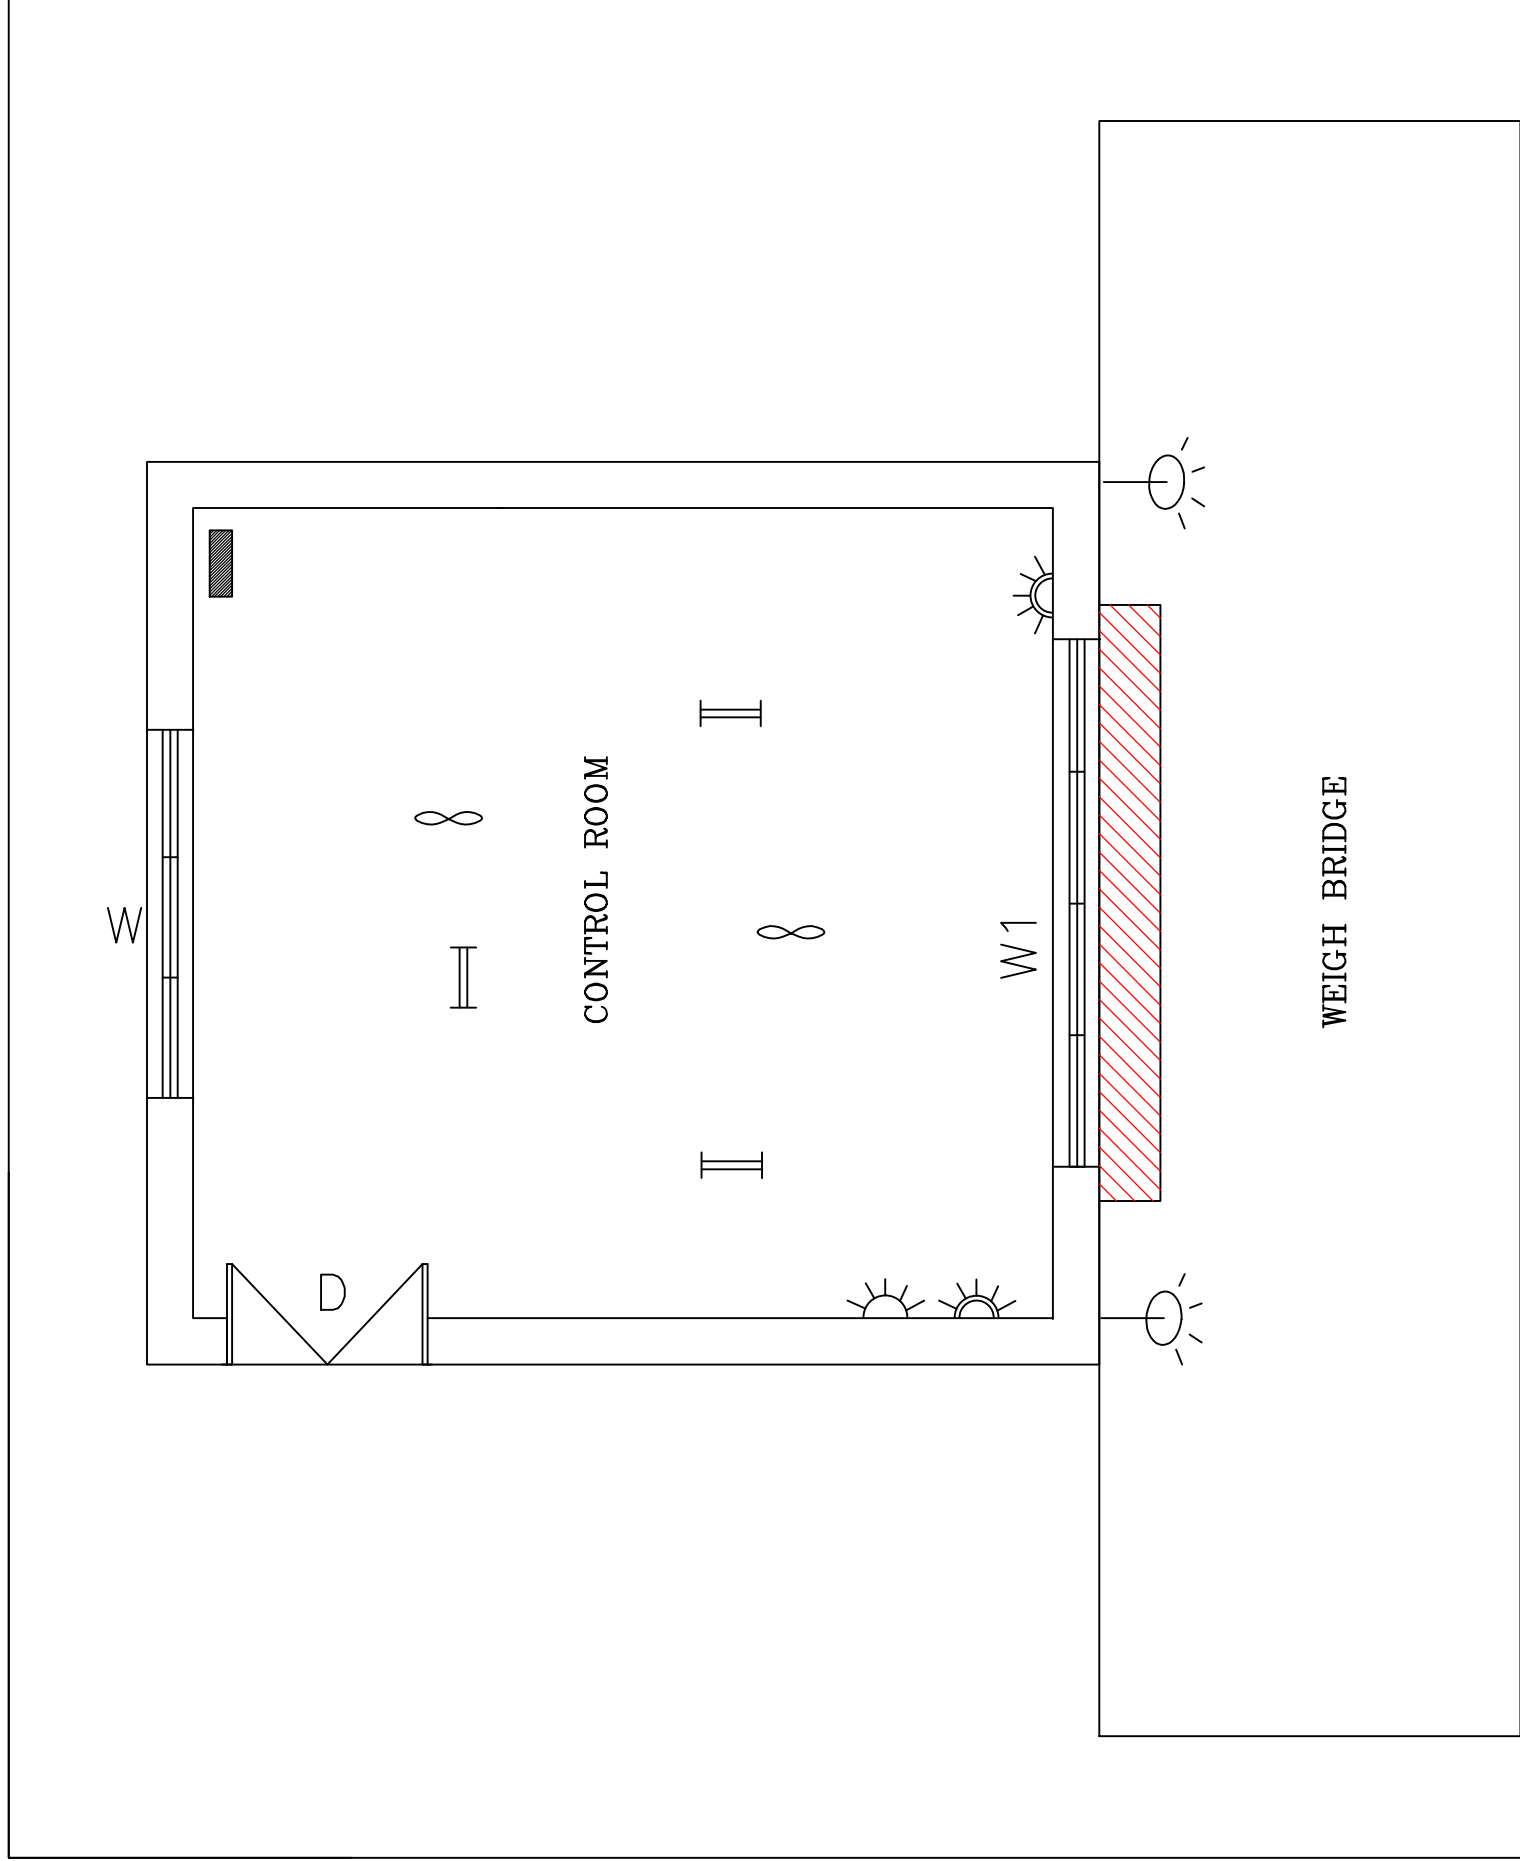

PLAN OF WEIGH BRIDGE & CONTROL ROOM

CONTROL ROOM : HEIGHT-3000mm, Width - 4000mm, Length - 5000mm

WEIGH BRIDGE : Width - 10000mm, Length - 30000mm

Note:


* Maximum 800 w per circuit for point wiring.

LEGEND:

- 12W 16A SPN MCB DB - 1 no.
- ☀ 5A Plug Socket - 1 no.
- ∞ 2x28W TL5 Fitting -3 nos.
- ☀ 5/15A Plug Socket - 2 nos.
- ☀ 150W HPSV street light fitting - 2 nos.
- ∞ Ceiling Fan - 2 nos.


CAUTION: The information on this document is the property of BHARAT HEAVY ELECTRICALS LTD. It must not be used directly or indirectly in any way detrimental to the interest of the company.

TYPE OF PRODUCT OR NAME OF CUSTOMER/PROJECT	POWER PLANT PIPING UNIT- THIRUMAYAM		SIGNATURE	DATE	NO. OF VAR
	Bharat Heavy Electricals Ltd UNIT: HIGH PRESSURE BOILER PLANT TIRUCHIRAPALLI - 620014				
TITLE	ELECTRIFICATION OF WEIGH BRIDGE & CONTROL ROOM	DRN & CHD	NAME	DRAWING NO :	
		APPD	U. Ragu	M&S: PD: 11: 016	REV
		CARD CODE			00
		U 01			

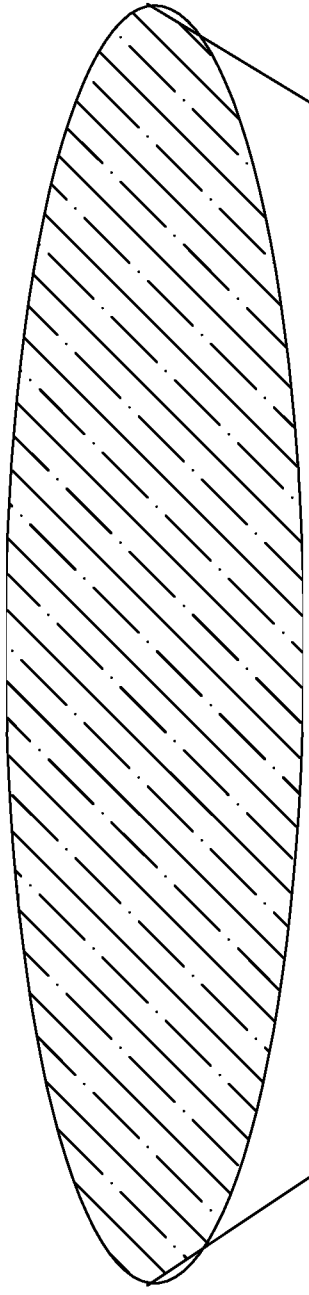


LEGEND:


 PCC — 1 NO.

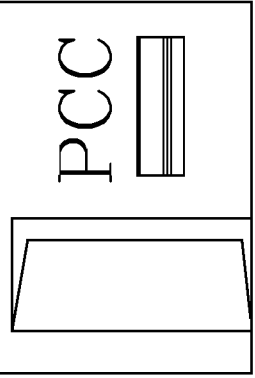

CAUTION: The information on this document is the property of BHARAT HEAVY ELECTRICALS LTD. It must not be used directly or indirectly in any way detrimental to the interest of the company.

TYPE OF PRODUCT OR NAME OF CUSTOMER/PROJECT		POWER PLANT PIPING UNIT - THIRUMAYAM		SIGNATURE		DATE		NO. OF VAR	
 Bharat Heavy Electricals Ltd UNIT: HIGH PRESSURE BOILER PLANT TIRUCHIRAPALLI - 620014		NAME		L. Honey Wood Mary		11.02.2011			
		DRN & CHD		U. Ragu		11.02.2011			
TITLE		CARD CODE		DRAWING NO :		REV			
ELECTRIFICATION OF WATER TANK				M&S: PD: 11: 017		00			

ALL DIMENSIONS ARE IN MILLIMETERS

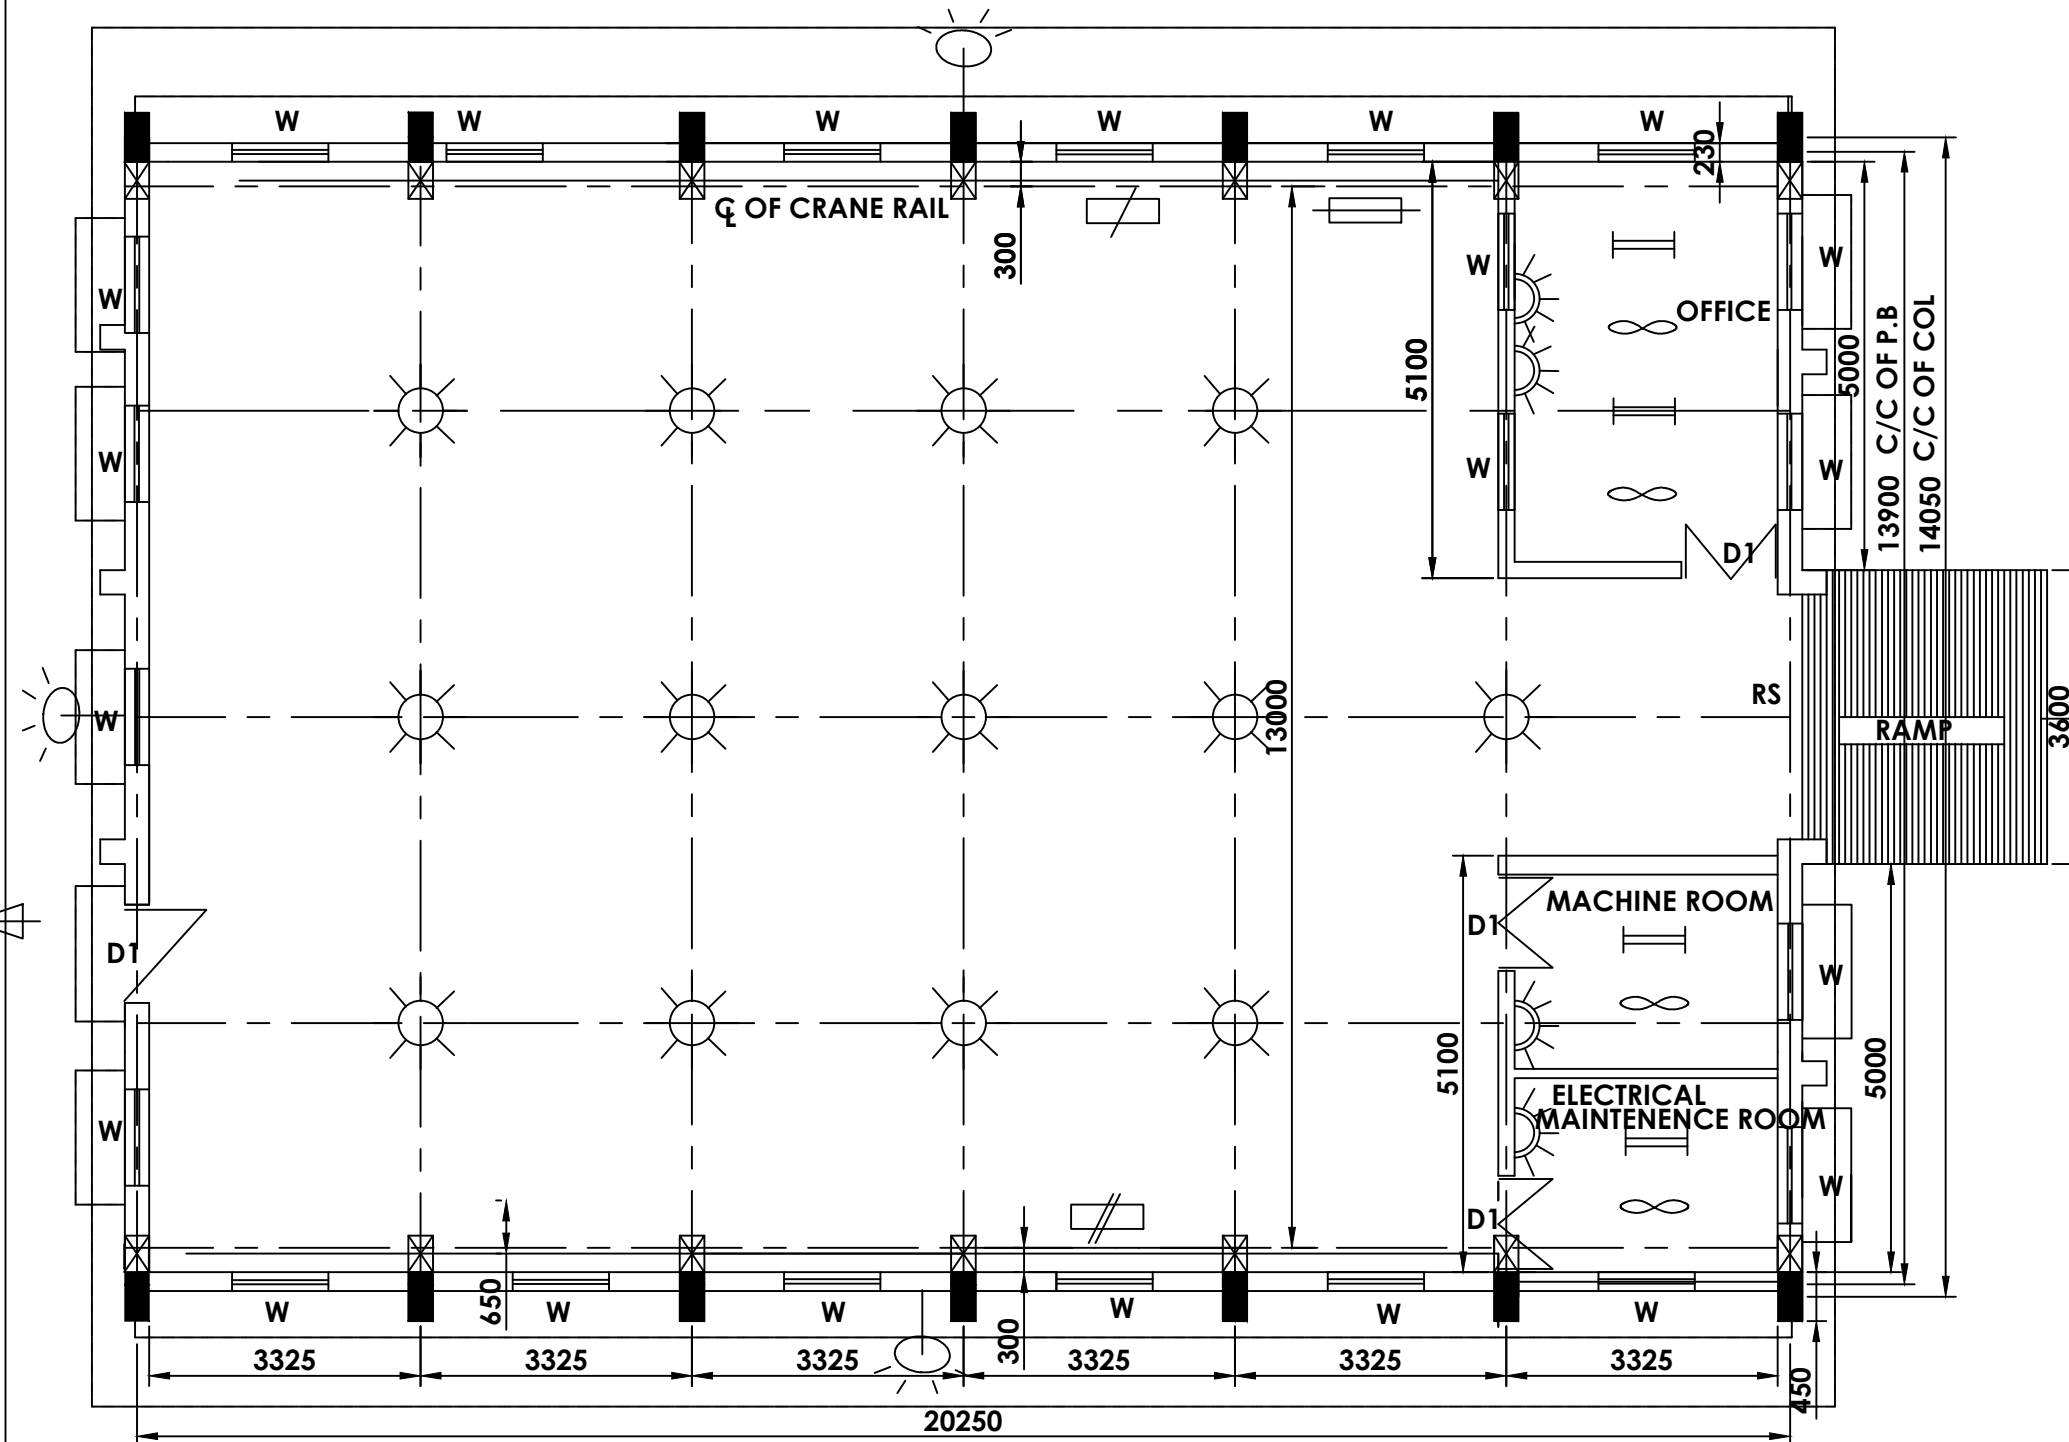

DIMENSION:

- Width - 14000mm
- Length - 20000mm
- Height - 8500mm
(Compressor Area)
- Height - 2400mm (Office, Machine room, Electrical maintenance room)


LEGANDS:

- Ceiling Fan - 4 nos
- 5/15A Plug Socket - 4 nos.
- 150W HPSV street light fitting - 4 nos.
- 250w MH Light-13 nos
- 8W 16A, 7Seg MCB DB - 1no
- 8W 32A 4SEG MCB DB - 1 no.
- 2x28W TL Fitting- 4 nos
- Industrial switch board - 1 no.

PLAN

CAUTION: The information on this document is the property of BHARAT HEAVY ELECTRICALS LTD. It must not be used directly or indirectly in any way detrimental to the interest of the company.

TYPE OF PRODUCT OR NAME OF CUSTOMER/PROJECT		POWER PLANT PIPING UNIT- THIRUMAYAM			
	Bharat Heavy Electricals Ltd	DRN & CHD	NAME <i>L. Honey Wood Mary</i>	SIGNATURE <i>[Signature]</i>	DATE 13.02.2011
	UNIT: HIGH PRESSURE BOILER PLANT TIRUCHIRAPALLI - 620014	APPD	<i>V. Ragu</i>	<i>[Signature]</i>	13.02.2011
TITLE ELECTRIFICATION OF COMPRESSOR AIR PLANT		CARD CODE U 01	DRAWING NO : M&S: PD: 11: 018		REV 01

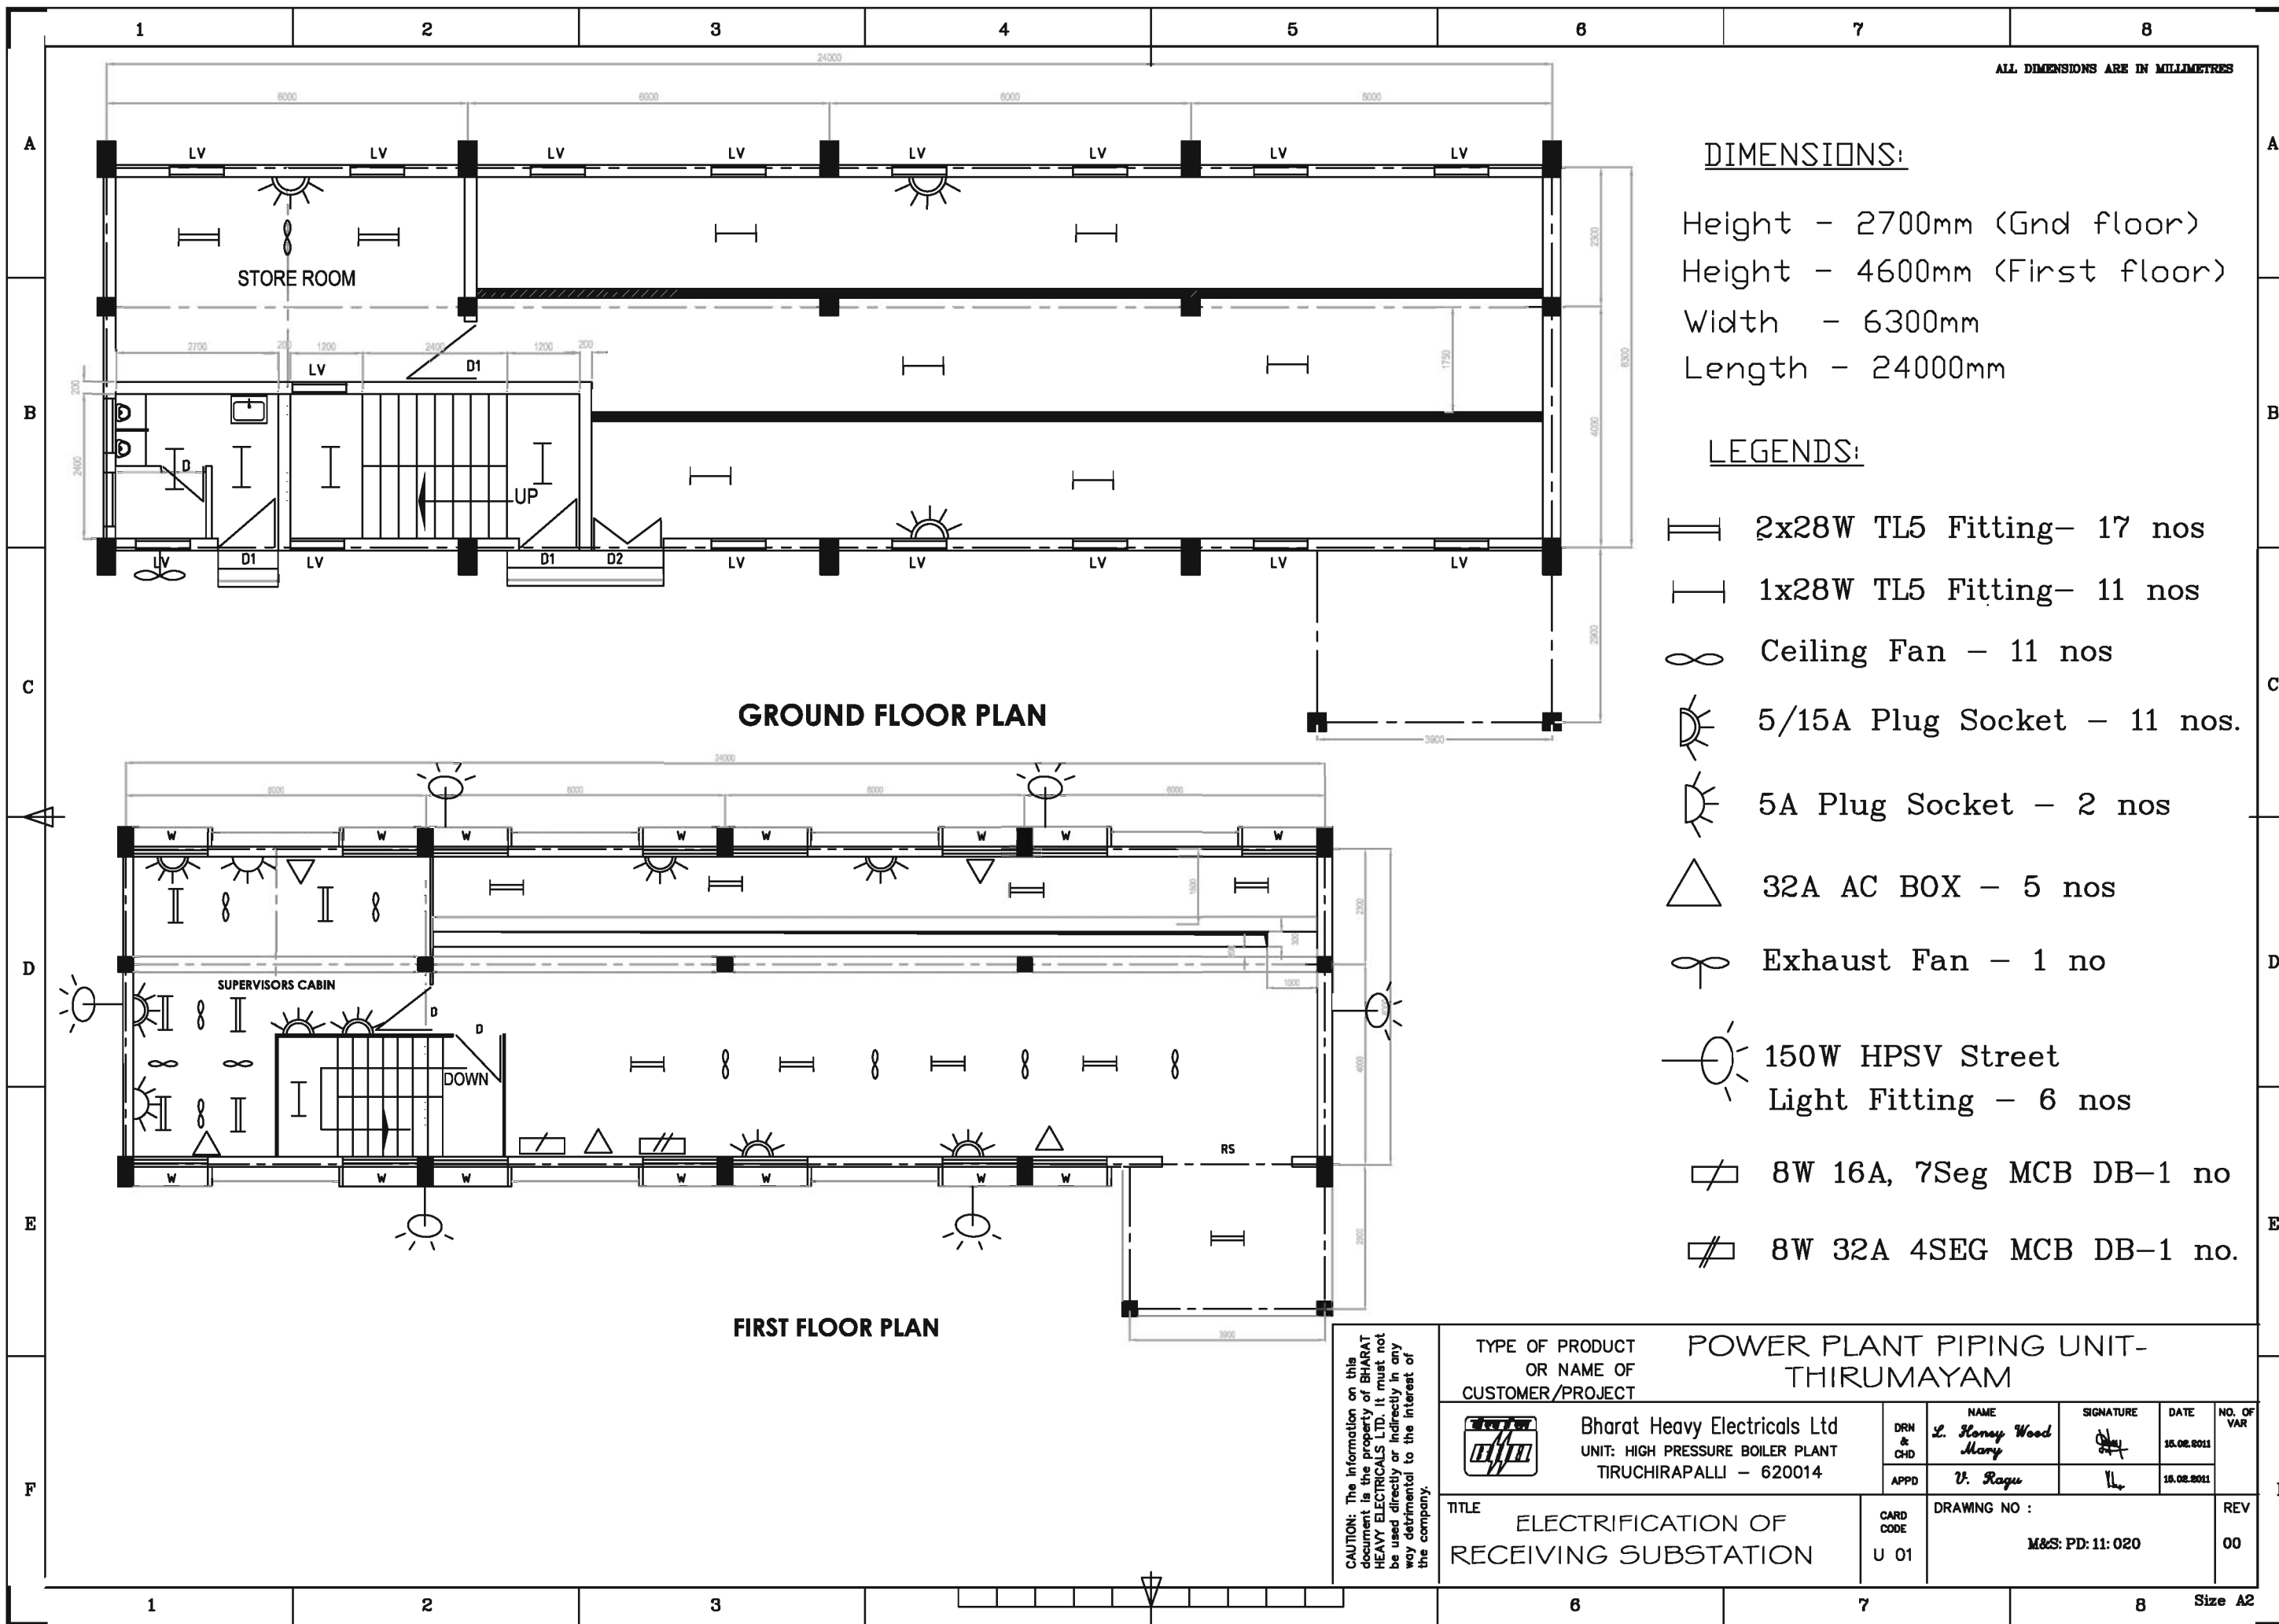

ALL DIMENSIONS ARE IN MILLIMETRES

DIMENSIONS:

- Height - 2700mm (Gnd floor)
- Height - 4600mm (First floor)
- Width - 6300mm
- Length - 24000mm

LEGENDS:


- 2x28W TL5 Fitting- 17 nos
- 1x28W TL5 Fitting- 11 nos
- Ceiling Fan - 11 nos
- 5/15A Plug Socket - 11 nos.
- 5A Plug Socket - 2 nos
- 32A AC BOX - 5 nos
- Exhaust Fan - 1 no
- 150W HPSV Street Light Fitting - 6 nos
- 8W 16A, 7Seg MCB DB-1 no
- 8W 32A 4SEG MCB DB-1 no.

GROUND FLOOR PLAN

FIRST FLOOR PLAN


 

 
 
 
CAUTION: The information on this document is the property of BHARAT HEAVY ELECTRICALS LTD. It must not be used directly or indirectly in any way detrimental to the interest of the company.

TYPE OF PRODUCT OR NAME OF CUSTOMER/PROJECT		POWER PLANT PIPING UNIT- THIRUMAYAM					
	Bharat Heavy Electricals Ltd UNIT: HIGH PRESSURE BOILER PLANT TIRUCHIRAPALLI - 620014		DRN & CHD	NAME <i>L. Honey Wood Mary</i>	SIGNATURE <i>[Signature]</i>	DATE 15.02.2011	NO. OF VAR
			APPD	<i>V. Ragu</i>	<i>[Signature]</i>	15.02.2011	
TITLE ELECTRIFICATION OF RECEIVING SUBSTATION			CARD CODE U 01	DRAWING NO : M&S: PD: 11: 020		REV 00	

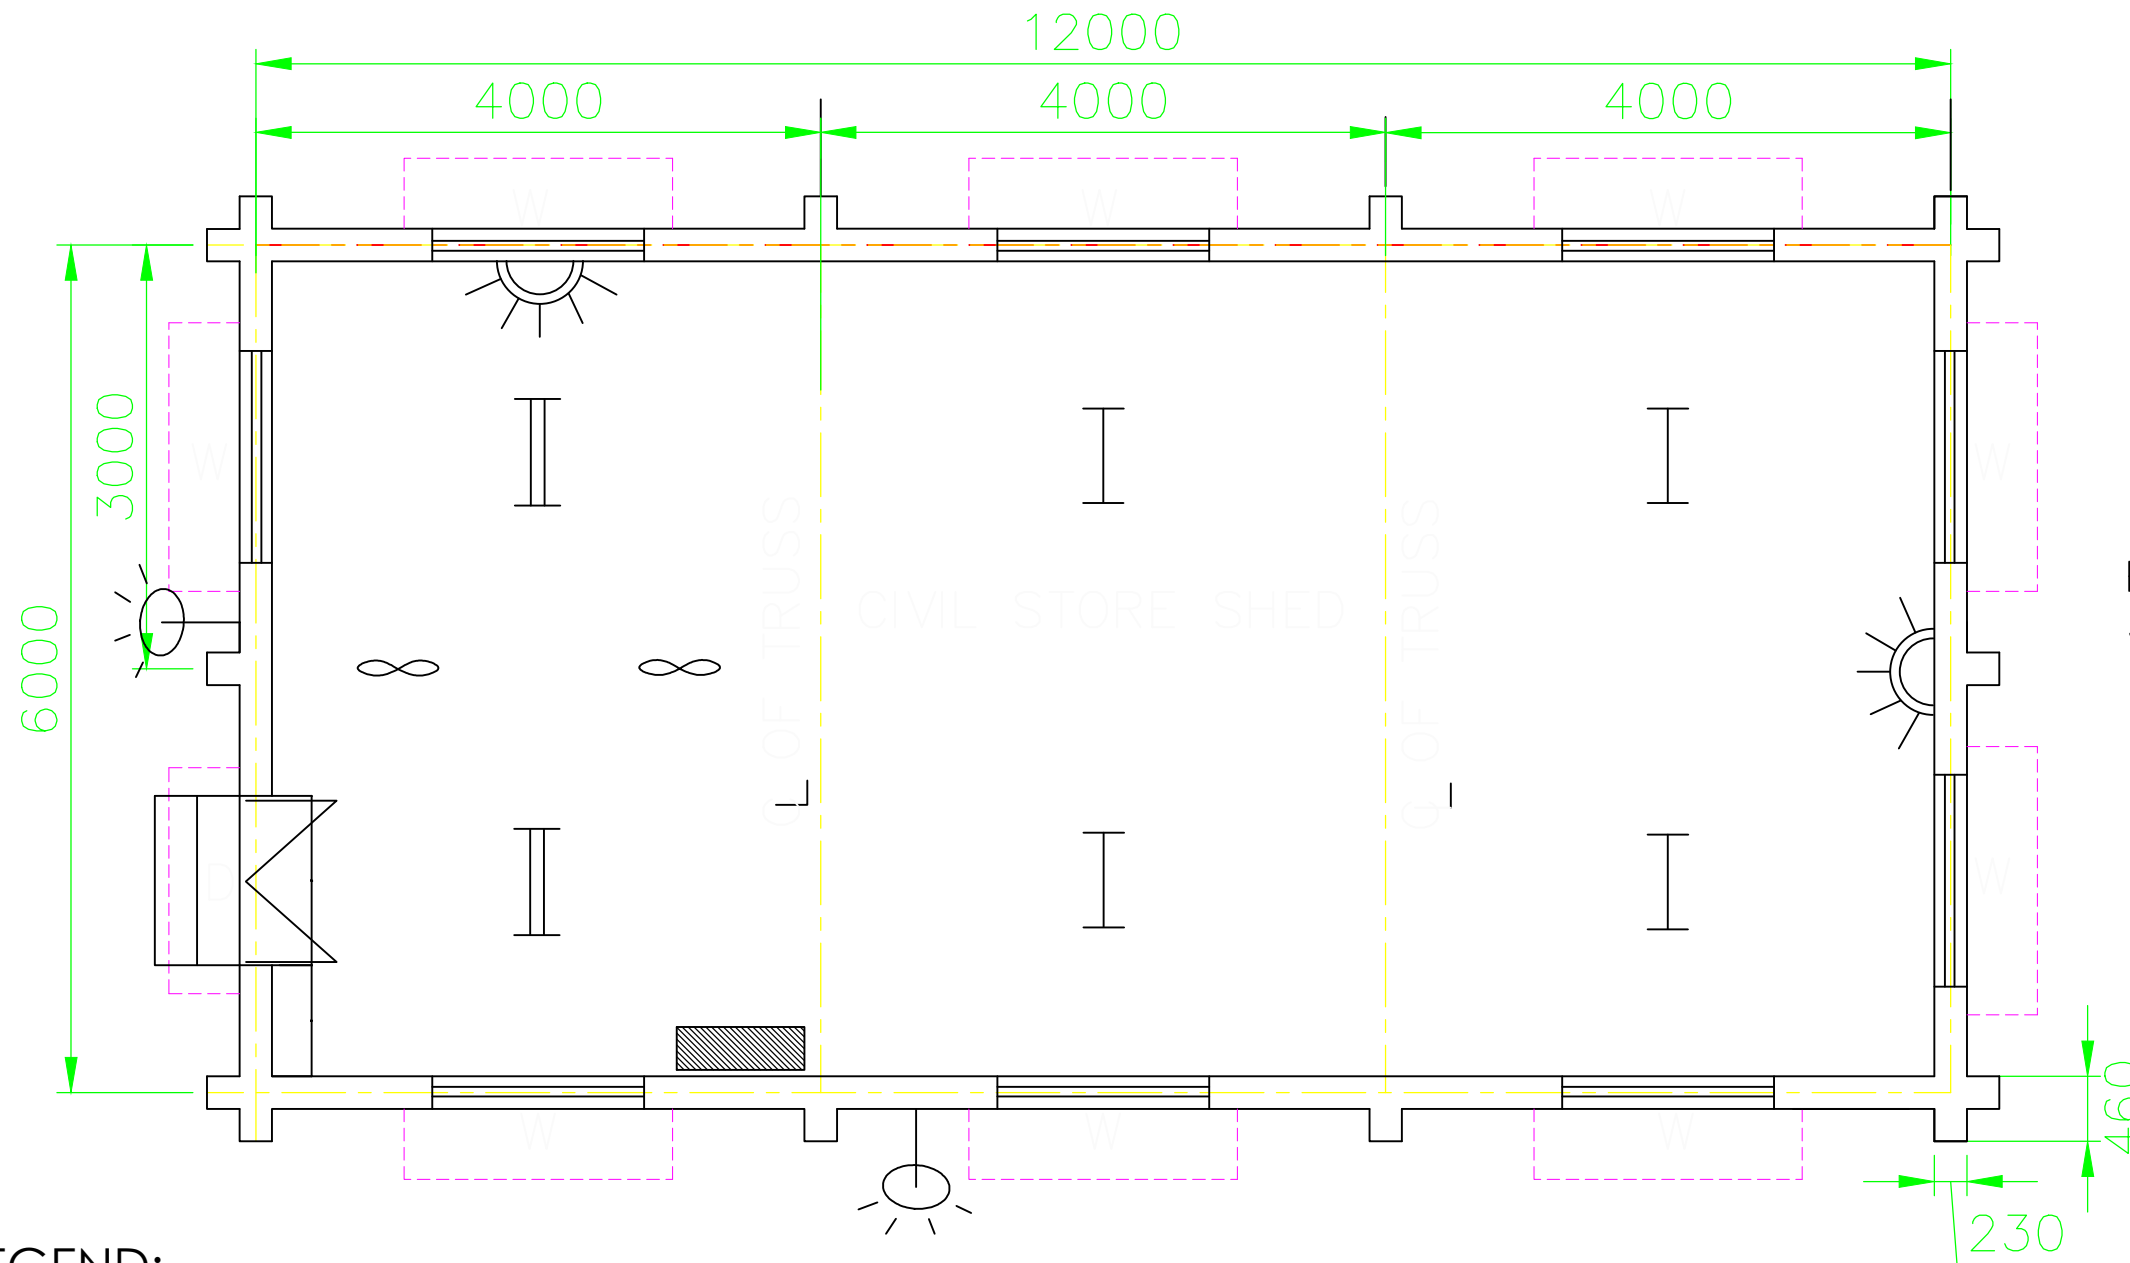
 


DIMENSION:
 Height - 5000mm
 Width - 6000mm
 Length - 12000mm


LEGEND:

-  150W HPSV Street Light Fitting - 2 nos.
-  1 x 28W TL5 Fitting- 4 nos
-  12W 16A SPN MCB DB - 1 nos.
-  2 x 28W TL5 Fitting- 2 nos
-  Ceiling Fan - 2 nos
-  5/15A Plug Socket - 2 nos.


PLAN

<small>CAUTION: The information on this document is the property of BHARAT HEAVY ELECTRICALS LTD. It must not be used directly or indirectly in any way detrimental to the interest of the company.</small>	TYPE OF PRODUCT OR NAME OF CUSTOMER/PROJECT		POWER PLANT PIPING UNIT- THIRUMAYAM			
	 Bharat Heavy Electricals Ltd UNIT: HIGH PRESSURE BOILER PLANT TIRUCHIRAPALLI - 620014	DRN & CHD	NAME	SIGNATURE	DATE	NO. OF VAR
		APPD	V. Ragu		15.02.2011	
TITLE	ELECTRIFICATION OF CIVIL STORE SHED		CARD CODE	DRAWING NO : M&S: PD: 11: 021		REV
			U 01			00

ALL DIMENSIONS ARE IN MILLIMETERS

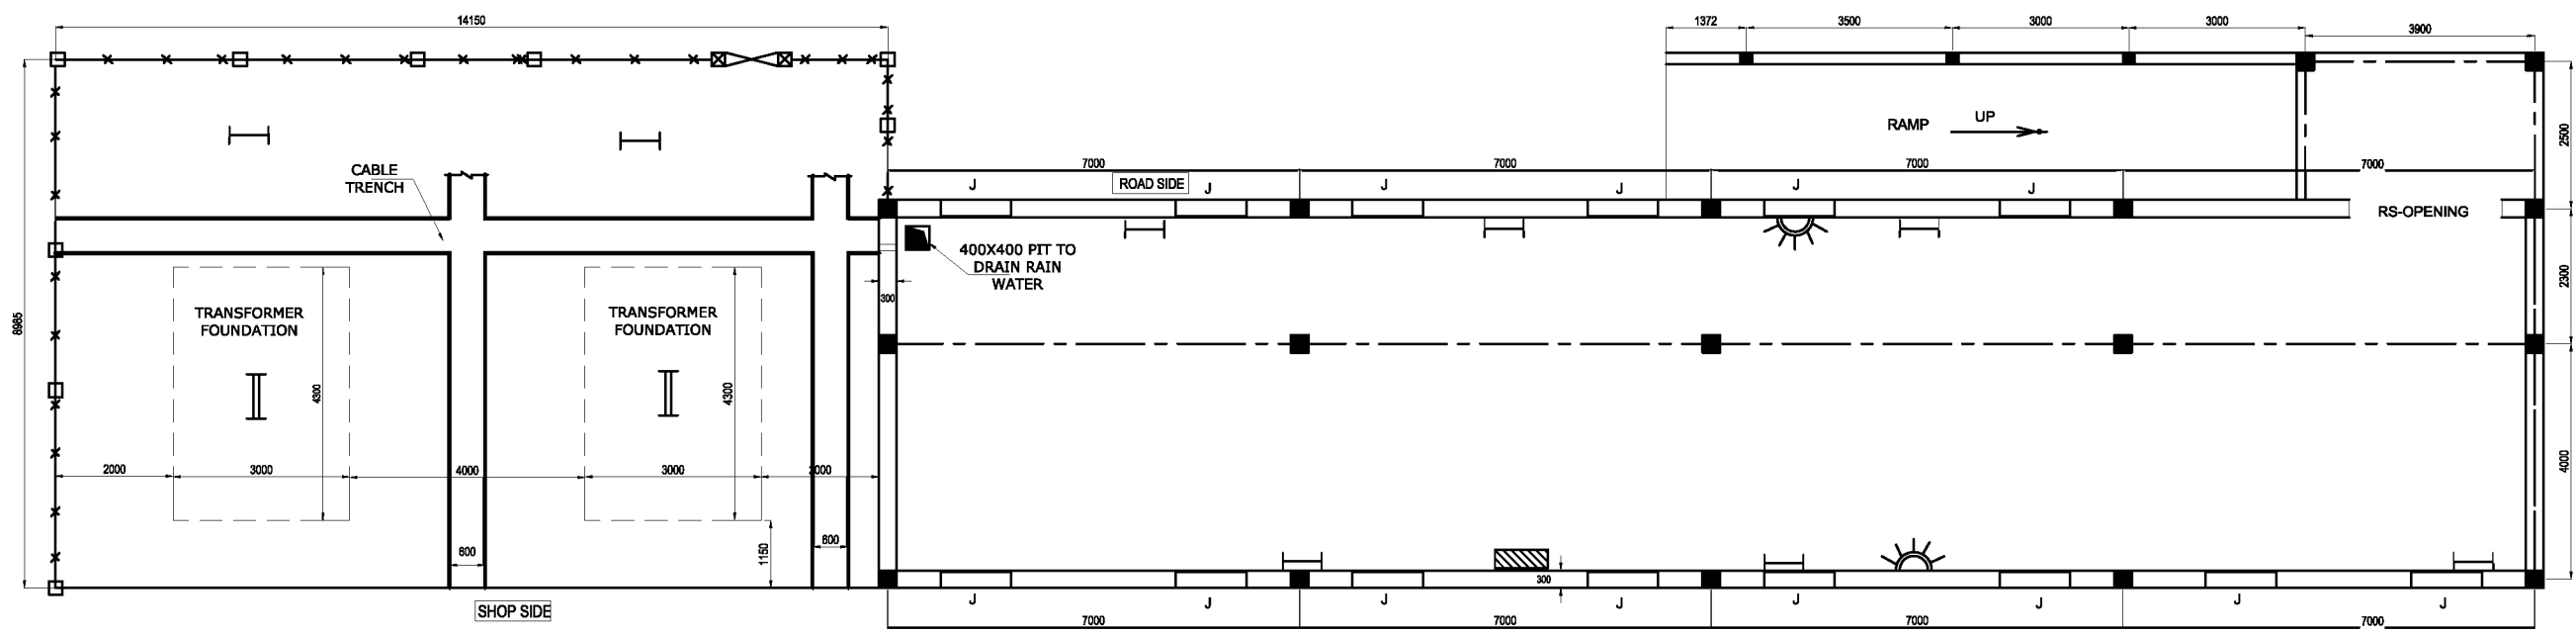

GROUND FLOOR PLAN

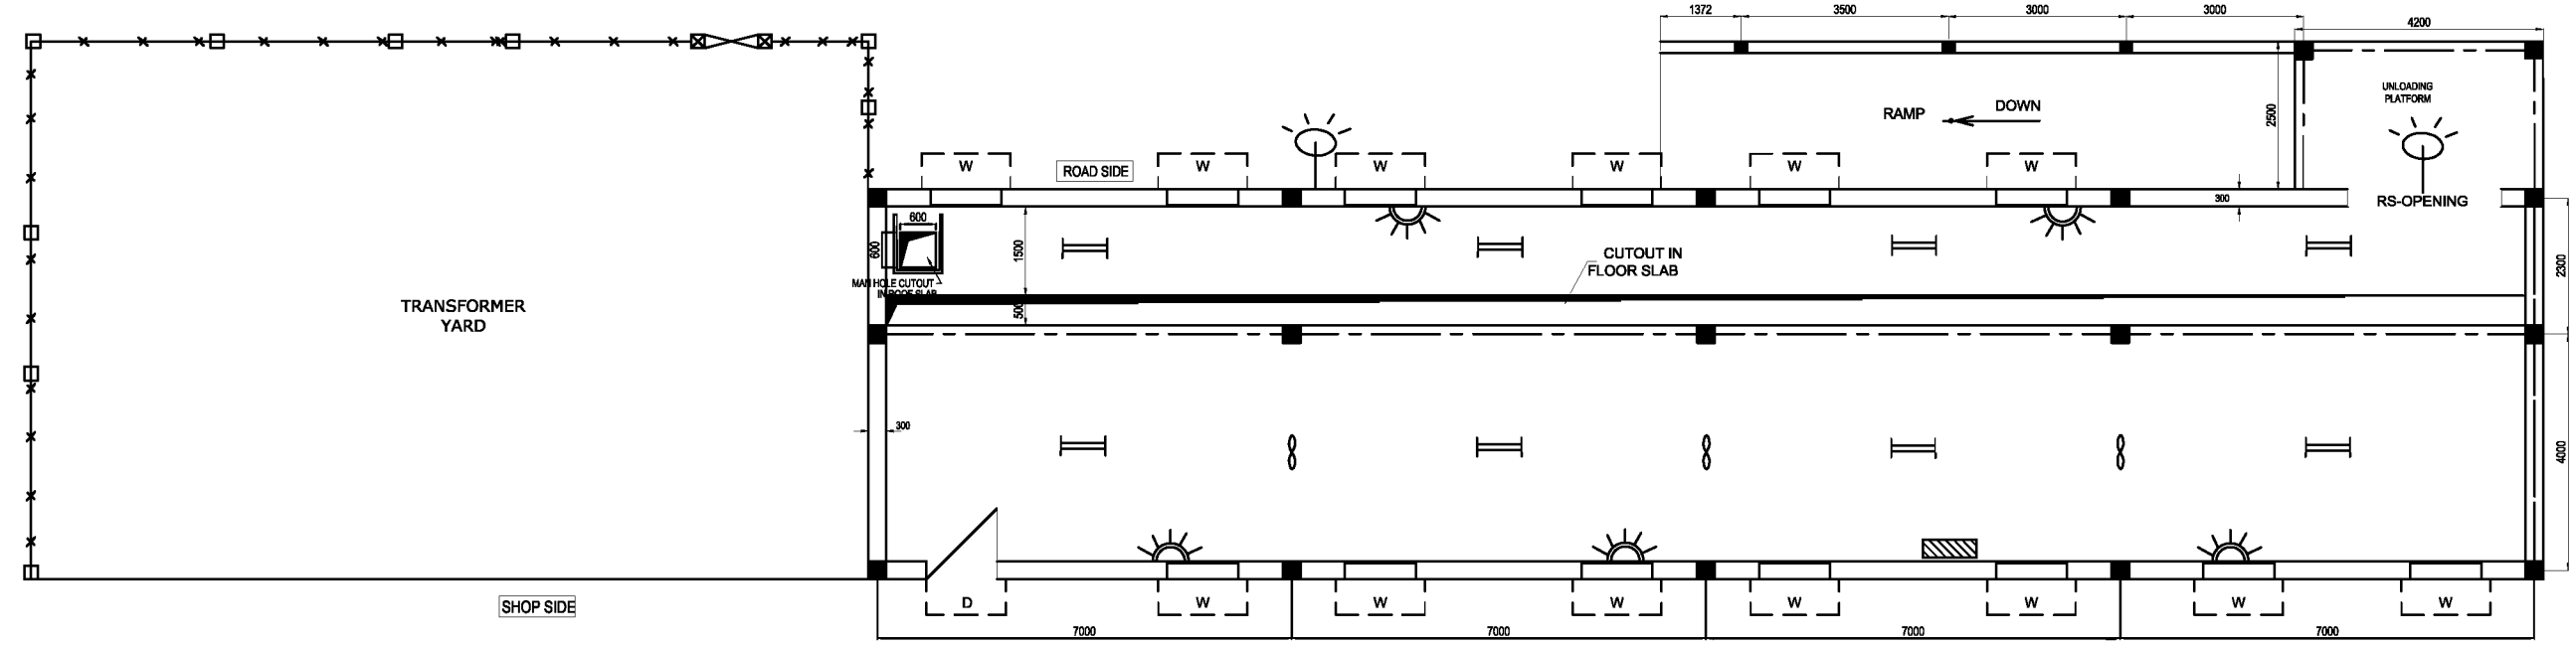

FIRST FLOOR PLAN

LEGANDS:

- Ceiling Fan - 3 nos
- 5/15A Plug Socket - 7 nos.
- 12W 16A SPN MCB DB - 2 nos.
- 1x28W TL5 Fitting- 8 nos
- 2x28W TL5 Fitting- 10 nos
- 150W HPSV street light fitting - 2 nos

DIMENSION:

Height - 2000mm (Gnd floor)
 Height - 4000mm (First floor)
 Width - 6300mm
 Length - 28000mm

CAUTION: The information on this document is the property of BHARAT HEAVY ELECTRICALS LTD. It must not be used directly or indirectly in any way detrimental to the interest of the company.

TYPE OF PRODUCT OR NAME OF CUSTOMER/PROJECT		POWER PLANT PIPING UNIT- THIRUMAYAM			
	Bharat Heavy Electricals Ltd	DRN & CHD	NAME	SIGNATURE	DATE
	UNIT: HIGH PRESSURE BOILER PLANT TIRUCHIRAPALLI - 620014	APPD	L. Honey Wood Mary		17.02.2011
TITLE		CARD CODE	DRAWING NO :		REV
ELECTRIFICATION OF SUBSTATION - I		U 01	M&S: PD: 11: 022		01