




ALL DIMENSIONS ARE IN MILLIMETRES

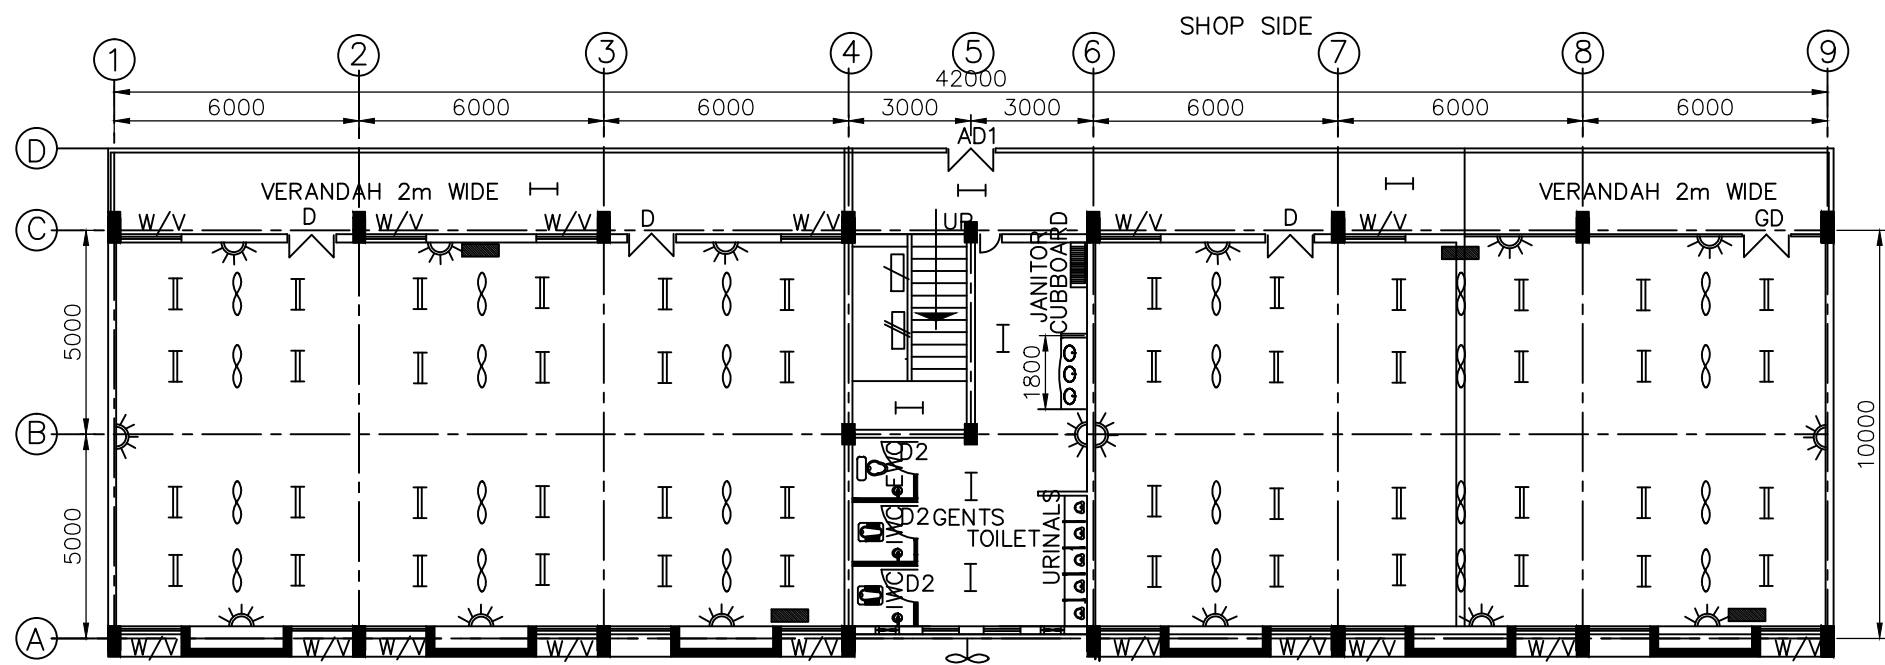

GROUND FLOOR PLAN

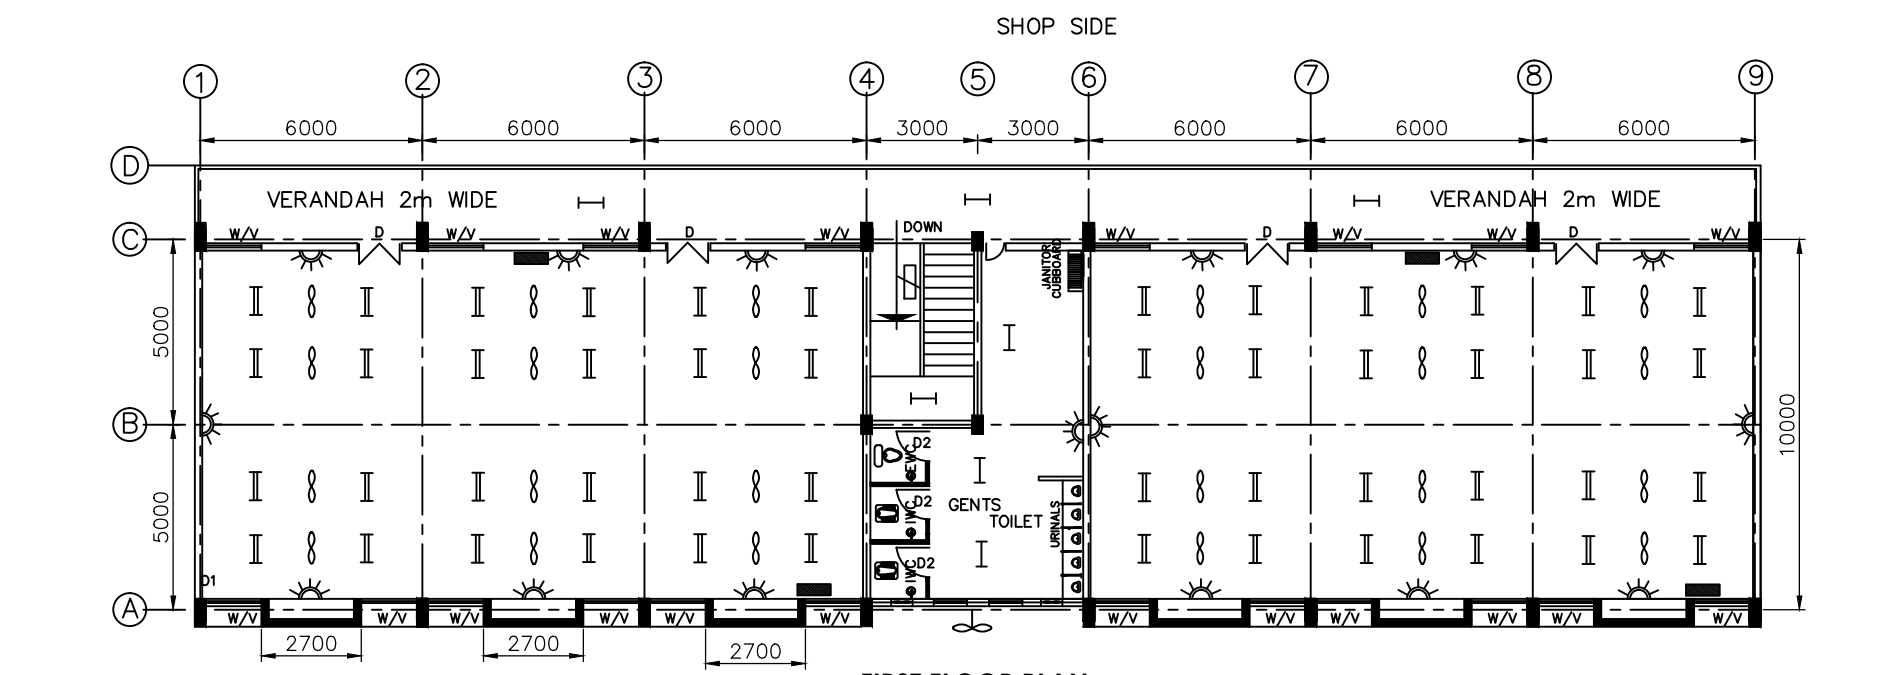

FIRST FLOOR PLAN

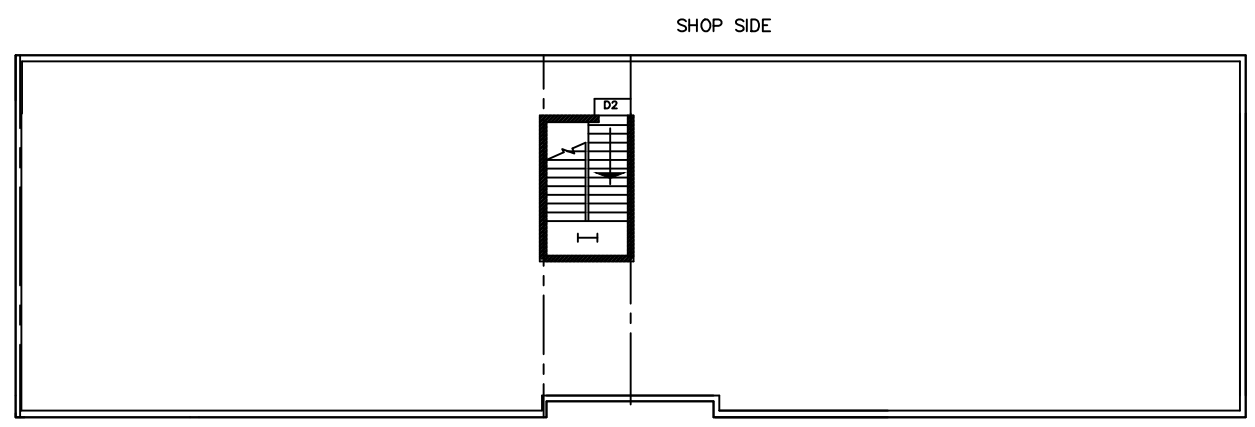

OPEN TERRACE PLAN

DIMENSION:

- Height - 4000mm (Gnd floor)
- Height - 4000mm (First floor)
- Width - 12000mm
- Length - 42000mm


LEGENDS:

- 5/15A Plug Socket - 32 nos.
- 1x28W TL5 Fitting - 14 nos
- 2x28W TL5 Fitting - 96 nos
- Ceiling Fan - 48 nos
- Exhaust Fan - 2 nos
- 12W 16A SPN MCB DB - 8 nos.
- 8W 16A, 7Seg MCB DB - 2 no.
- 8W 32A 4SEG MCB DB - 1 no.


CAUTION: The information on this document is the property of BHARAT HEAVY ELECTRICALS LTD. It must not be used directly or indirectly in any way detrimental to the interest of the company.

TYPE OF PRODUCT OR NAME OF CUSTOMER/PROJECT		POWER PLANT PIPING UNIT- THIRUMAYAM			
	Bharat Heavy Electricals Ltd	DRN & CHD	NAME L. Honey Wood	SIGNATURE	DATE 21.02.2011
	UNIT: HIGH PRESSURE BOILER PLANT TIRUCHIRAPALLI - 620014	APPD	V. Ragu		21.02.2011
TITLE		CARD CODE	DRAWING NO :		REV
ELECTRIFICATION OF MMO CABIN I			M&S: PD: 11: 024		01

ALL DIMENSIONS ARE IN MILLIMETRES

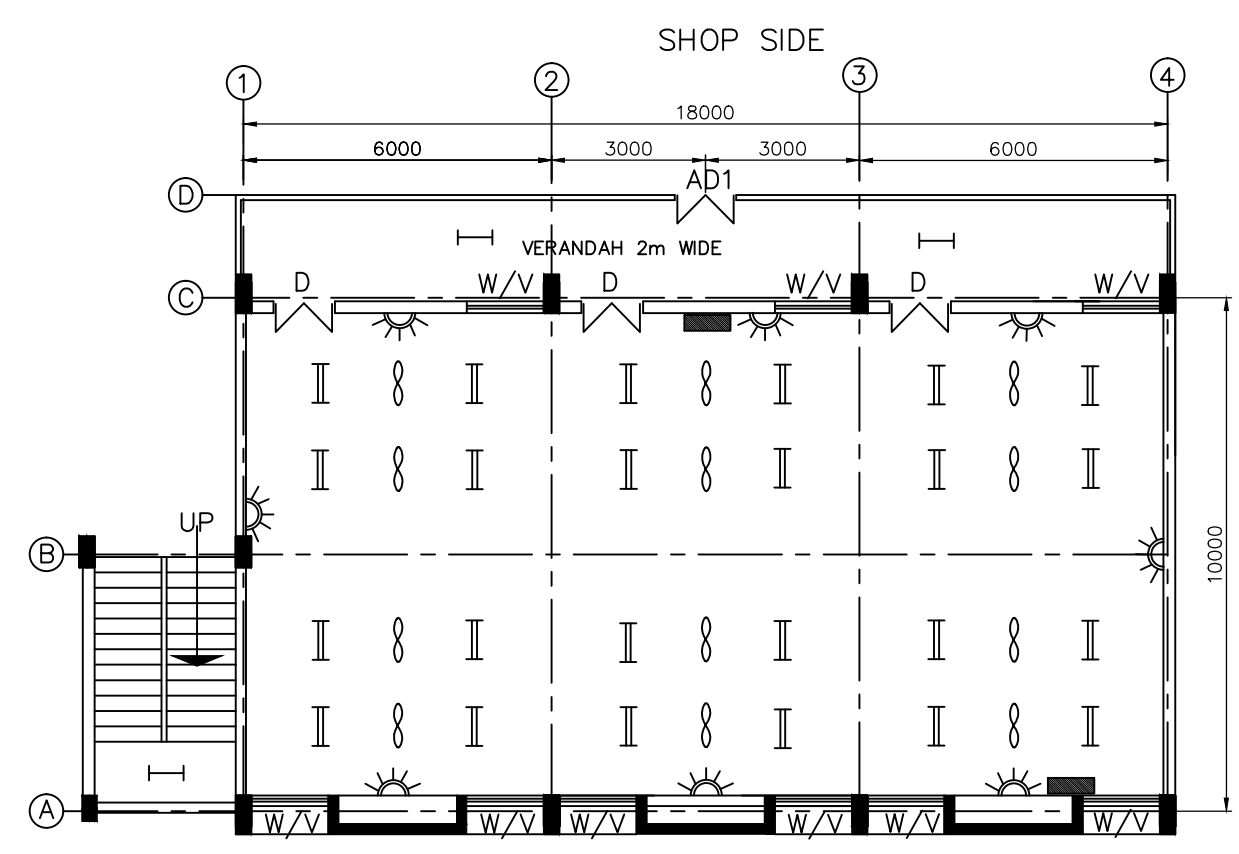

FIRST FLOOR PLAN

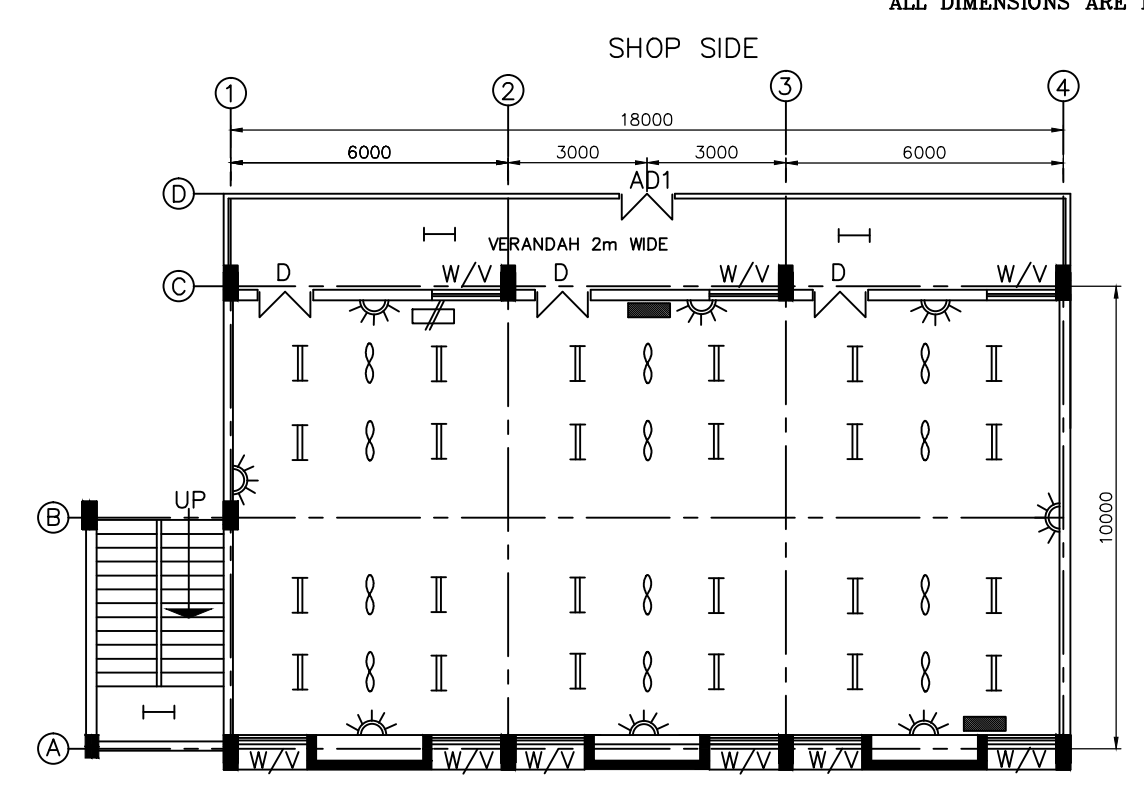


GROUND FLOOR PLAN

DIMENSION:

- Height - 4000mm (Gnd floor)
- Height - 4000mm (First floor)
- Width - 5000mm
- Length - 15000mm

LEGEND:

- Ceiling Fan - 24 nos
- 5/15A Plug Socket - 16 nos.
- 1x28W TL5 Fitting - 6 nos
- 2x28W TL5 Fitting - 48 nos
- 12W 16A SPN MCB DB - 4 nos.
- 8W 32A 4SEG MCB DB - 1 no.

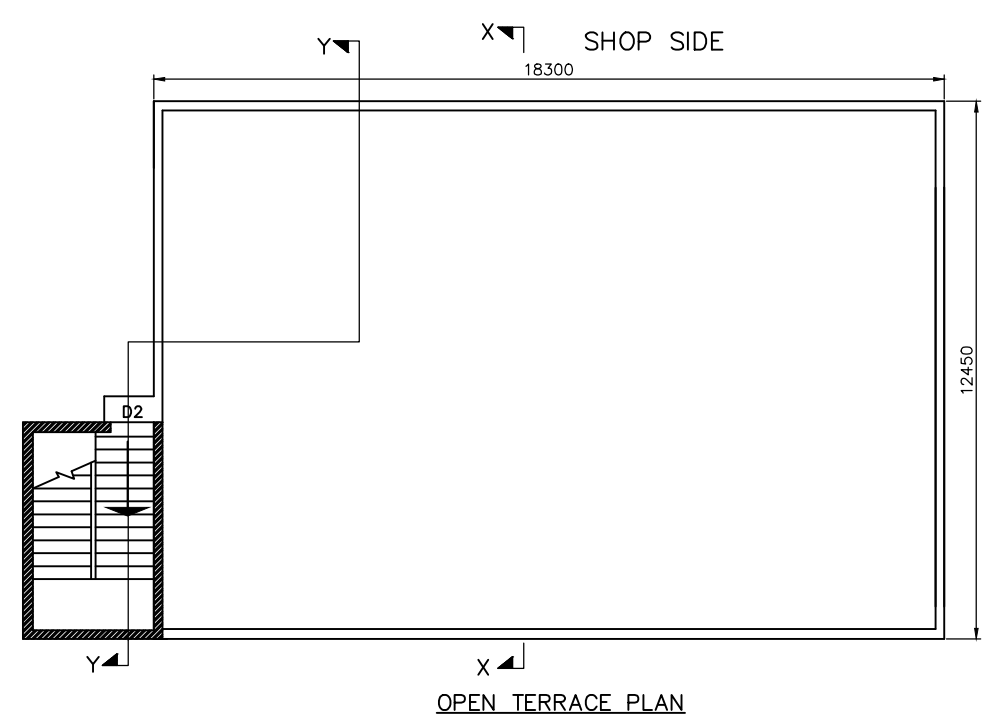


OPEN TERRACE PLAN


CAUTION: The information on this document is the property of BHARAT HEAVY ELECTRICALS LTD. It must not be used directly or indirectly in any way detrimental to the interest of the company.

TYPE OF PRODUCT OR NAME OF CUSTOMER/PROJECT		POWER PLANT PIPING UNIT- THIRUMAYAM				
	Bharat Heavy Electricals Ltd UNIT: HIGH PRESSURE BOILER PLANT TIRUCHIRAPALLI - 620014	DRN & CHD	NAME L. Honey Wood Mary	SIGNATURE	DATE 24.02.2011	NO. OF VAR
		APPD	V. Ragu		24.02.2011	
TITLE		CARD CODE	DRAWING NO :		REV	
ELECTRIFICATION OF MMO CABIN 2		U 01	M&S: PD: 11: 025		01	


ALL DIMENSIONS ARE IN MILLIMETRES

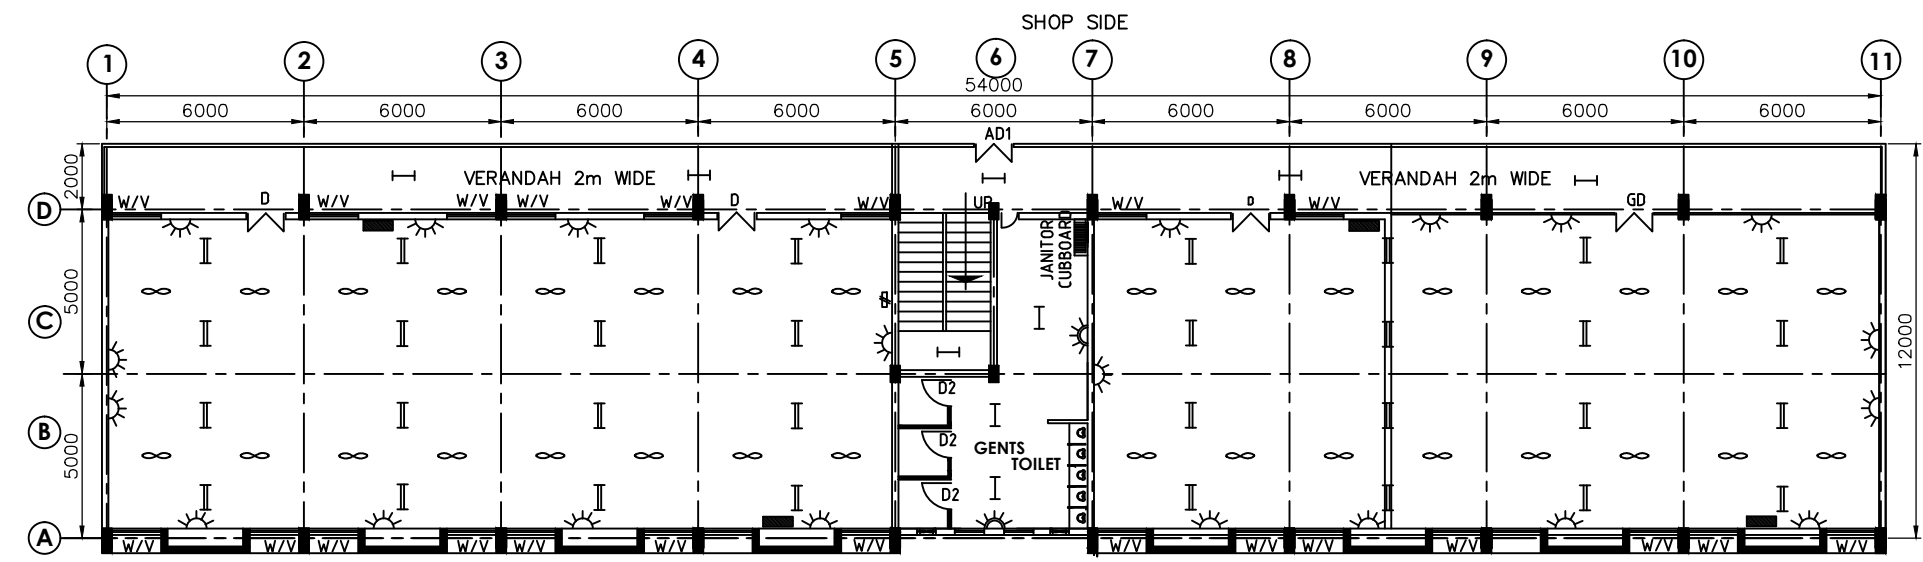

GROUND FLOOR PLAN

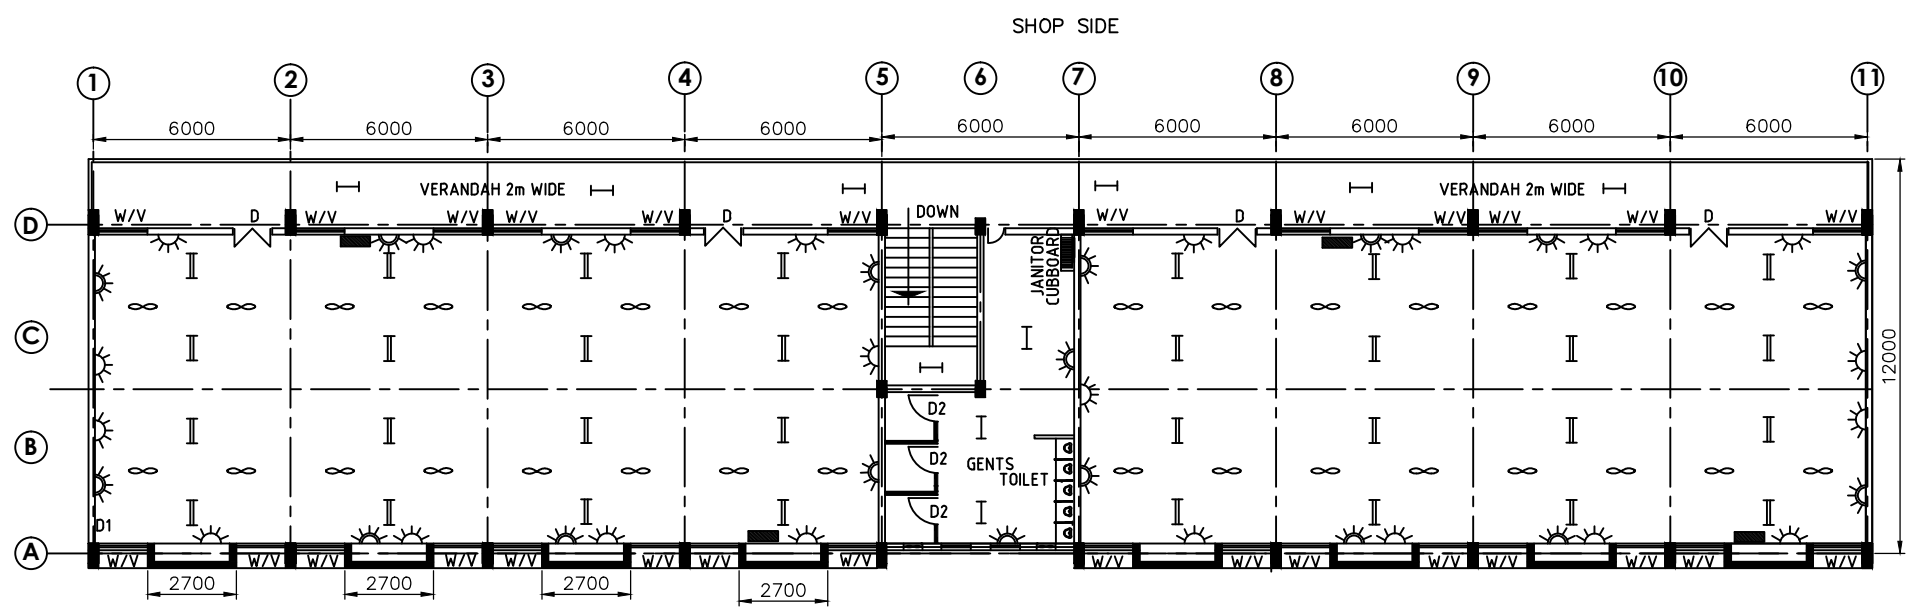

FIRST FLOOR PLAN

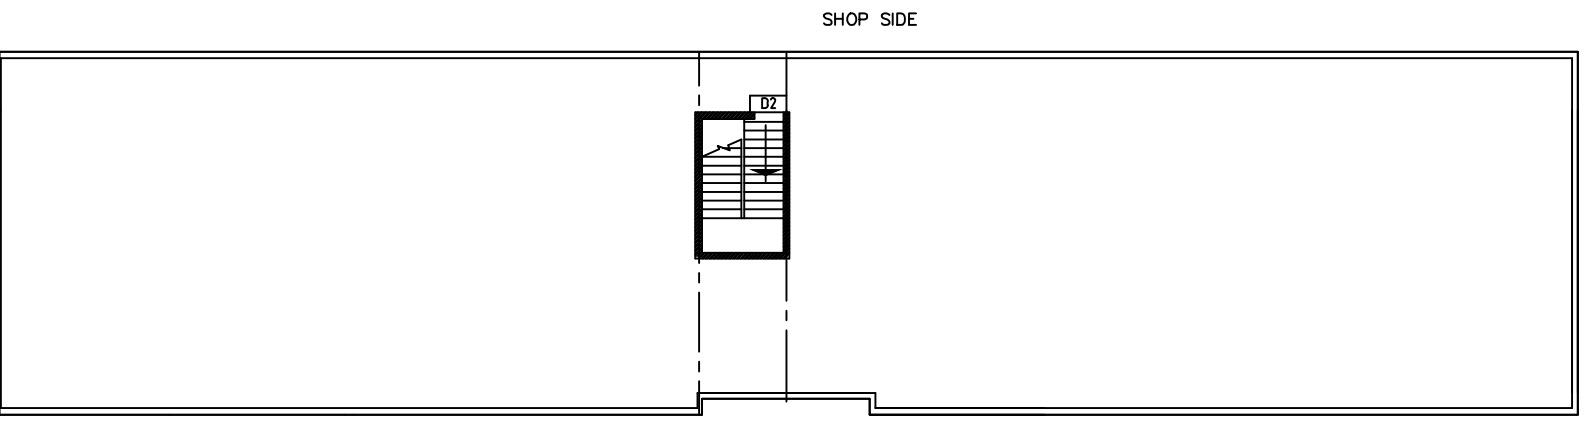

 


 



OPEN TERRACE PLAN


DIMENSION:


- Height - 4000mm (Gnd floor)
- Height - 4000mm (First floor)
- Width - 12000mm
- Length - 54000mm

LEGENDS

-  5/15A Plug Socket - 16 nos
-  5A Plug Socket - 44 nos
-  Ceiling Fan - 64 nos
-  12W 16A SPN MCB DB - 8 nos.
-  2x28W TL5 Fitting - 64 nos
-  1x28W TL5 Fitting - 19 nos
-  8W 32A, 4Seg MCB DB - 1 no

CAUTION: The information on this document is the property of BHARAT HEAVY ELECTRICALS LTD. It must not be used directly or indirectly in any way detrimental to the interest of the company.

TYPE OF PRODUCT OR NAME OF CUSTOMER/PROJECT		POWER PLANT PIPING UNIT- THIRUMAYAM					
	Bharat Heavy Electricals Ltd UNIT: HIGH PRESSURE BOILER PLANT TIRUCHIRAPALLI - 620014		DRN & CHD	NAME <i>L. Honey Wood Mary</i>	SIGNATURE <i>[Signature]</i>	DATE 28.02.2011	NO. OF VAR
			APPD	<i>V. Ragu</i>	<i>[Signature]</i>	28.02.2011	
TITLE		DRAWING NO :		REV			
ELECTRIFICATION OF ARTISAN CABIN - (2 NOS).		M&S: PD:11: 026		01			

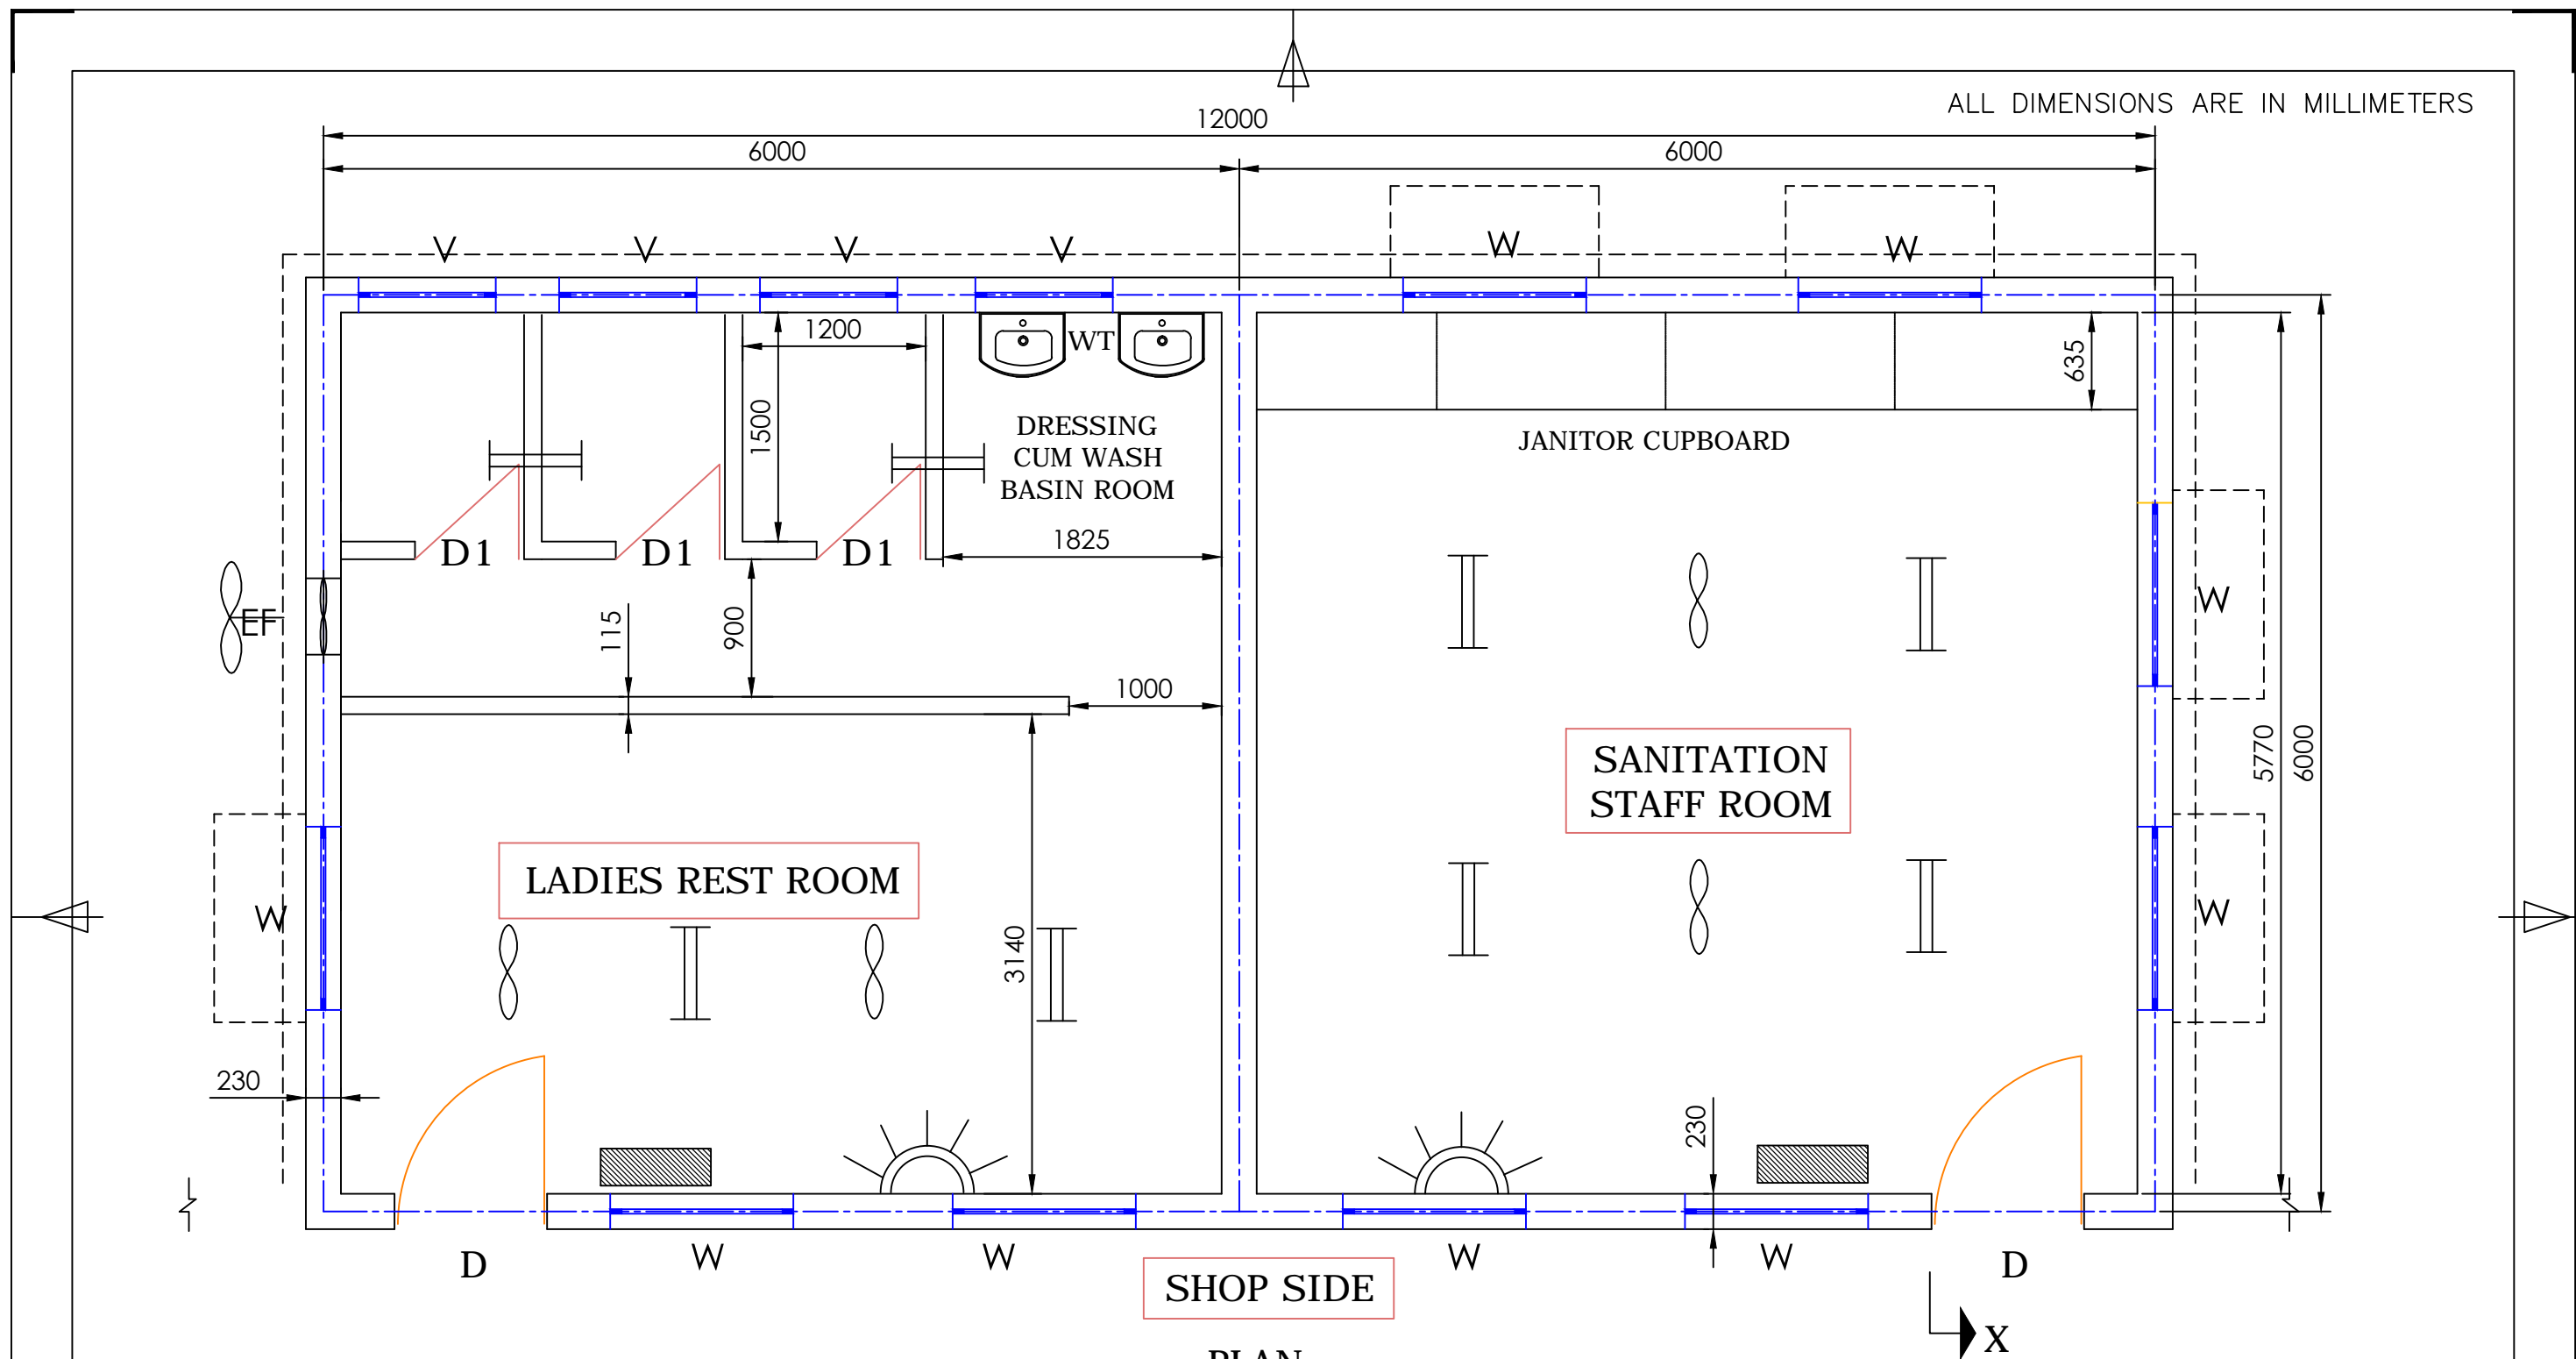

LEGEND:


- | | | |
|--|-----------------------------|-------------------|
| | 5/15A Plug Socket - 2 nos. | <u>DIMENSION:</u> |
| | 2x28W TL5 Fitting-8 nos | Height - 3600mm |
| | Ceiling Fan -4 nos | Width - 6000mm |
| | Exhaust Fan -1 nos | Length - 12000mm |
| | 12W 16A SPM MCB DB - 2 nos. | |

PLAN

CAUTION: The information on this document is the property of BHARAT HEAVY ELECTRICALS LTD. It must not be used directly or indirectly in any way detrimental to the interest of the company.




TYPE OF PRODUCT OR NAME OF CUSTOMER/PROJECT		POWER PLANT PIPING UNIT- THIRUMAYAM					
	Bharat Heavy Electricals Ltd UNIT: HIGH PRESSURE BOILER PLANT TIRUCHIRAPALLI - 620014		DRN & CHD	NAME <i>L. Honey Wood Mary</i>	SIGNATURE <i>[Signature]</i>	DATE 28.02.2011	NO. OF VAR
			APPD	<i>V. Ragu</i>	<i>[Signature]</i>	28.02.2011	
TITLE ELECTRIFICATION OF GA OF LADIES REST ROOM & SANITATION STAFF ROOM			CARD CODE U 01	DRAWING NO : M&S: PD: 11: 027		REV 00	

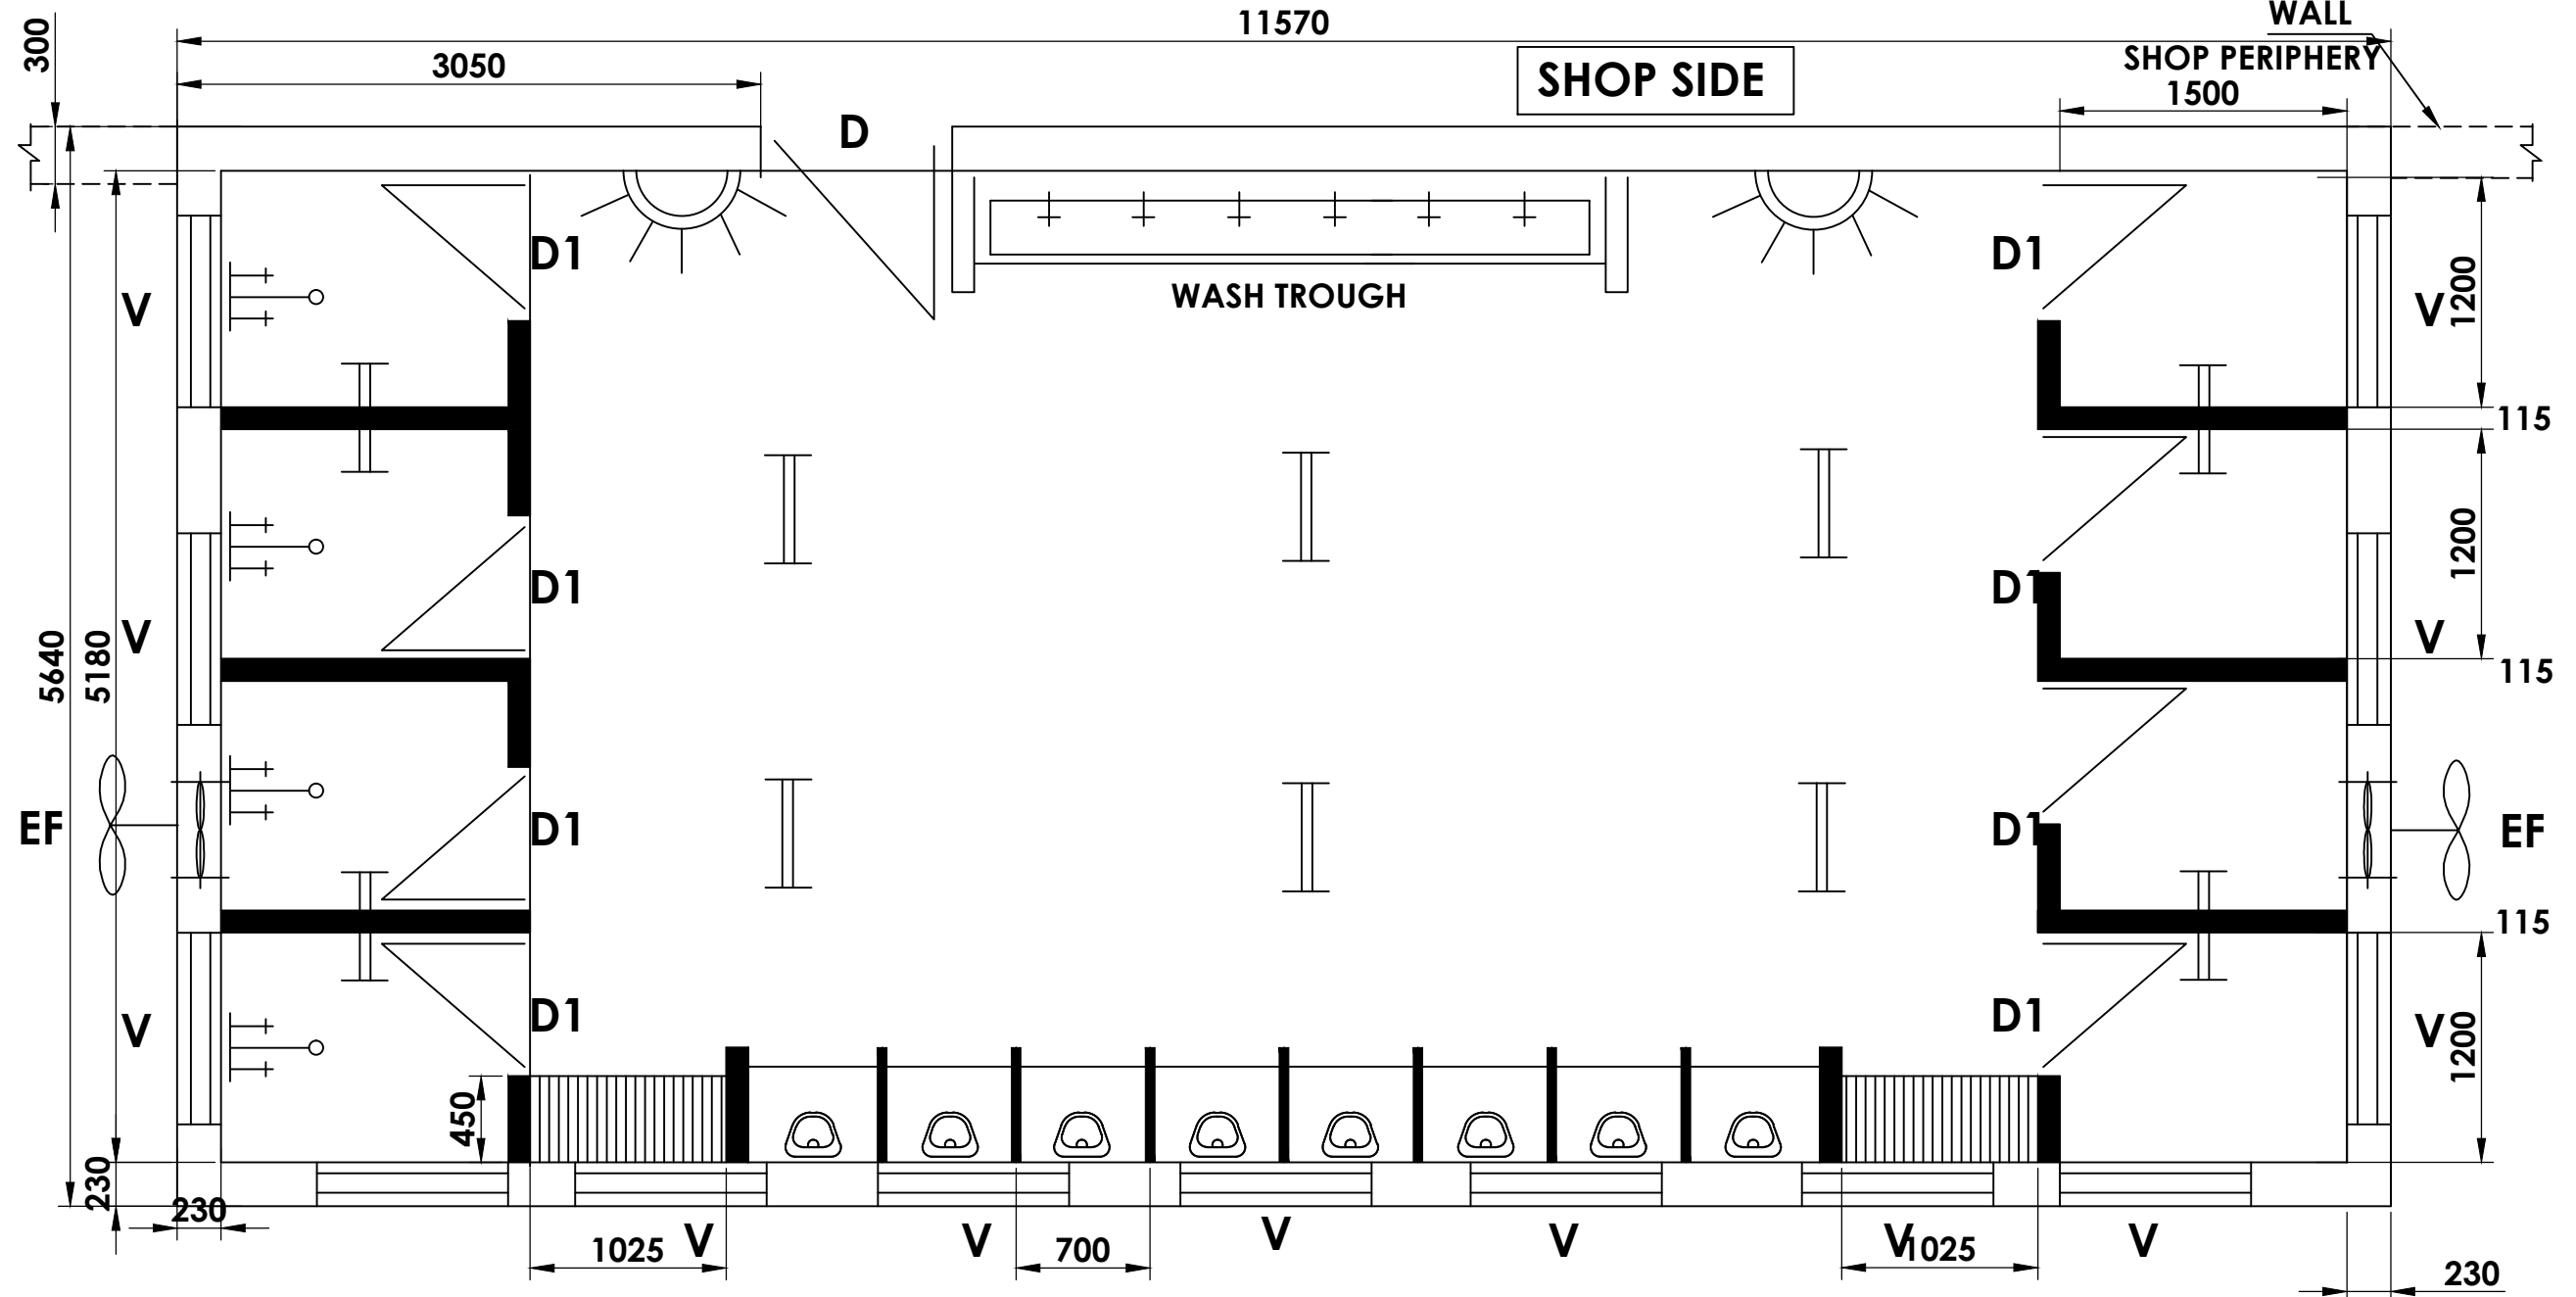ALL DIMENSIONS ARE IN MILLIMETERS



GENERAL ARRANGEMENT
OF TOILET 1 & 2


 
LEGENDS:

-  5/15A Plug Socket - 2 nos
-  Exhaust Fan - 2 nos
-  2 x 28W TL5 Fitting - 10 nos


DIMENSION:

- Height - 3000mm
- Width - 5640mm
- Length - 11570mm

CAUTION: The information on this document is the property of BHARAT HEAVY ELECTRICALS LTD. It must not be used directly or indirectly in any way detrimental to the interest of the company.

TYPE OF PRODUCT OR NAME OF CUSTOMER/PROJECT		POWER PLANT PIPING UNIT- THIRUMAYAM			
	Bharat Heavy Electricals Ltd	DRN & CHD	NAME	SIGNATURE	DATE
	UNIT: HIGH PRESSURE BOILER PLANT TIRUCHIRAPALLI - 620014	APPD	L. Honey Wood Mary		02.03.2011
TITLE		CARD CODE	DRAWING NO :		REV
ELECTRIFICATION OF TOILET 1 & 2		U 01	M&S: PD: 11: 028		00

ALL DIMENSIONS ARE IN MILLIMETERS

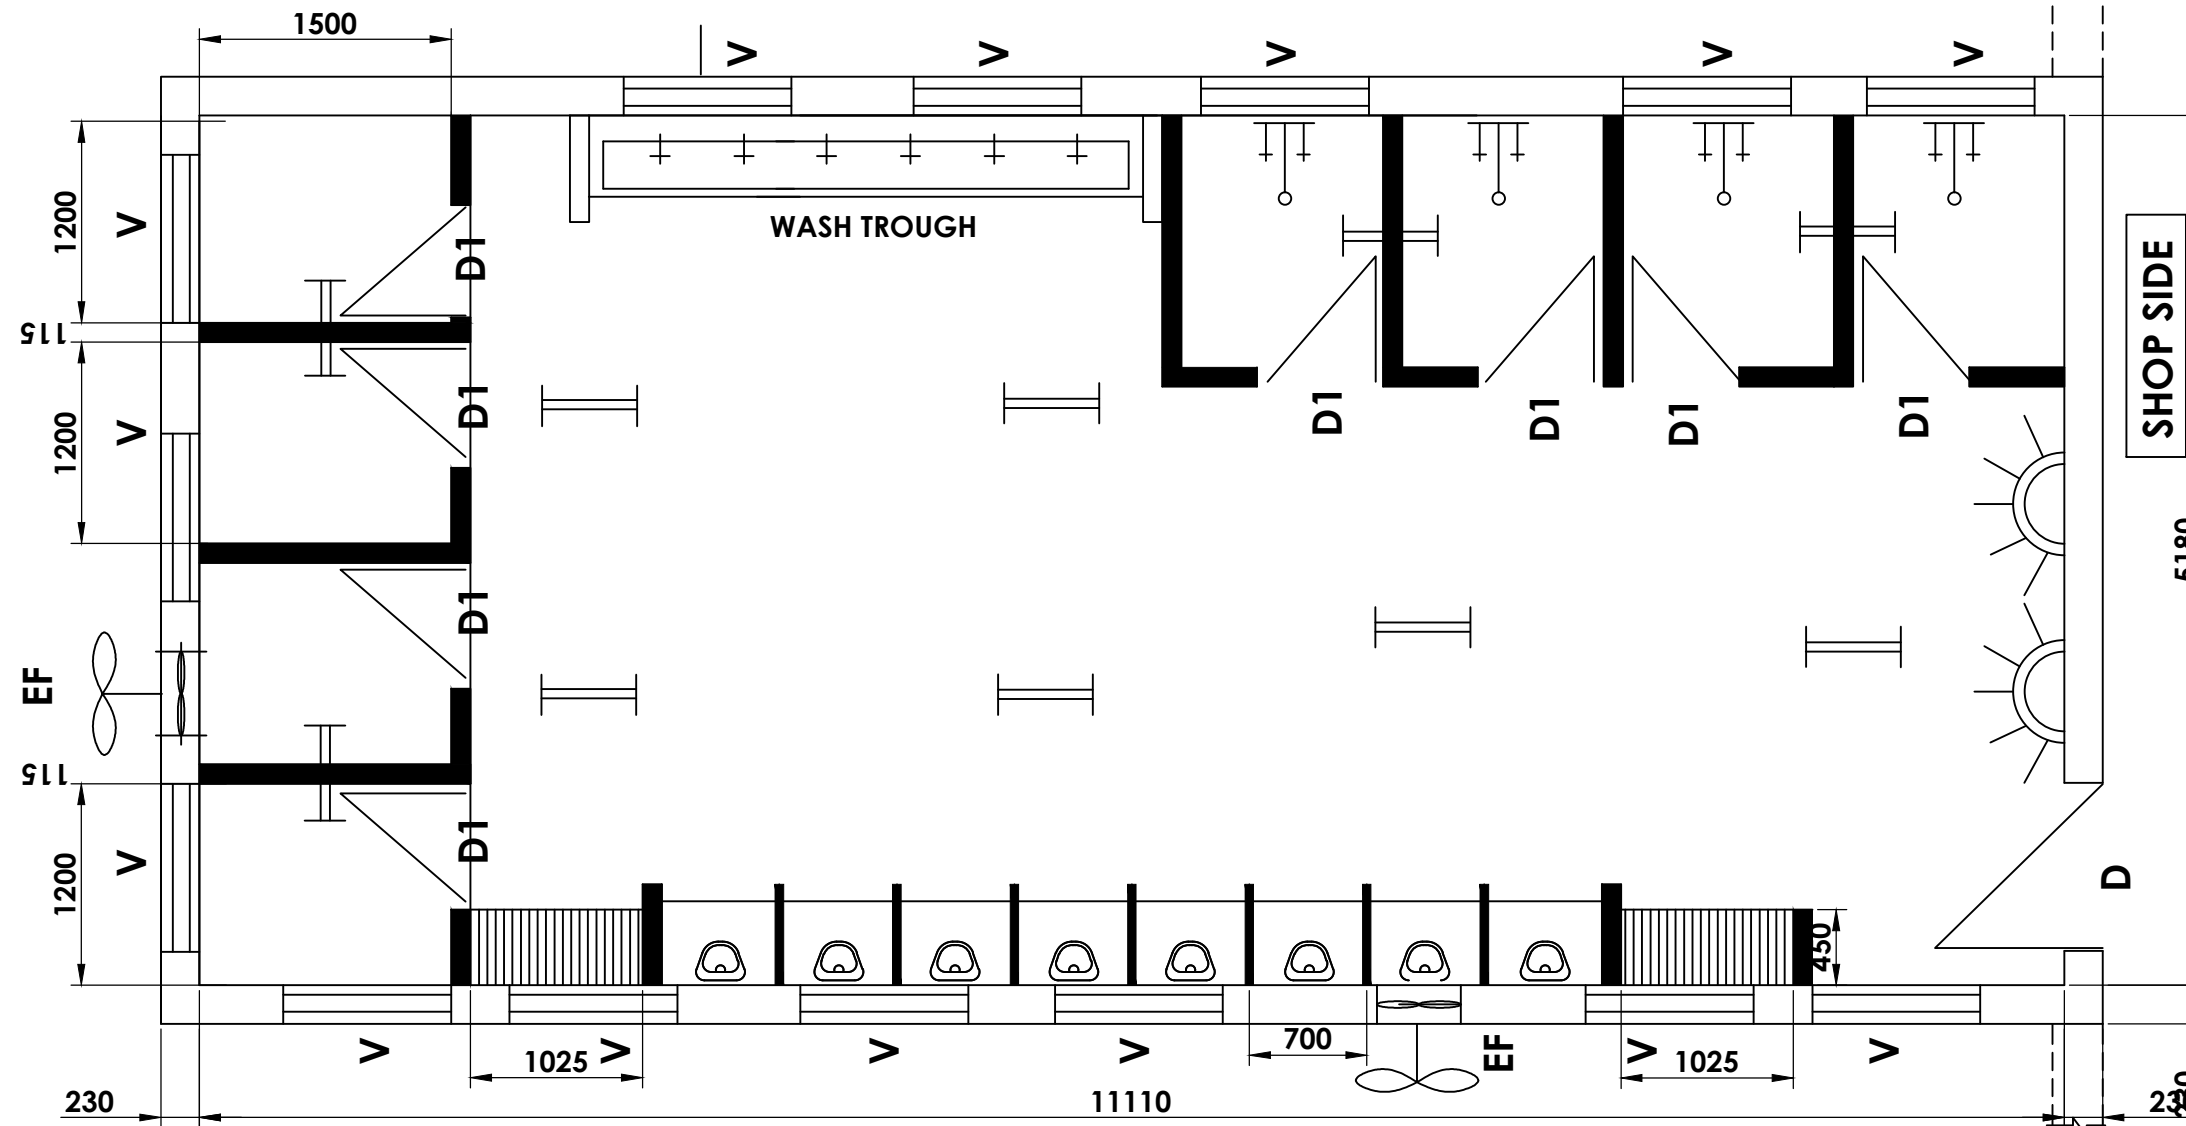

 


GENERAL ARRANGEMENT OF TOILET-3


 
 
DIMENSION:

Height - 3000mm
 Width - 5640mm
 Length - 11570mm

LEGENDS:



 
 


-  5/15A Plug Socket - 2 nos
-  Exhaust Fan - 2 nos
-  2 x 28W TL5 Fitting - 10 nos

CAUTION: The information on this document is the property of BHARAT HEAVY ELECTRICALS LTD. It must not be used directly or indirectly in any way detrimental to the interest of the company.

TYPE OF PRODUCT OR NAME OF CUSTOMER/PROJECT		POWER PLANT PIPING UNIT- THIRUMAYAM					
	Bharat Heavy Electricals Ltd UNIT: HIGH PRESSURE BOILER PLANT TIRUCHIRAPALLI - 620014		DRN & CHD	NAME <i>L. Honey Wood Mary</i>	SIGNATURE 	DATE 03.03.2011	NO. OF VAR
			APPD	<i>V. Ragu</i>		03.03.2011	
TITLE ELECTRIFICATION OF TOILET - 3			CARD CODE U 01	DRAWING NO : M&S: PD: 11: 029			REV 00


ALL DIMENSIONS ARE IN MILLIMETERS

LEGEND:



 
-  5A Plug Socket – 4 nos.
-  5/15A Plug Socket – 4 nos.
-  1x28W TL5 Fitting–16 nos
-  Ceiling Fan –4 nos
-  Exhaust Fan –2 nos
-  12W 16A SPN MCB DB – 2 nos.

DIMENSION:

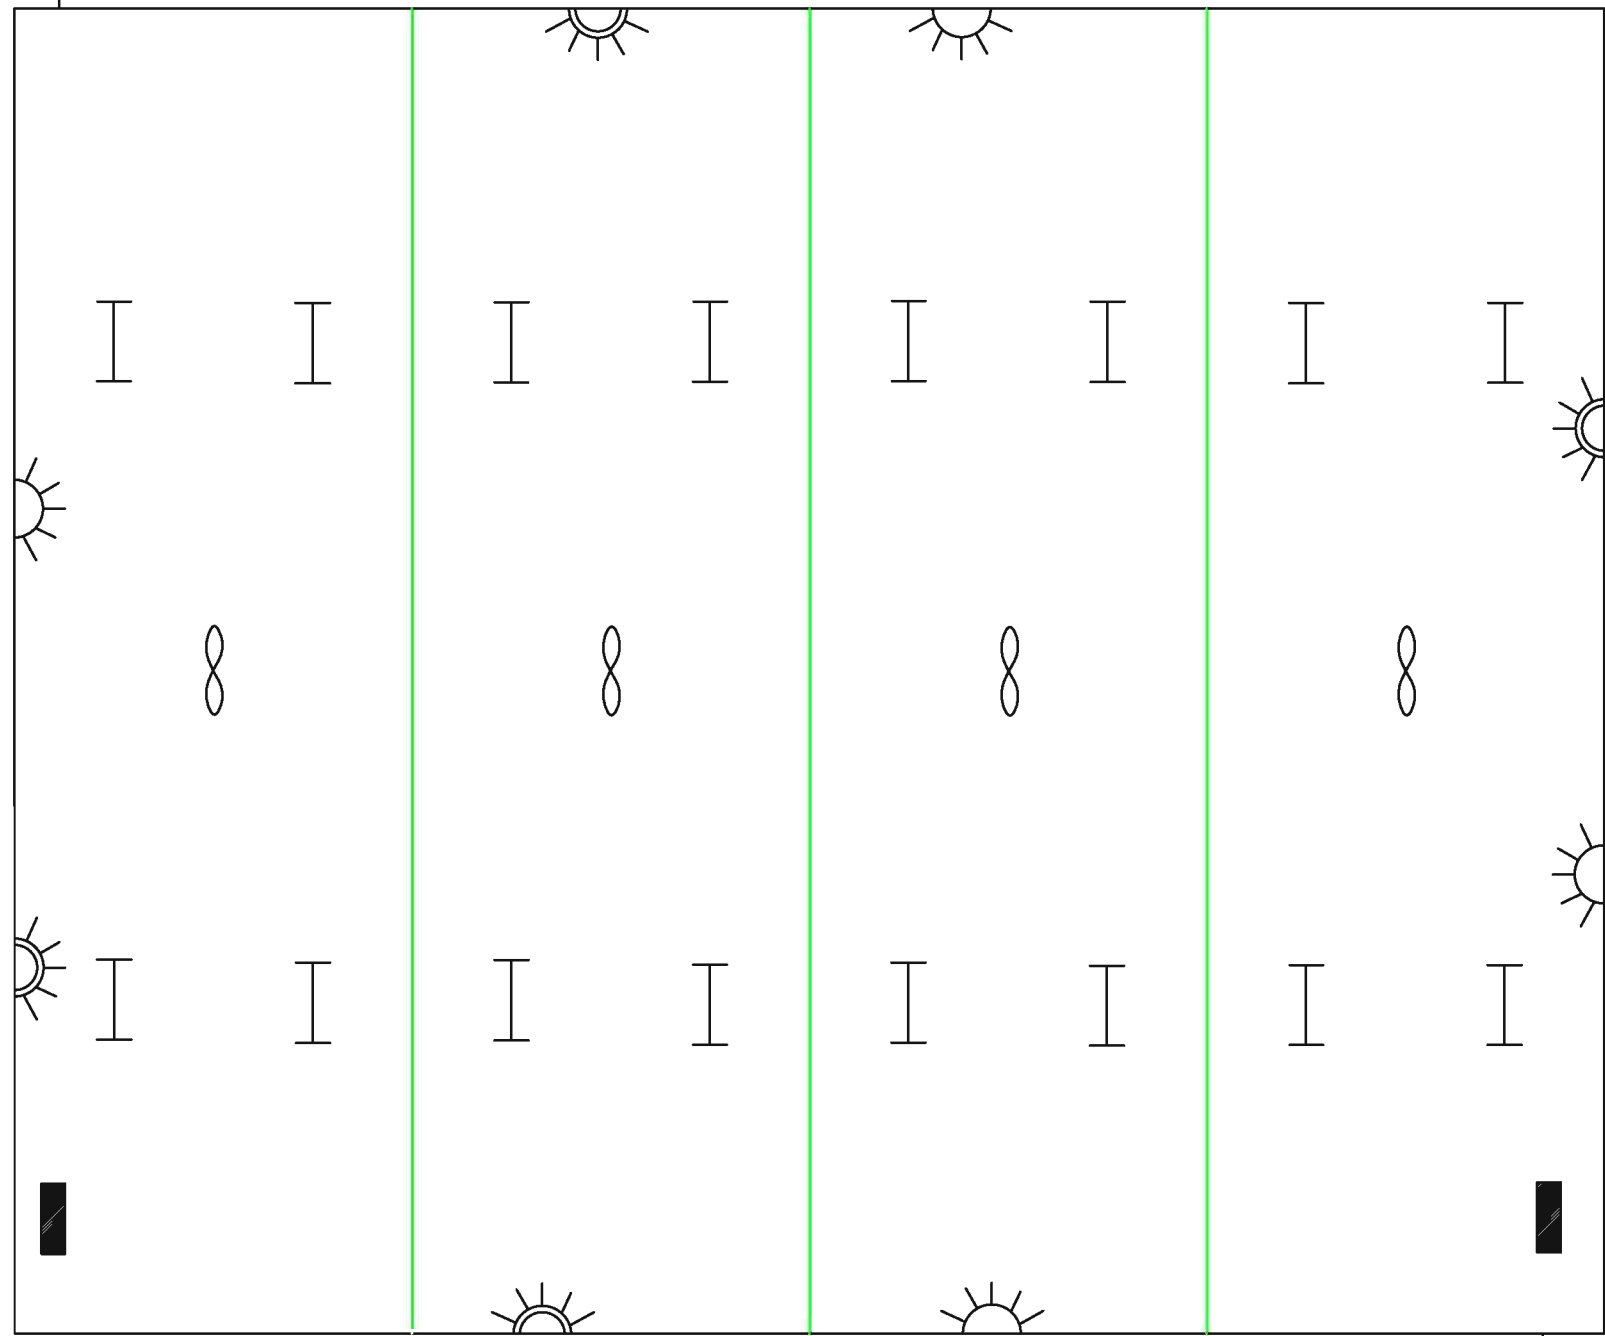Height - 3600mm
 Width - 10000mm
 Length - 12000mm


 
 





TOOL CRIB

CAUTION: The information on this document is the property of BHARAT HEAVY ELECTRICALS LTD. It must not be used directly or indirectly in any way detrimental to the interest of the company.	TYPE OF PRODUCT OR NAME OF CUSTOMER/PROJECT		POWER PLANT PIPING UNIT- THIRUMAYAM					
		Bharat Heavy Electricals Ltd UNIT: HIGH PRESSURE BOILER PLANT TIRUCHIRAPALLI - 620014		DRN & CHD	NAME <i>L. Honey Wood Mary</i>	SIGNATURE 	DATE 28.02.2011	NO. OF VAR
		APPD	<i>V. Ragu</i>		SIGNATURE 	DATE 28.02.2011		
TITLE ELECTRIFICATION OF TOOL CRIB			CARD CODE U 01	DRAWING NO : M&S: PD: 11: 030			REV 00	


ALL DIMENSIONS ARE IN MILLIMETERS

LEGEND:


 
 
-  5A Plug Socket - 4 nos.
-  5/15A Plug Socket - 4 nos.
-  1x28W TL5 Fitting-16 nos
-  Ceiling Fan -4 nos
-  Exhaust Fan -2 nos
-  12W 16A SPN MCB DB - 2 nos.

DIMENSION:

Height - 3600mm
 Width - 10000mm
 Length - 12000mm

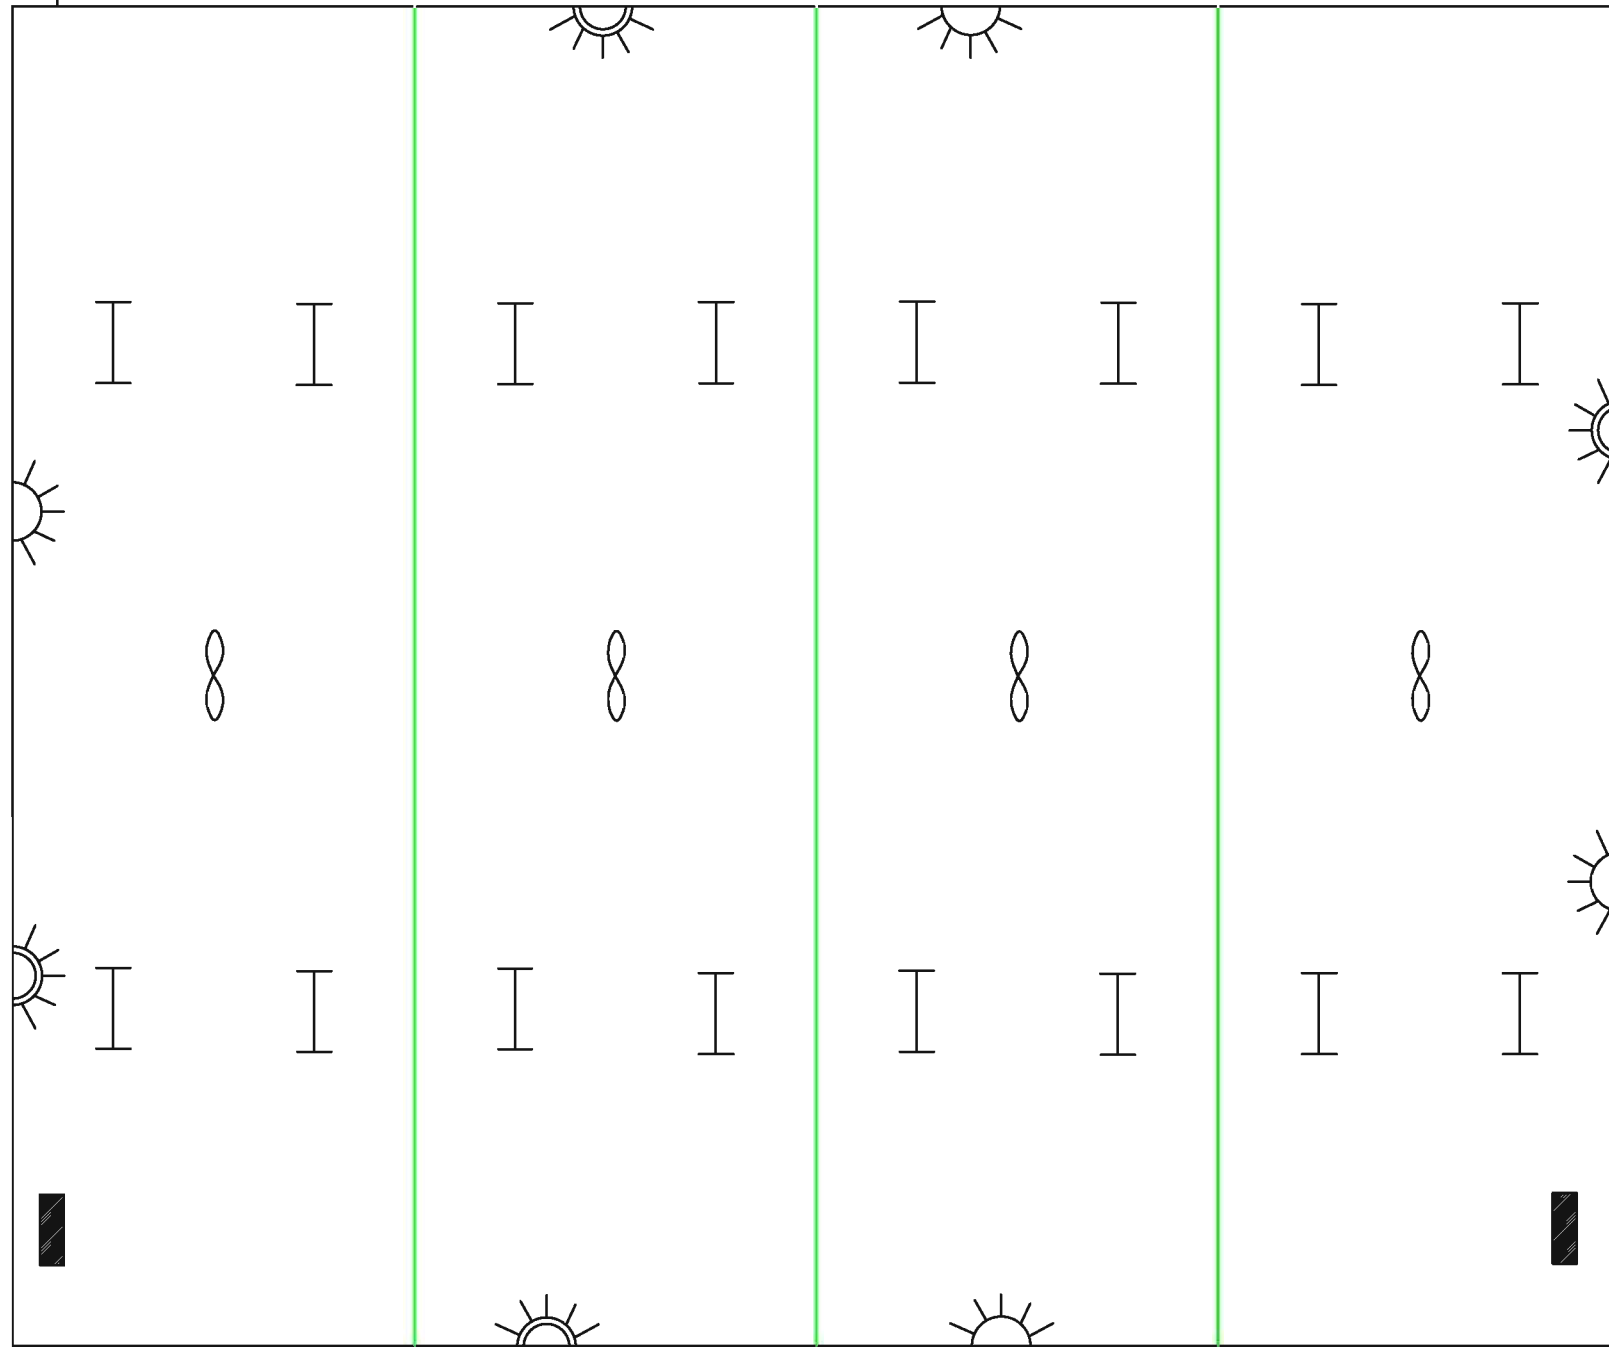


 



 



INTERMEDIATE STORES

CAUTION: The information on this document is the property of BHARAT HEAVY ELECTRICALS LTD. It must not be used directly or indirectly in any way detrimental to the interest of the company.	TYPE OF PRODUCT OR NAME OF CUSTOMER/PROJECT		POWER PLANT PIPING UNIT- THIRUMAYAM					
		Bharat Heavy Electricals Ltd UNIT: HIGH PRESSURE BOILER PLANT TIRUCHIRAPALLI - 620014		DRN & CHD	NAME <i>L. Honey Wood Mary</i>	SIGNATURE 	DATE 28.02.2011	NO. OF VAR
		APPD			APPD	NAME <i>V. Ragu</i>	SIGNATURE 	
TITLE ELECTRIFICATION OF INTERMEDIATE STORES			CARD CODE U 01	DRAWING NO : M&S: PD: 11: 031			REV 00	


ALL DIMENSIONS ARE IN MILLIMETERS

LEGEND:



-  5A Plug Socket - 2 nos.
-  5/15A Plug Socket - 4 nos.
-  1x28W TL5 Fitting-16 nos
-  Ceiling Fan -3 nos
-  Exhaust Fan -2 nos
-  12W 16A SPN MCB DB - 2 nos.
-  32A AC BOX - 1 no.
-  63A TPN Isolator- 6 nos.
-  8W 63A MCB DB - 1 no.

DIMENSION:

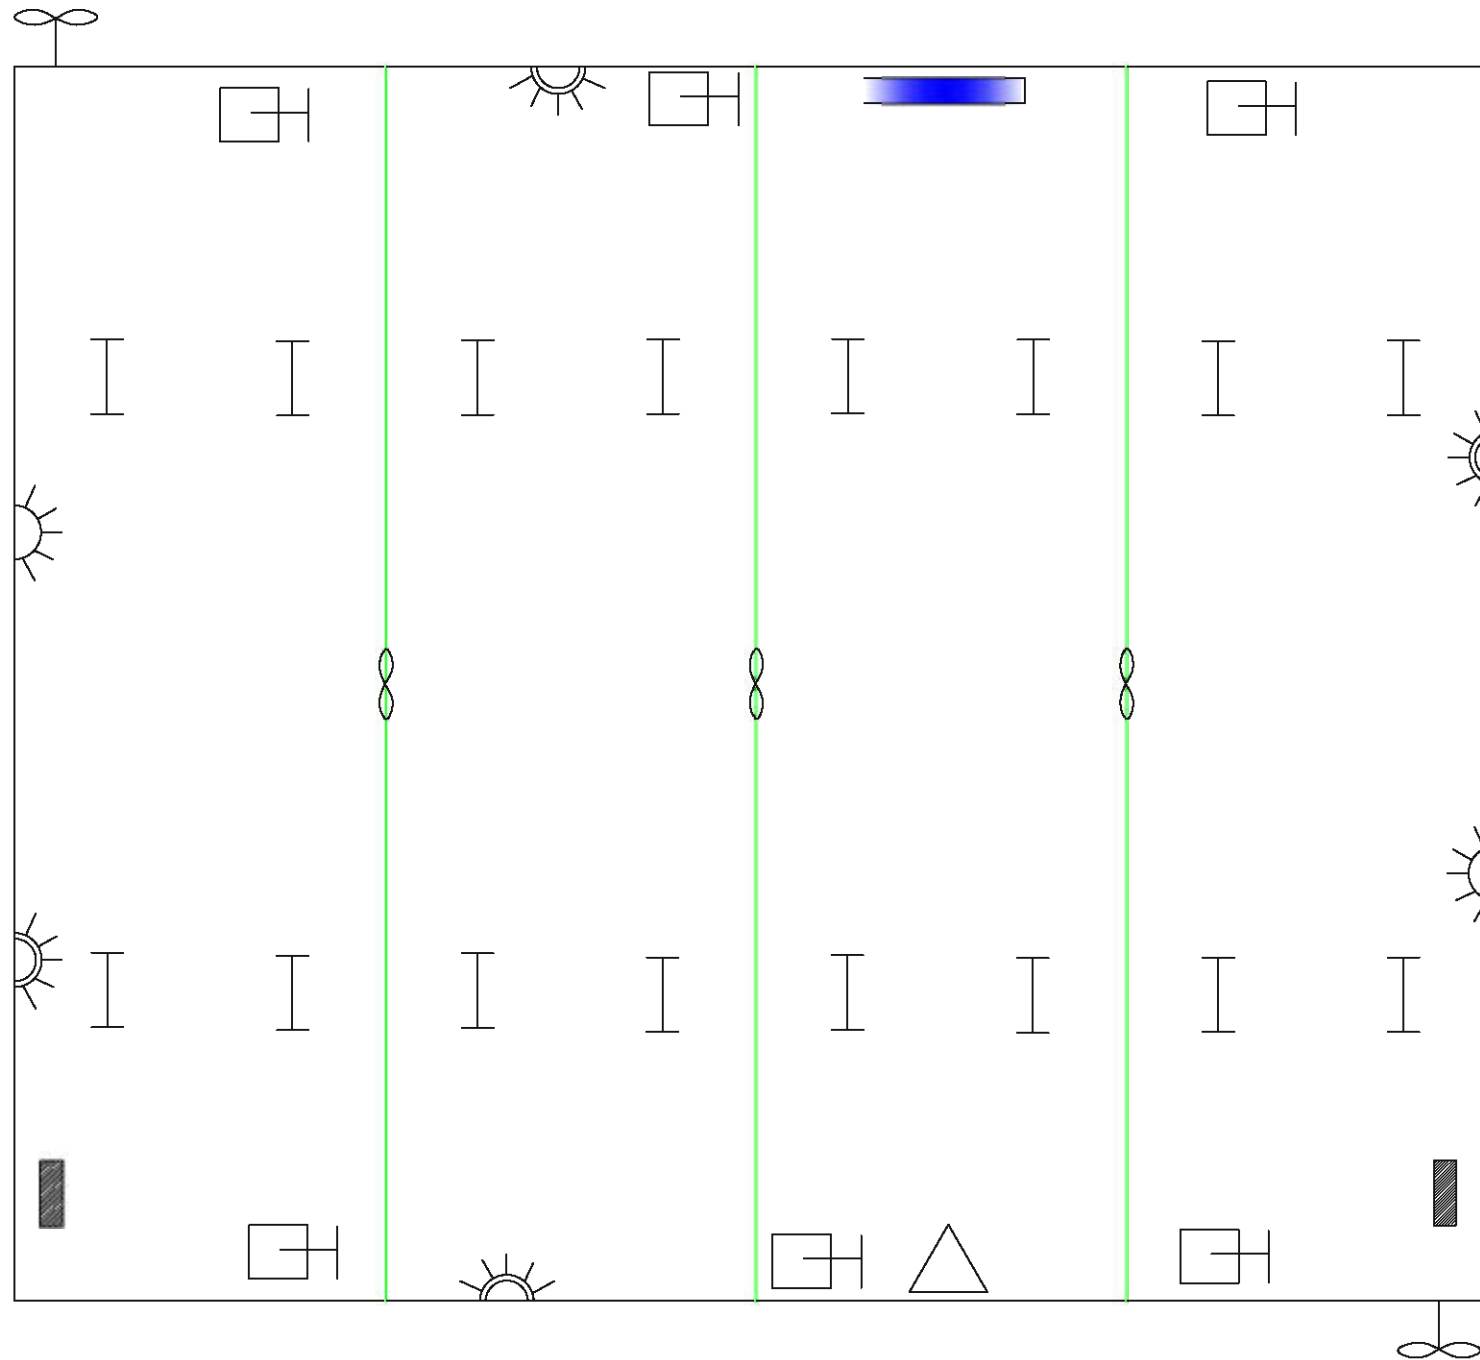
Height - 3600mm
 Width - 10000mm
 Length - 12000mm



WTC ELECTRODE / OVEN ROOM

CAUTION: The information on this document is the property of BHARAT HEAVY ELECTRICALS LTD. It must not be used directly or indirectly in any way detrimental to the interest of the company.	TYPE OF PRODUCT OR NAME OF CUSTOMER/PROJECT POWER PLANT PIPING UNIT- THIRUMAYAM					
	 Bharat Heavy Electricals Ltd UNIT: HIGH PRESSURE BOILER PLANT TIRUCHIRAPALLI - 620014	DRN & CHD	NAME <i>L. Honey Wood Mary</i>	SIGNATURE 	DATE 28.02.2011	NO. OF VAR
		APPD	<i>V. Ragu</i>	<i>Y.L.</i>	28.02.2011	
TITLE ELECTRIFICATION OF WTC ELECTRODE / OVEN ROOM		CARD CODE U 01	DRAWING NO : M&S: PD: 11: 032		REV 00	

ALL DIMENSIONS ARE IN MILLIMETERS

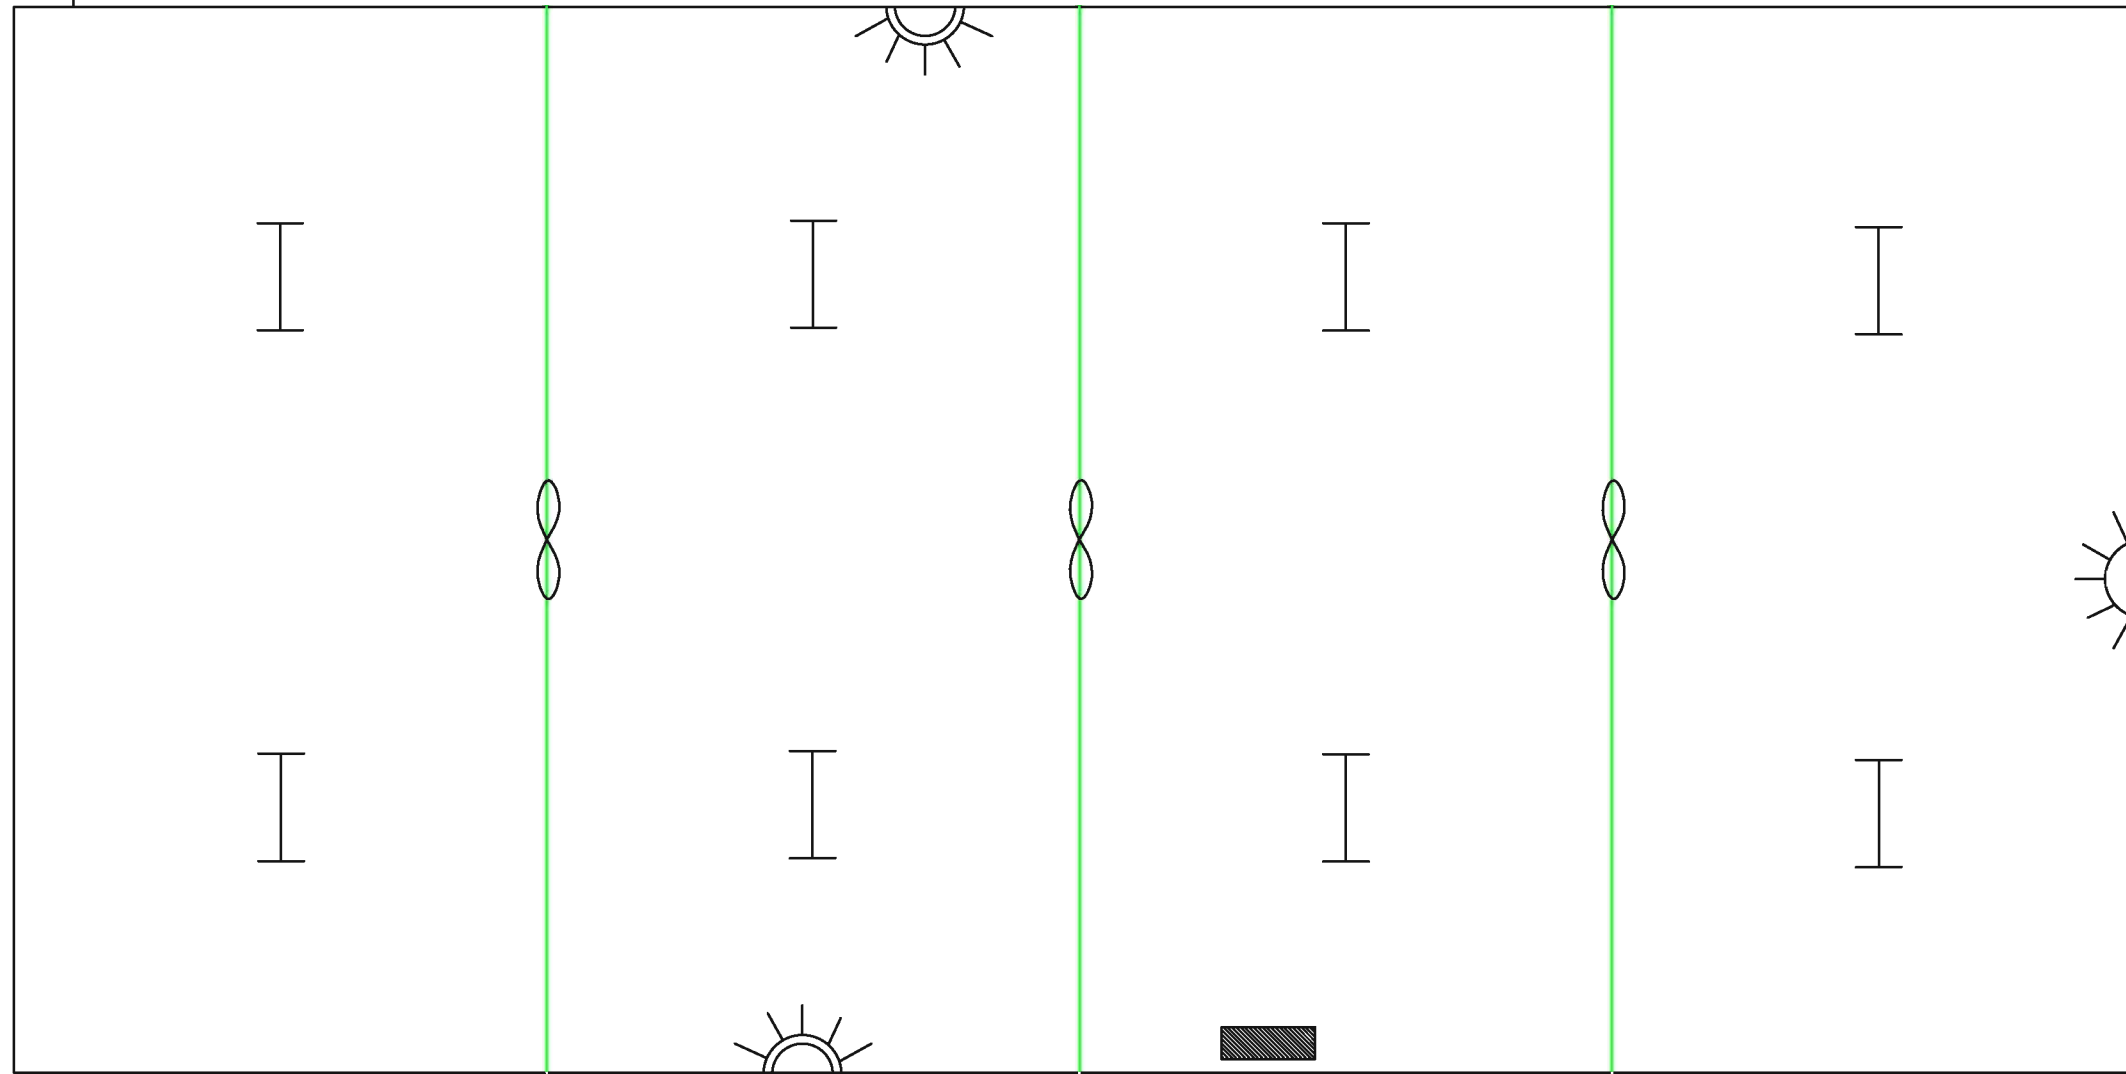

DIMENSION:

 

 
 


Height - 3600mm

Width - 6000mm


 
 
Length - 12000mm

LEGEND:


Accessories room

-  5A Plug Socket - 1 no.
-  5/15A Plug Socket - 2 nos.
-  1x28W TL5 Fitting-8 nos
-  Ceiling Fan -3 nos
-  Exhaust Fan -1 no
-  12W 16A SPN MCB DB - 1 no.


CAUTION: The information on this document is the property of BHARAT HEAVY ELECTRICALS LTD. It must not be used directly or indirectly in any way detrimental to the interest of the company.

TYPE OF PRODUCT OR NAME OF CUSTOMER/PROJECT		POWER PLANT PIPING UNIT- THIRUMAYAM					
	Bharat Heavy Electricals Ltd UNIT: HIGH PRESSURE BOILER PLANT TIRUCHIRAPALLI - 620014		DRN & CHD	NAME <i>L. Honey Wood Mary</i>	SIGNATURE 	DATE 28.02.2011	NO. OF VAR
			APPD	<i>U. Ragu</i>		28.02.2011	
TITLE		ELECTRIFICATION OF ACCESSORIES ROOM		CARD CODE	DRAWING NO : M&S: PD: 11: 033		REV
				U 01			00

ALL DIMENSIONS ARE IN MILLIMETERS

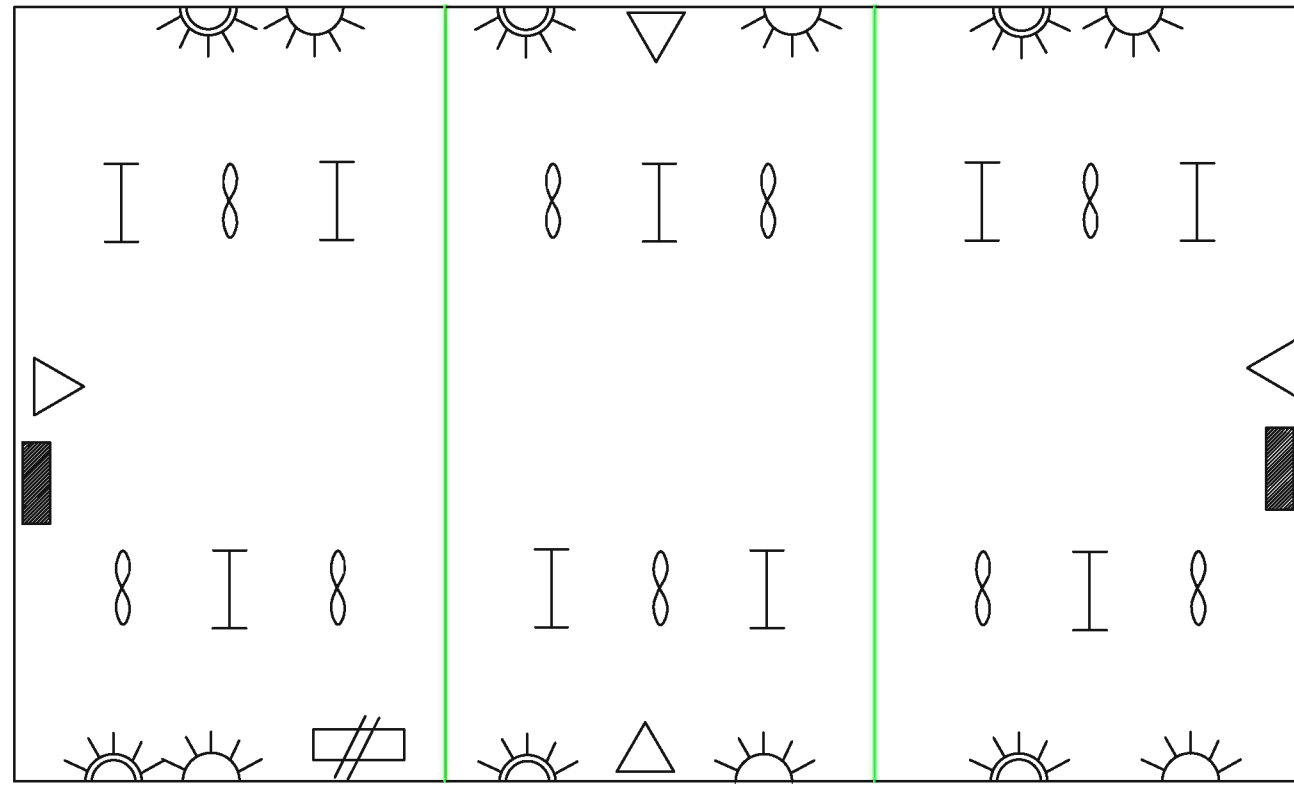
 
 

 

 


NDT OFFICE - GROUND FLOOR

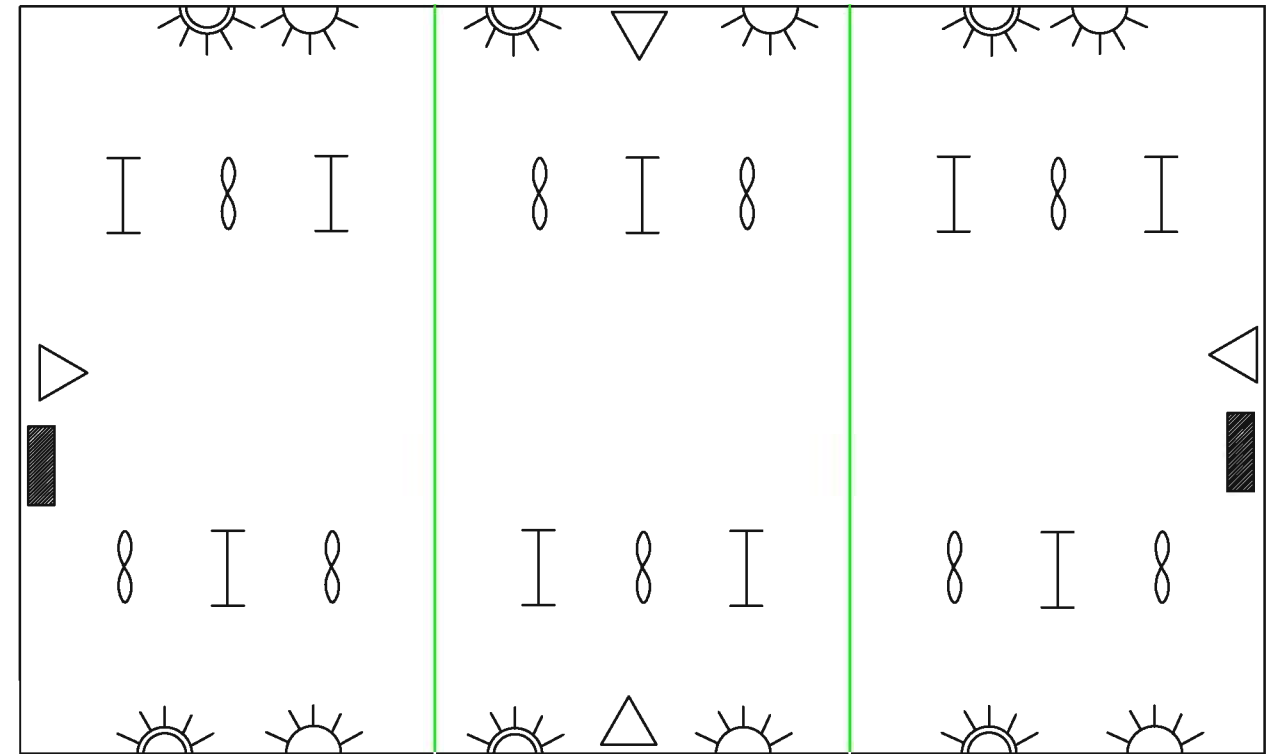



 
NDT OFFICE - FIRST FLOOR

LEGEND:


-  5A Plug Socket - 12 nos.
-  5/15A Plug Socket - 12 nos.
-  1x28W TL5 Fitting-18 nos
-  Ceiling Fan -18 nos
-  32A AC BOX - 8 nos.
-  12W 16A SPN MCB DB - 4 nos.
-  8W 32A 4Seg MCB DB - 1 no.

DIMENSION:

- Height - 4000mm (1st floor)
- Height - 4000mm (Gnd floor)
- Width - 6000mm
- Length - 10000mm

 

 


 
 
CAUTION: The information on this document is the property of BHARAT HEAVY ELECTRICALS LTD. It must not be used directly or indirectly in any way detrimental to the interest of the company.	TYPE OF PRODUCT OR NAME OF CUSTOMER/PROJECT		POWER PLANT PIPING UNIT- THIRUMAYAM					
		Bharat Heavy Electricals Ltd UNIT: HIGH PRESSURE BOILER PLANT TIRUCHIRAPALLI - 620014		DRN & CHD	NAME <i>L. Honey Wood Mary</i>	SIGNATURE 	DATE 28.02.2011	NO. OF VAR
		APPD	<i>V. Ragu</i>			28.02.2011		
TITLE ELECTRIFICATION OF NDT OFFICE			CARD CODE U 01	DRAWING NO : M&S: PD: 11: 034			REV 01	

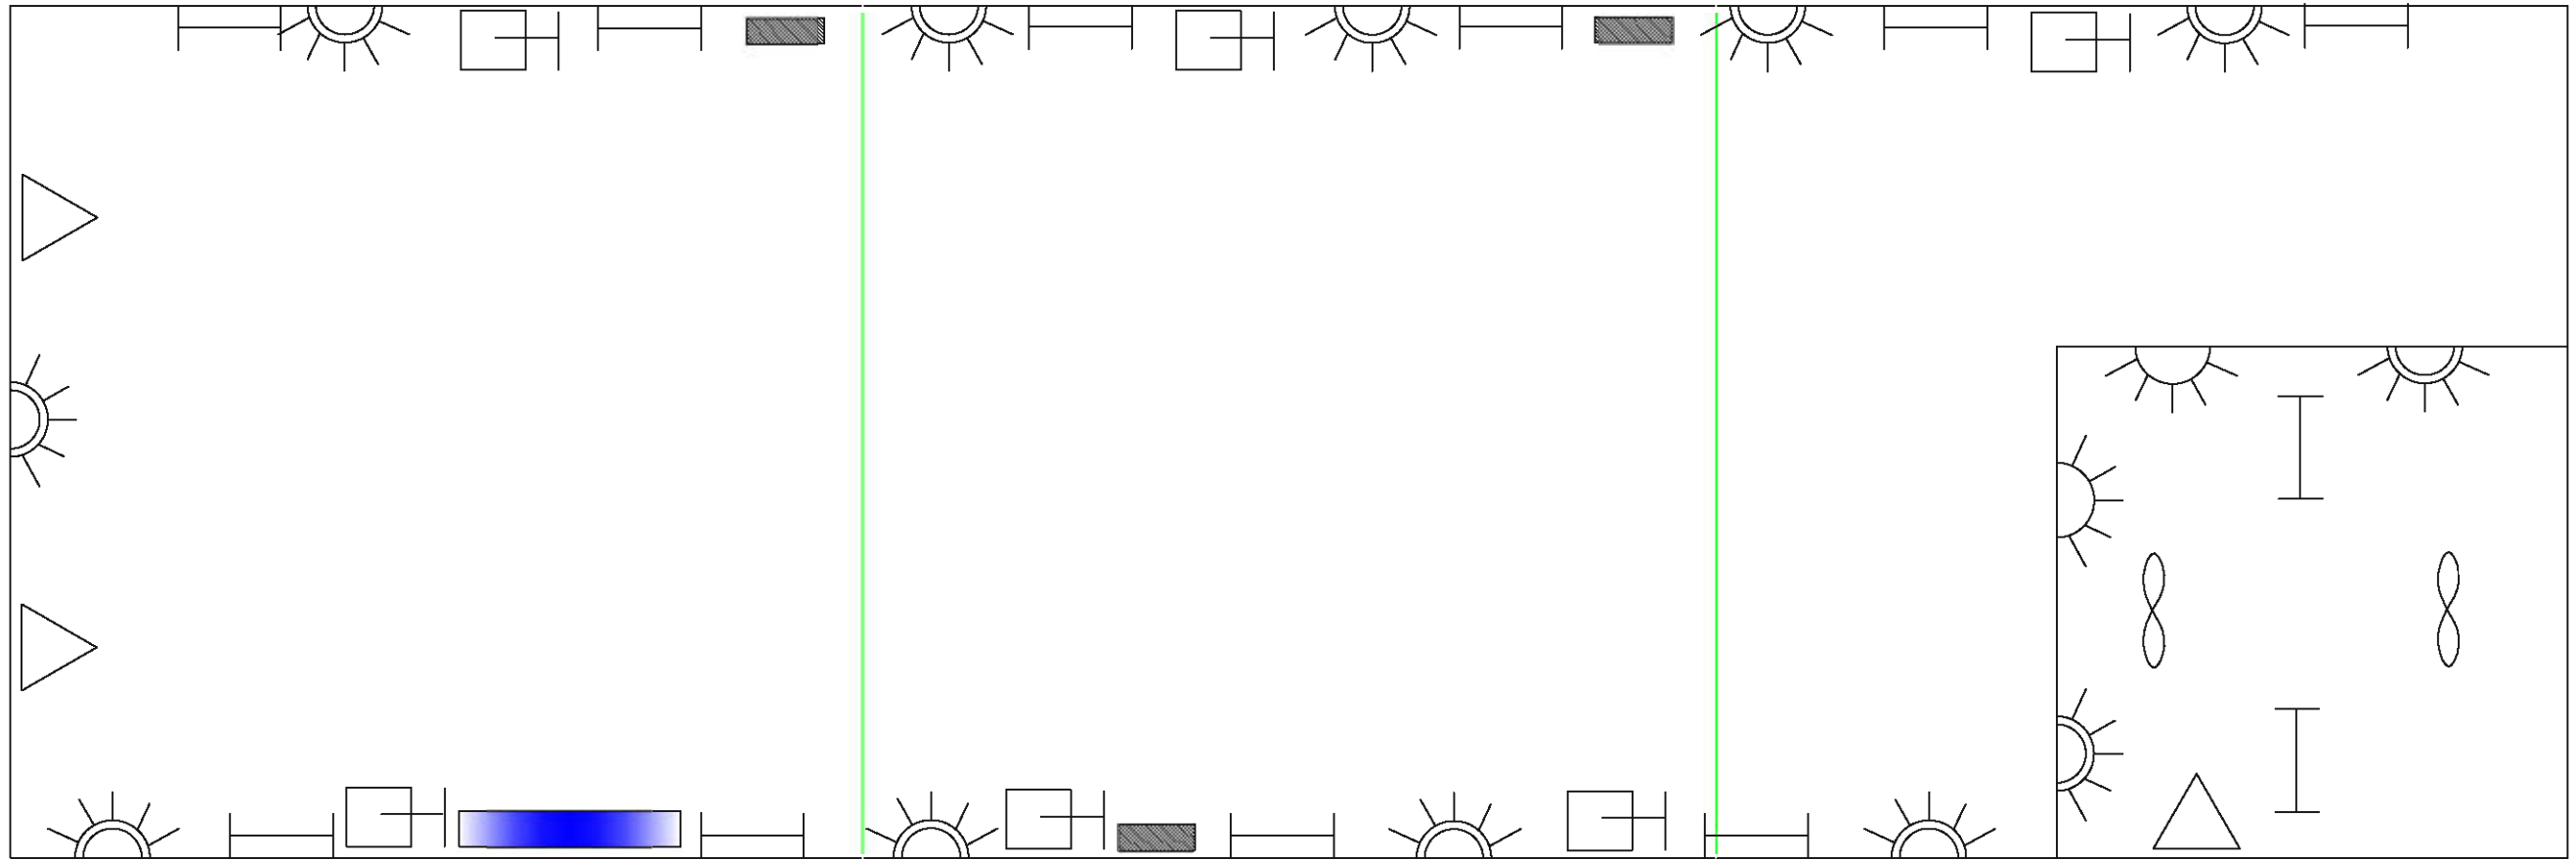ALL DIMENSIONS ARE IN MILLIMETERS





 
RTR X - RAY HALL & CONTROL ROOM

LEGEND:

-  5A Plug Socket - 12 nos.
-  5/15A Plug Socket - 2 nos.
-  1x28W TL5 Fitting-12 nos
-  12W 16A SPN MCB DB - 6 nos.
-  32A AC BOX - 3 no.
-  63A TPN Isolator- 6 nos.
-  8W 63A MCB DB - 1 no.

DIMENSION:

- Height - 4000mm
- Width - 5000mm
- Length - 15000mm

CAUTION: The information on this document is the property of BHARAT HEAVY ELECTRICALS LTD. It must not be used directly or indirectly in any way detrimental to the interest of the company.	TYPE OF PRODUCT OR NAME OF CUSTOMER/PROJECT POWER PLANT PIPING UNIT- THIRUMAYAM					
	 Bharat Heavy Electricals Ltd UNIT: HIGH PRESSURE BOILER PLANT TIRUCHIRAPALLI - 620014	DRN & CHD L. Honey Wood Mary	SIGNATURE 	DATE 28.02.2011	NO. OF VAR	
		APPD V. Ragu	SIGNATURE 	DATE 28.02.2011		
TITLE ELECTRIFICATION OF RTR X - RAY HALL & CONTROL ROOM		CARD CODE U 01	DRAWING NO : M&S: PD: 11: 035		REV 00	