
 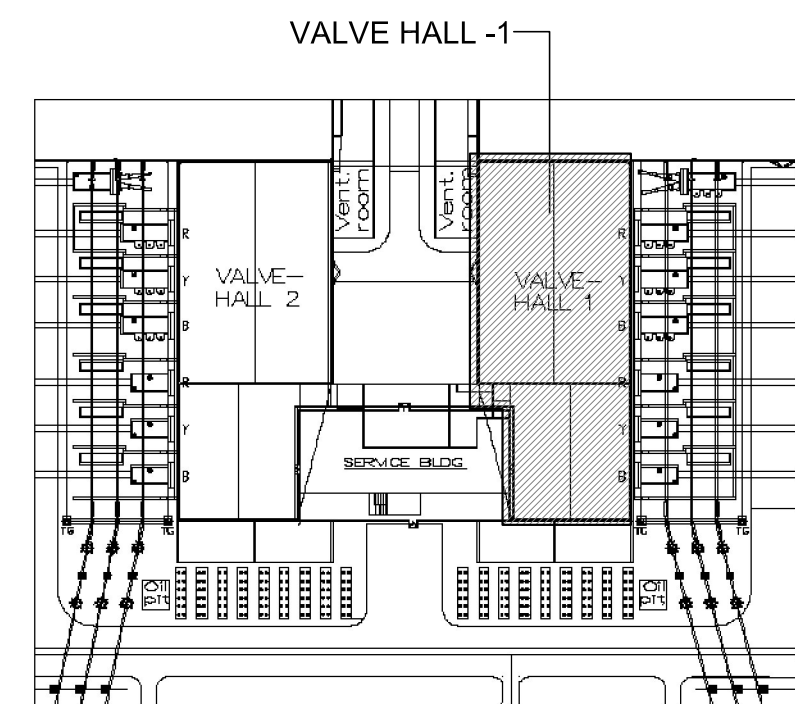


PART PLAN AT EL(+18.100M LVL)
(SCALE 1:150)
(DETAILS TO BE FINALIZED)




KEY PLAN

LEGEND:


| | | | |
|-----|-------------------------|------|--------------------------|
| EL | - ELEVATION | TOP | - TOP OF PARAPET |
| FGL | - FINISHED GROUND LEVEL | RWDP | - RAIN WATER DOWN PIPE |
| FFL | - FINISHED FLOOR LEVEL | TOC | - TOP OF CONCRETE |
| TYP | - TYPICAL | MKD | - MARKED |
| THK | - THICKNESS | UNO | - UNLESS NOTED OTHERWISE |
| TOG | - TOP OF GRATING | | |

FOR REFERENCE DRAWINGS & NOTES
REFER DRAWING NO:5517-3-53-100

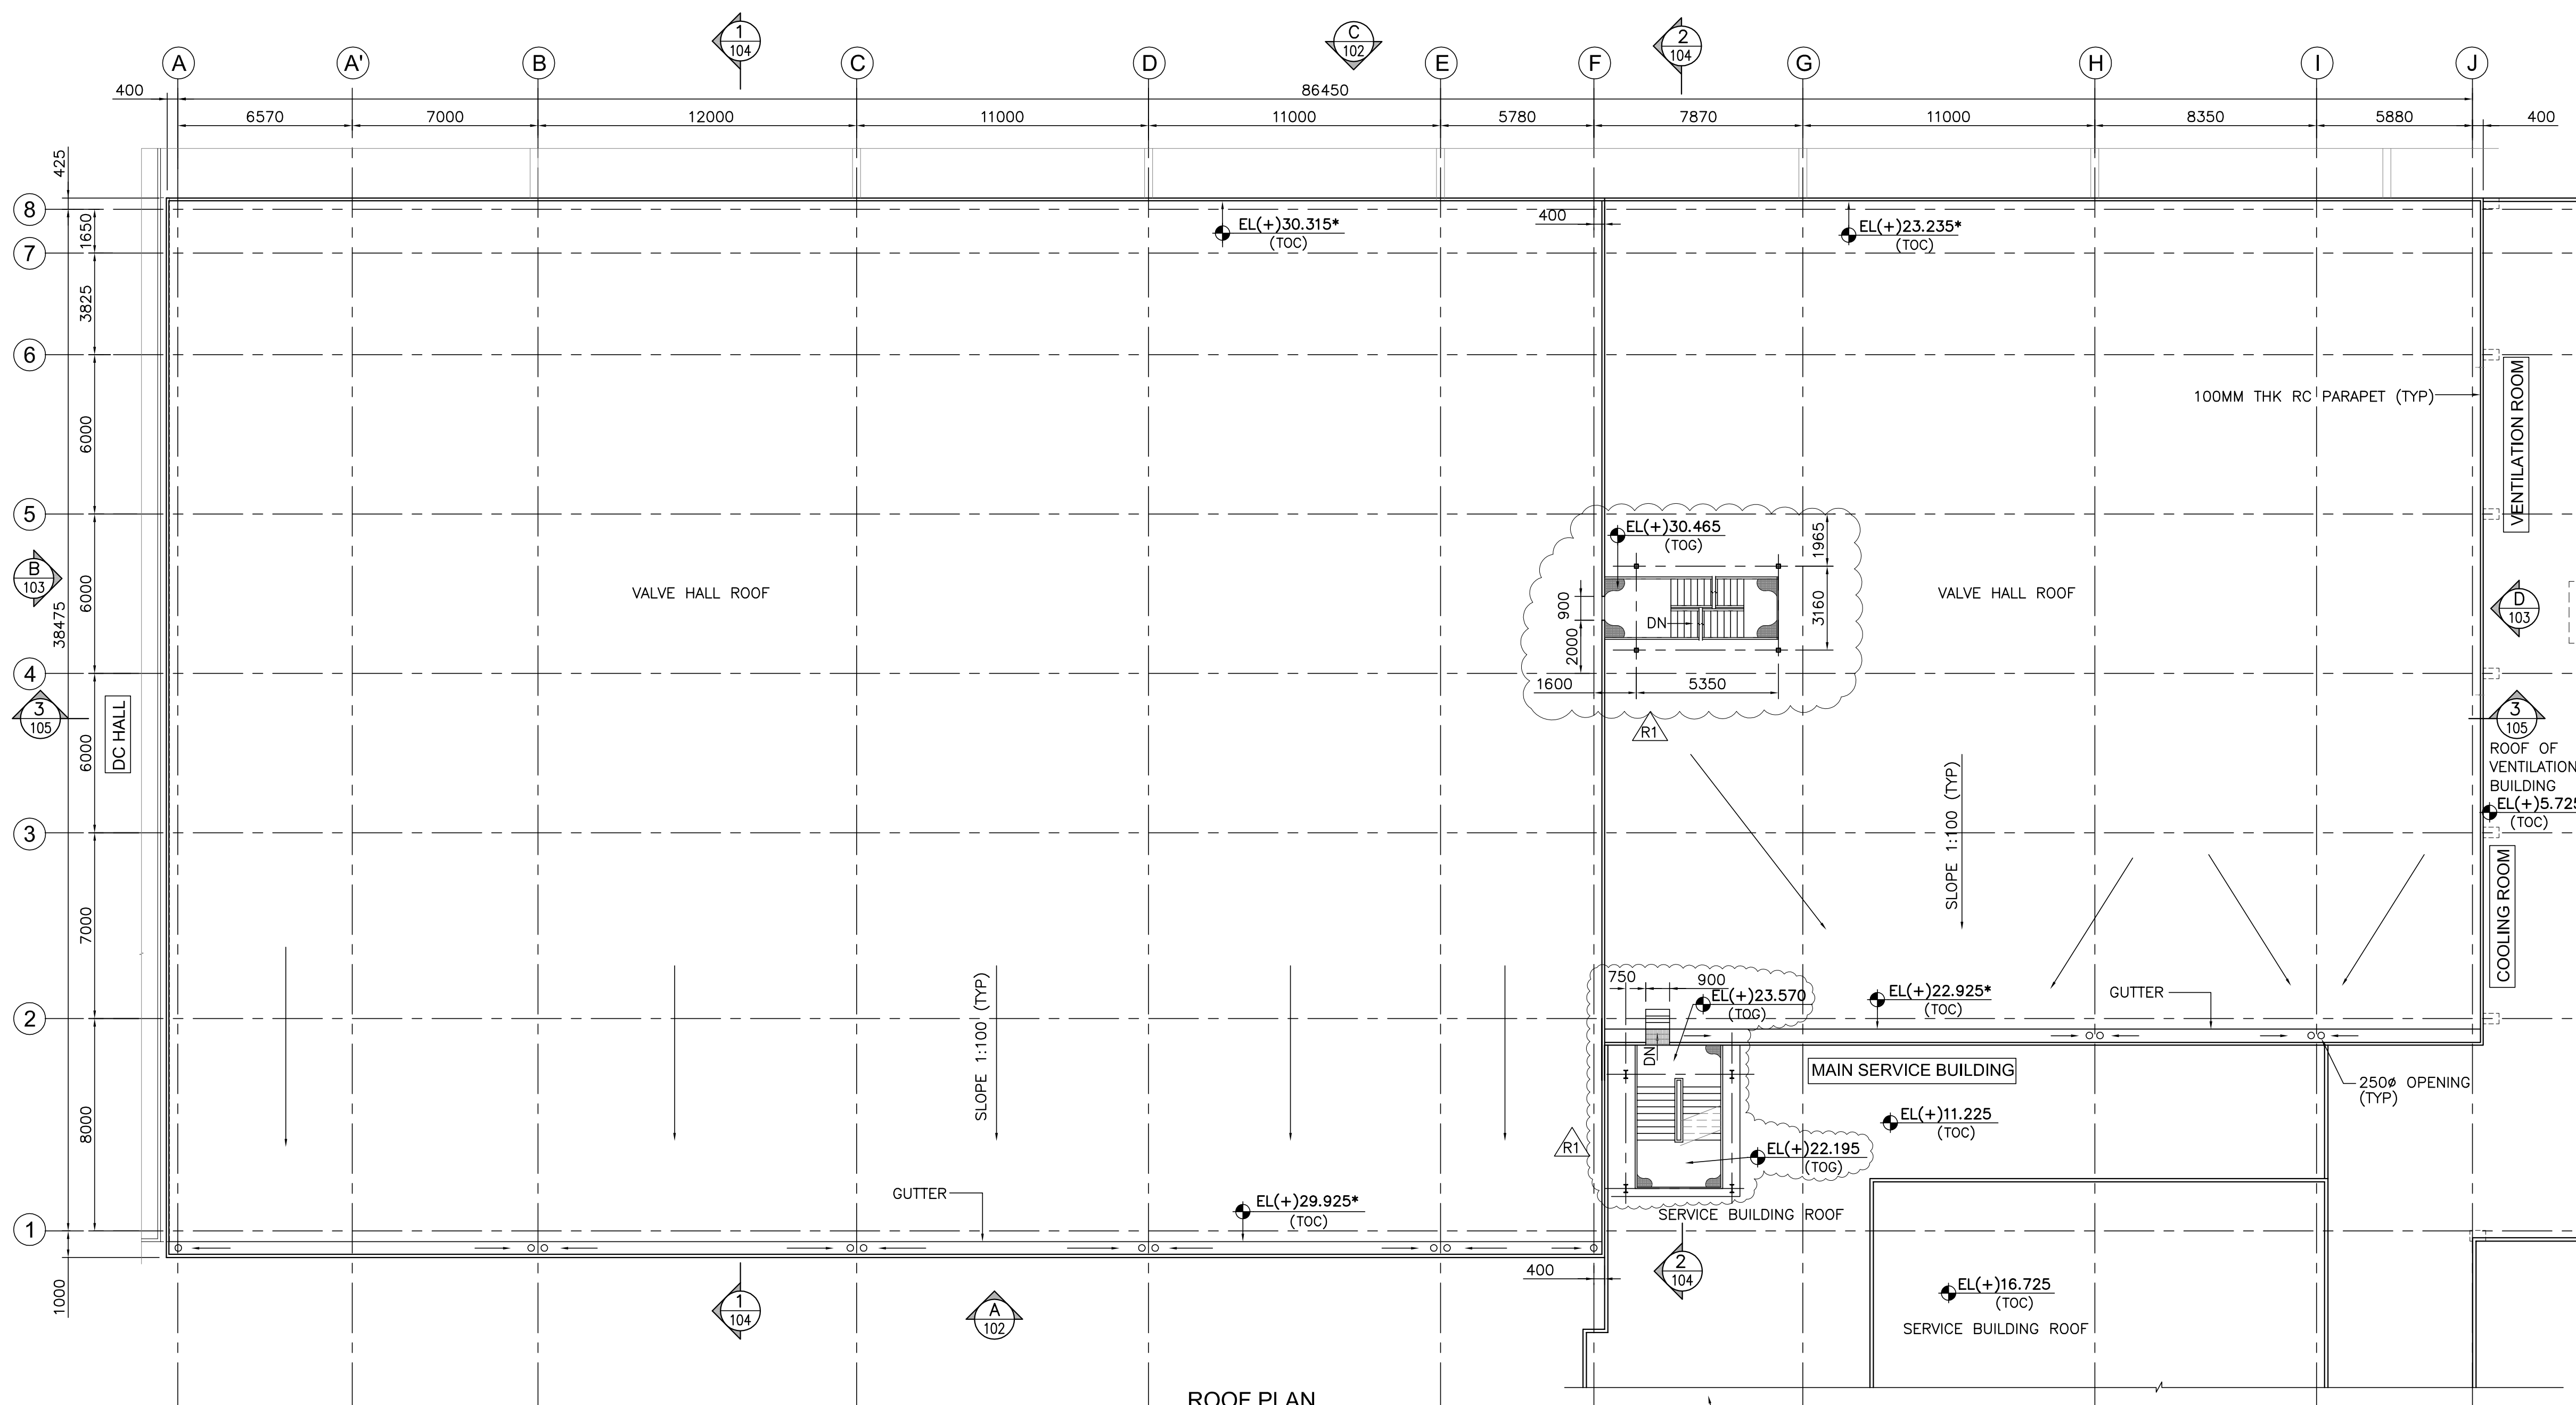

ROOF PLAN

(SCALE 1:150)
(TRANSFORMER WALLS NOT SHOWN FOR CLARITY)
(* ELEVATIONS MKD THUS TO SUIT STRUCTURAL STEEL FRAMING)

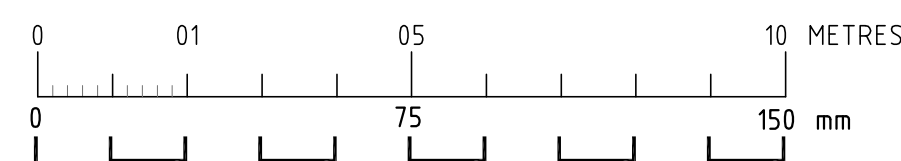

THIS MEASUREMENT IS 100 mm ON ORIGINAL DRAWING
IF NOT 100 mm ON THIS COPY, ADJUST SCALES ACCORDINGLY.

SCHEDULE OF JOINERY

| SYMBOL | Nos. | SILL LEVEL | MASONRY OPENING | | REMARKS |
|--------|------|------------|-----------------|--------|--------------------------------------|
| | | | WIDTH | HEIGHT | |
| ⊕ | 01 | (+).0.000 | 1000 | 2100 | FIRE RATED(3 HR) DOOR-SINGLE SHUTTER |

FOR APPROVAL

POWER GRID CORPORATION OF INDIA LIMITED
(A government of India Enterprise)



±800 kV 6000 MW HVDC Multi Terminal
NER/ER - NR/WR Interconnector-I

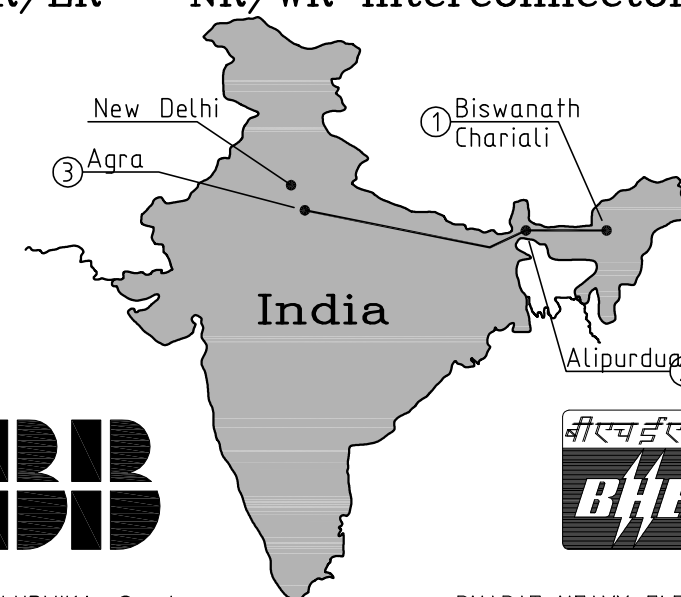


ABB AB
S-771 80 LUDVICA, Sweden
Telephone: +46 240 782000



BHARAT HEAVY ELECTRICALS LTD.
TRANSMISSION PROJECTS DIVISION

Civil and Building Works incl EL and Mech. Services.

CONSULTANT

FICHTNER Consulting
Engineers (India)
Private Limited
Chennai.

AGRA CONVERTER STATION
VALVE HALL POLE - 1
ARCHITECTURAL PLAN
AT ROOF LVL

| | | | | | | | | | |
|---------|-------------------|-----------|------|------------|----------|------------|------------------|---------------|-----|
| R1 | REVISED AS MARKED | 27.09.12 | MV | Date | Drawn by | Checked by | Scale (A1-Print) | Drawing No. | Rev |
| Rev.ind | Revision | Year Week | Appd | 28.08.2012 | RM | MV/MKK | 1:150 | 5517-3-53-101 | R1 |