


GROUND FLOOR PLAN

- SMOKE DETECTOR
- Control Panel for smoke detector

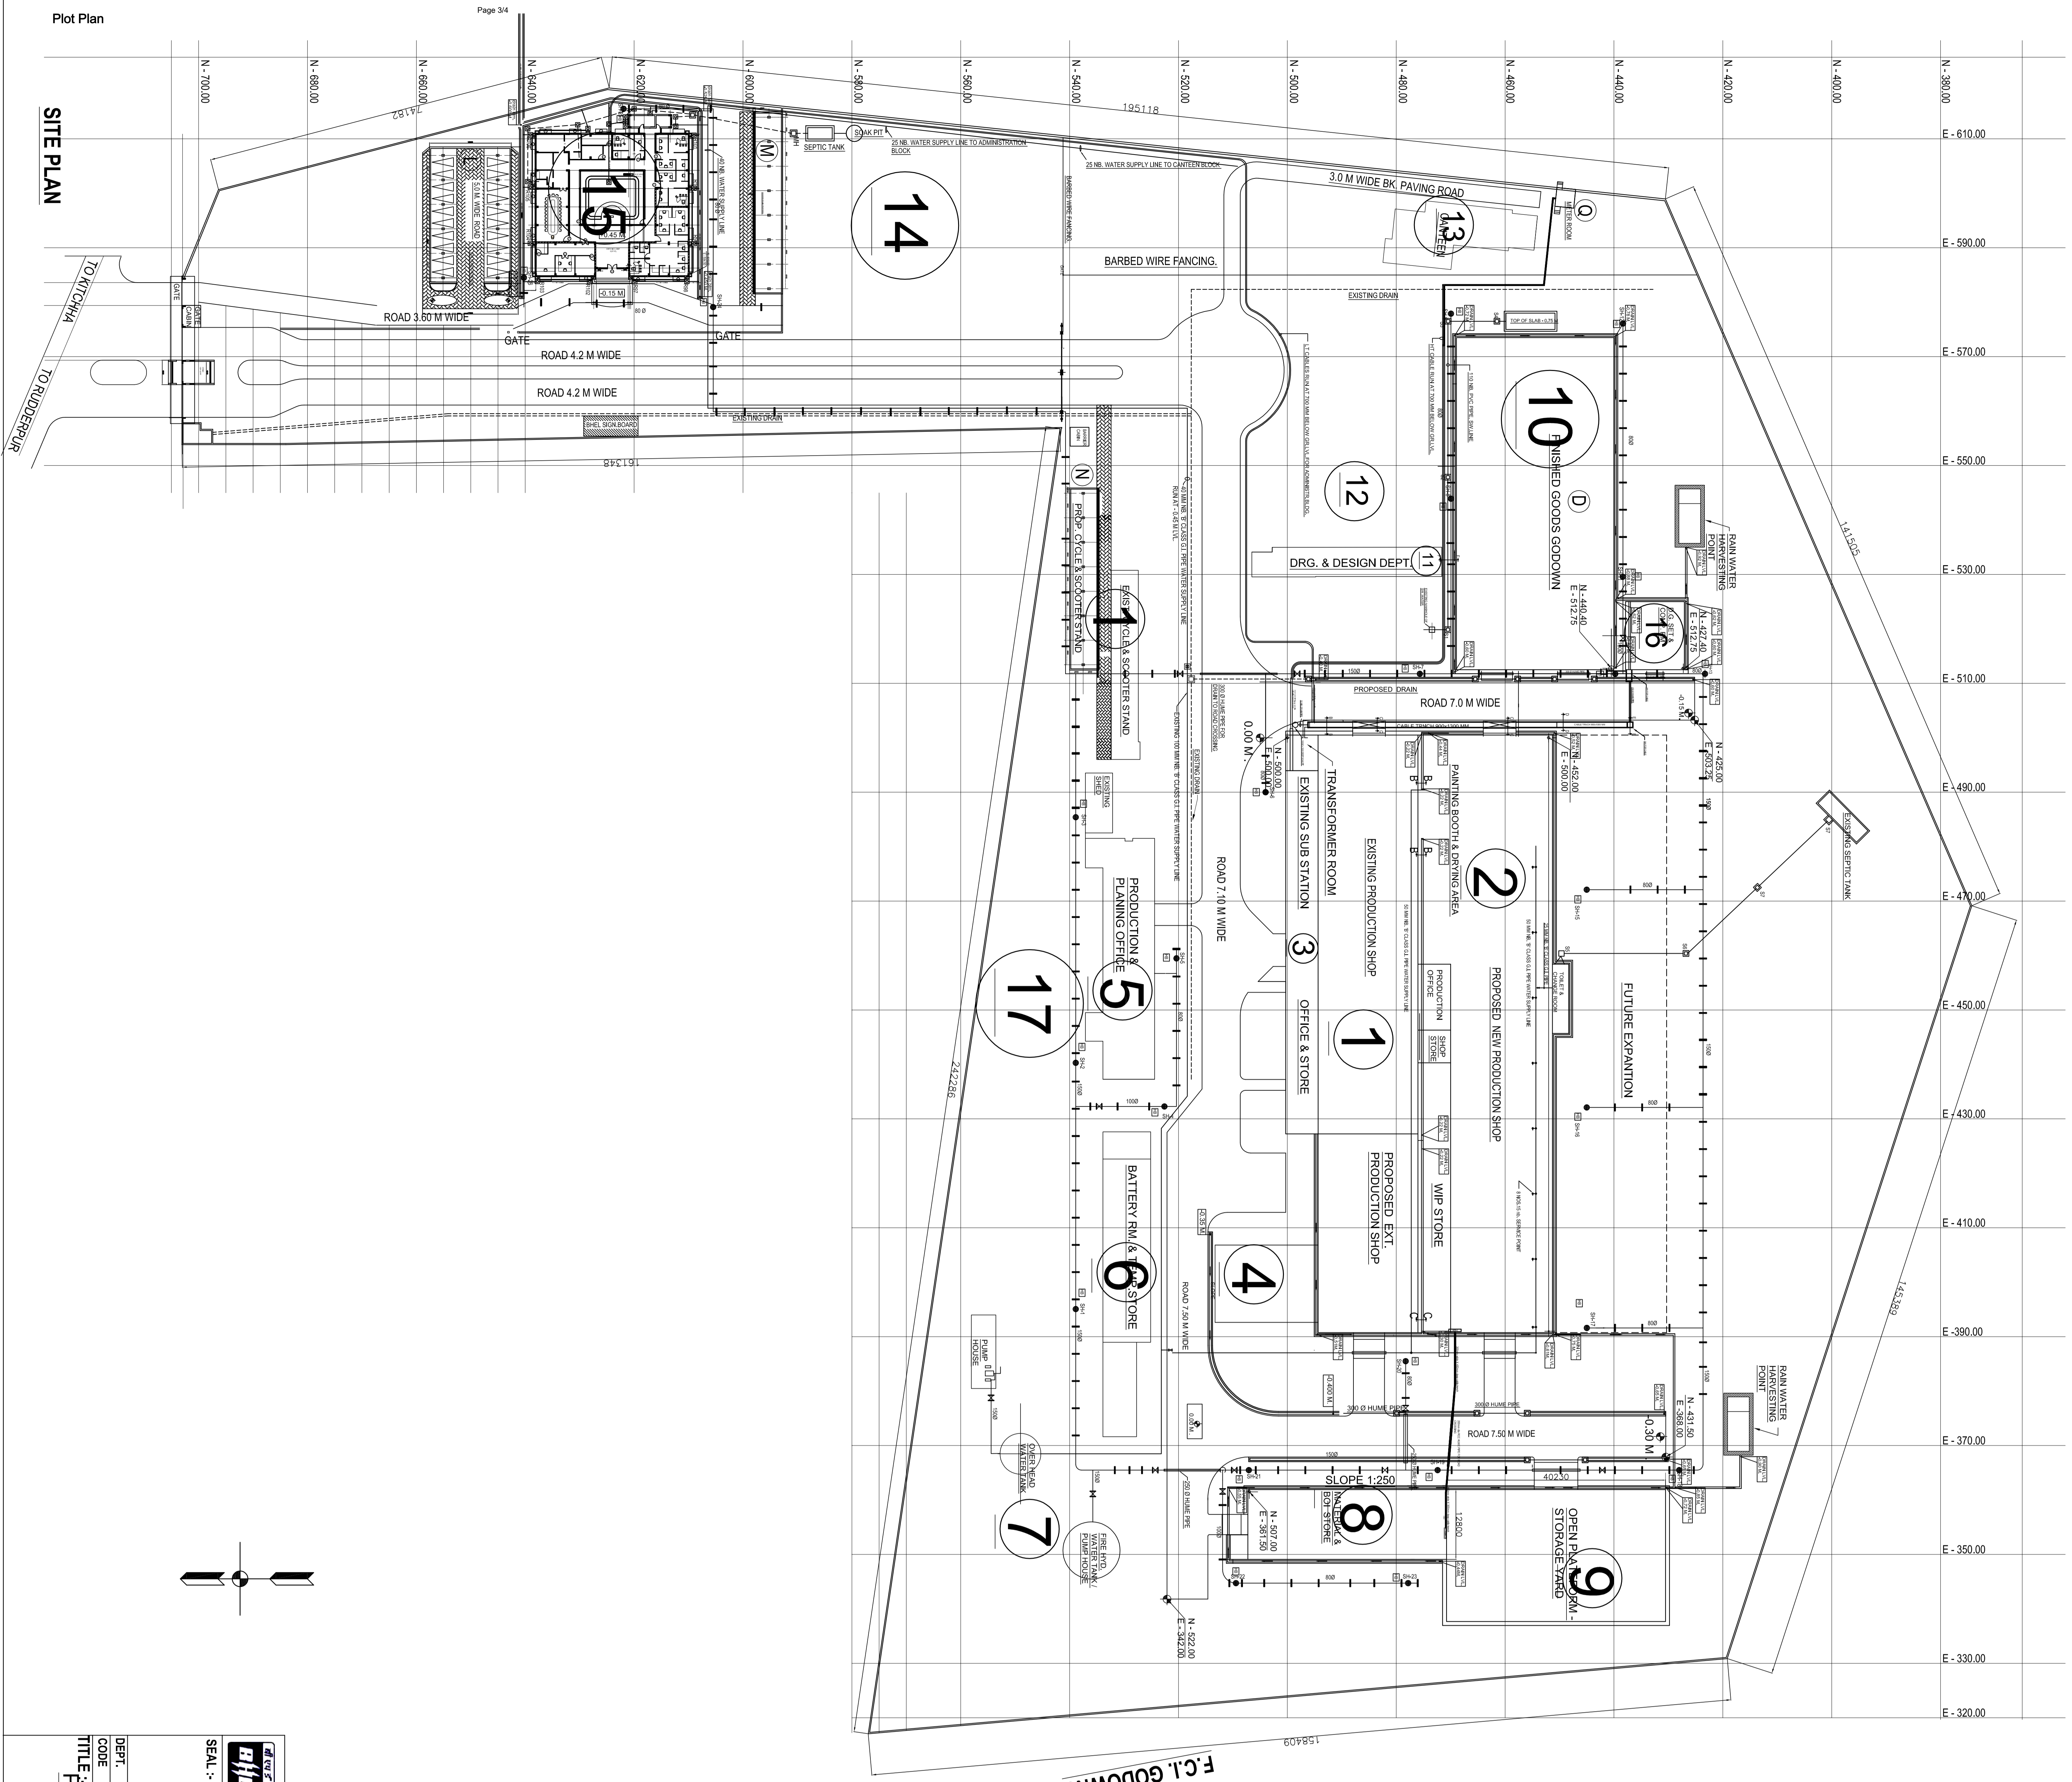


NO.	REVISIONS	DATE
1	ISSUED FOR PERMIT	2022
2	REVISED FOR COMMENTS	2022
3	REVISED FOR COMMENTS	2022
4	REVISED FOR COMMENTS	2022
5	REVISED FOR COMMENTS	2022
6	REVISED FOR COMMENTS	2022
7	REVISED FOR COMMENTS	2022
8	REVISED FOR COMMENTS	2022
9	REVISED FOR COMMENTS	2022
10	REVISED FOR COMMENTS	2022
11	REVISED FOR COMMENTS	2022
12	REVISED FOR COMMENTS	2022
13	REVISED FOR COMMENTS	2022
14	REVISED FOR COMMENTS	2022
15	REVISED FOR COMMENTS	2022
16	REVISED FOR COMMENTS	2022
17	REVISED FOR COMMENTS	2022

SEAL:-

BHARAT HEAVY ELECTRICALS LTD.
RUDRAPUR UDHAMSINGH NAGAR, UTTARAKHAND.

DEPT. CODE	SCALE 1:500	DRAWING NO. APA-01	REV. 0
TITLE PLOT PLAN			

DIN BY: _____
CND BY: _____
APPD BY: _____
NAME SIGN DATE

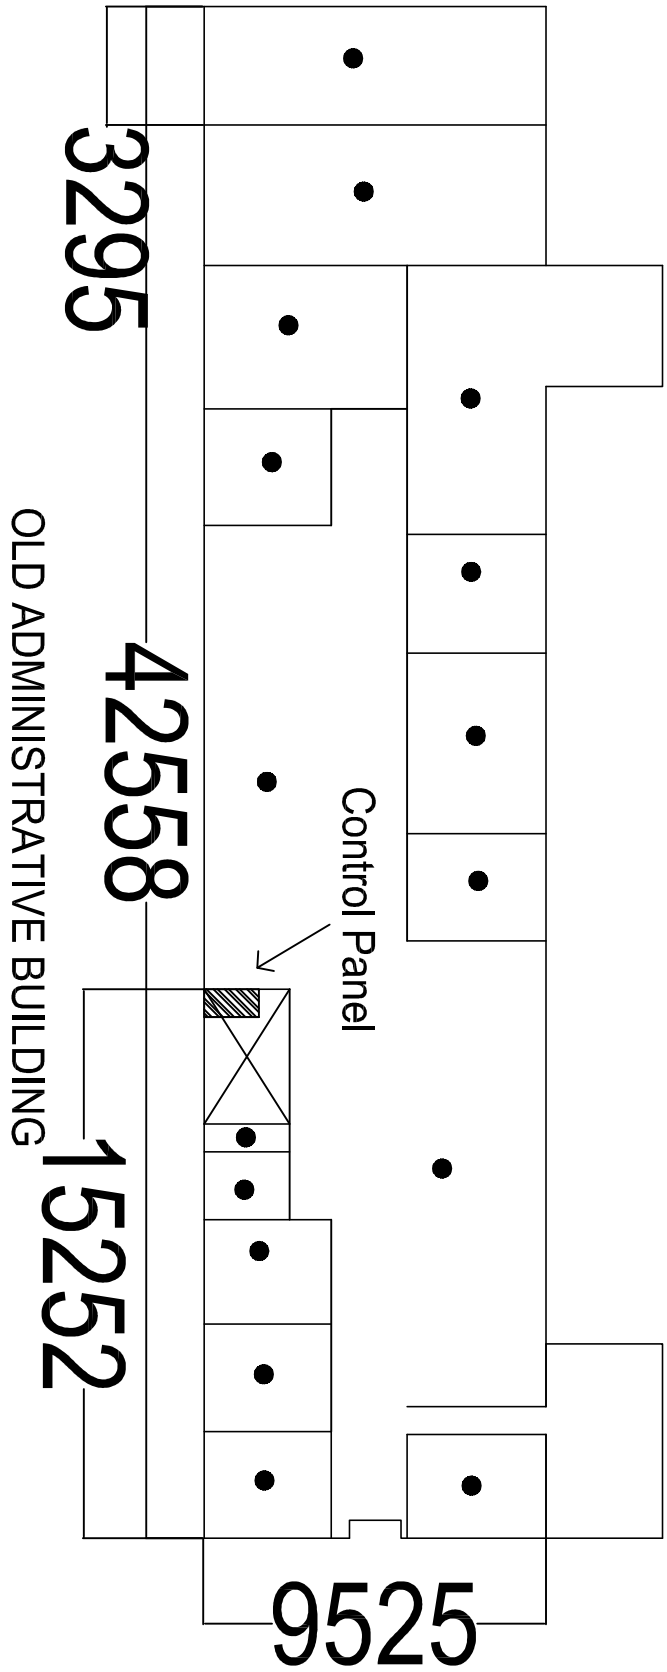

- SMOKE DETECTOR
- ▨ Control Panel for smoke detector