


ELEVATION

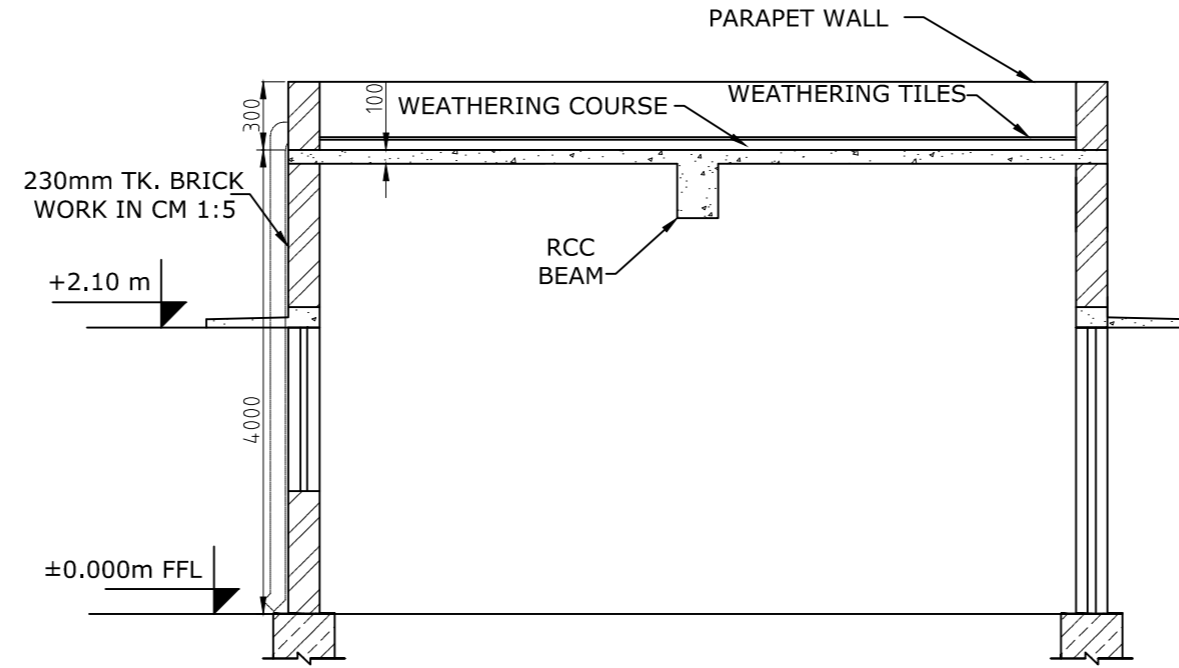


SECTION-XX

NOTES:-


- 1) ALL DIMENSIONS ARE IN 'MM' & LEVELS ARE IN 'M'
- 2) CONCRETE GRADE M20
- 3) ALL REINFORCEMENT BARS SHALL BE HIGH YIELD STRENGTH DEFORMED BARS CONFORMING TO IS:1786-(LATEST REVISION)
- 4) DEVELOPMENT LENGTH LD = 50 TIMES THE DIA OF THE BAR
- 5) CLEAR COVER TO REINFORCEMENT AS FOLLOWS
 A) INTEL-20MM
 B) SUNSHADE-15MM
 C) ROOF SLAB-20MM

LEGEND:-


- W - GLAZED STEEL WINDOW - 1000 X 1200
- D - GLAZED STEEL DOOR - 1200 X 2100

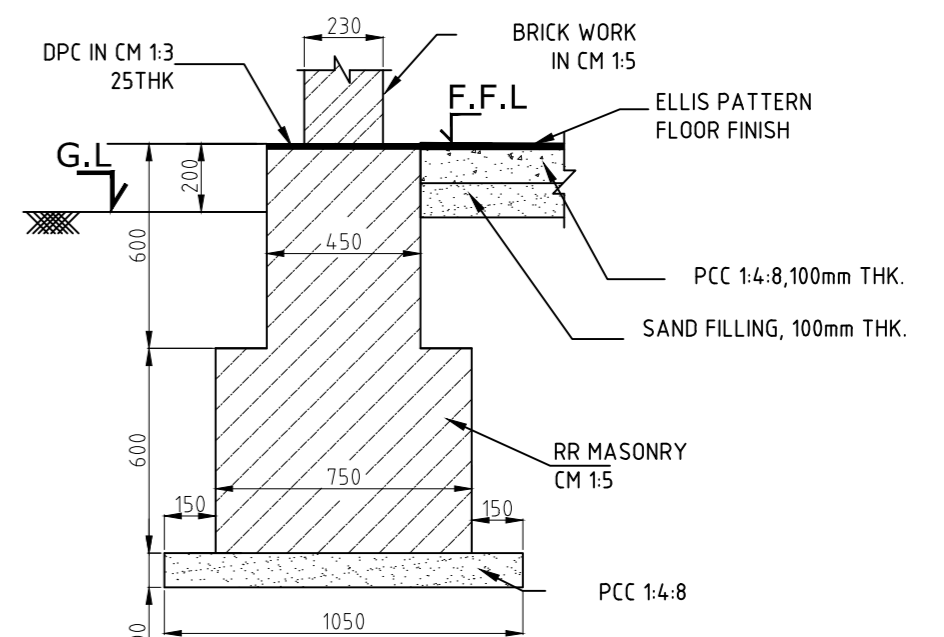


DETAILS OF WALL FOUNDATION & FLOORING

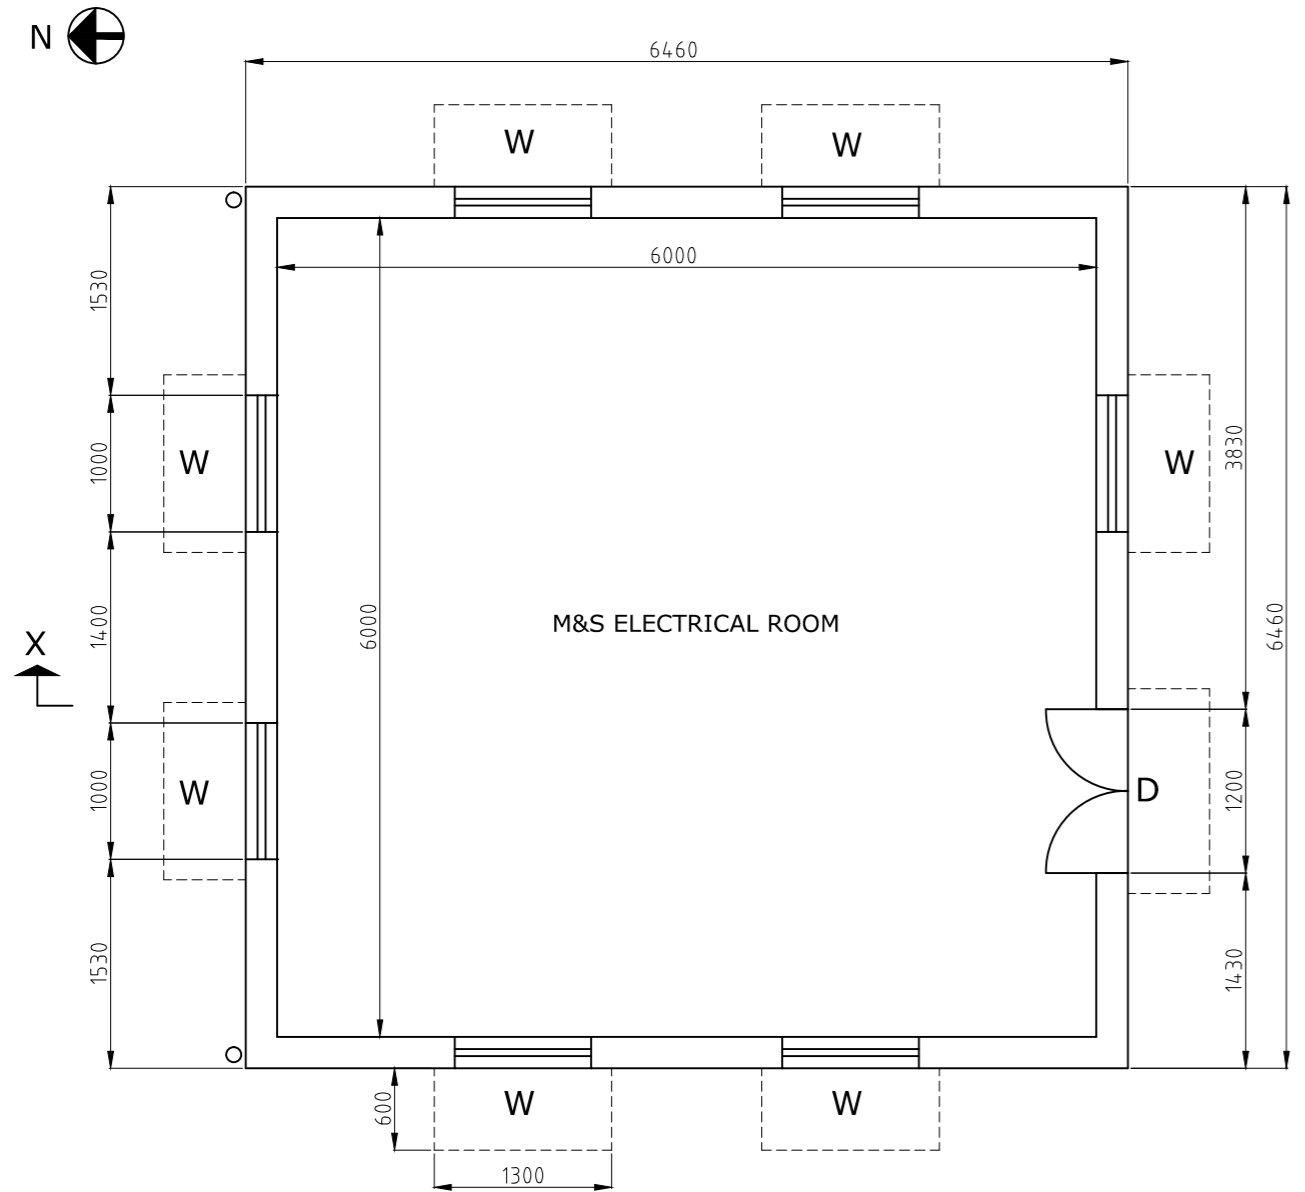

PLAN

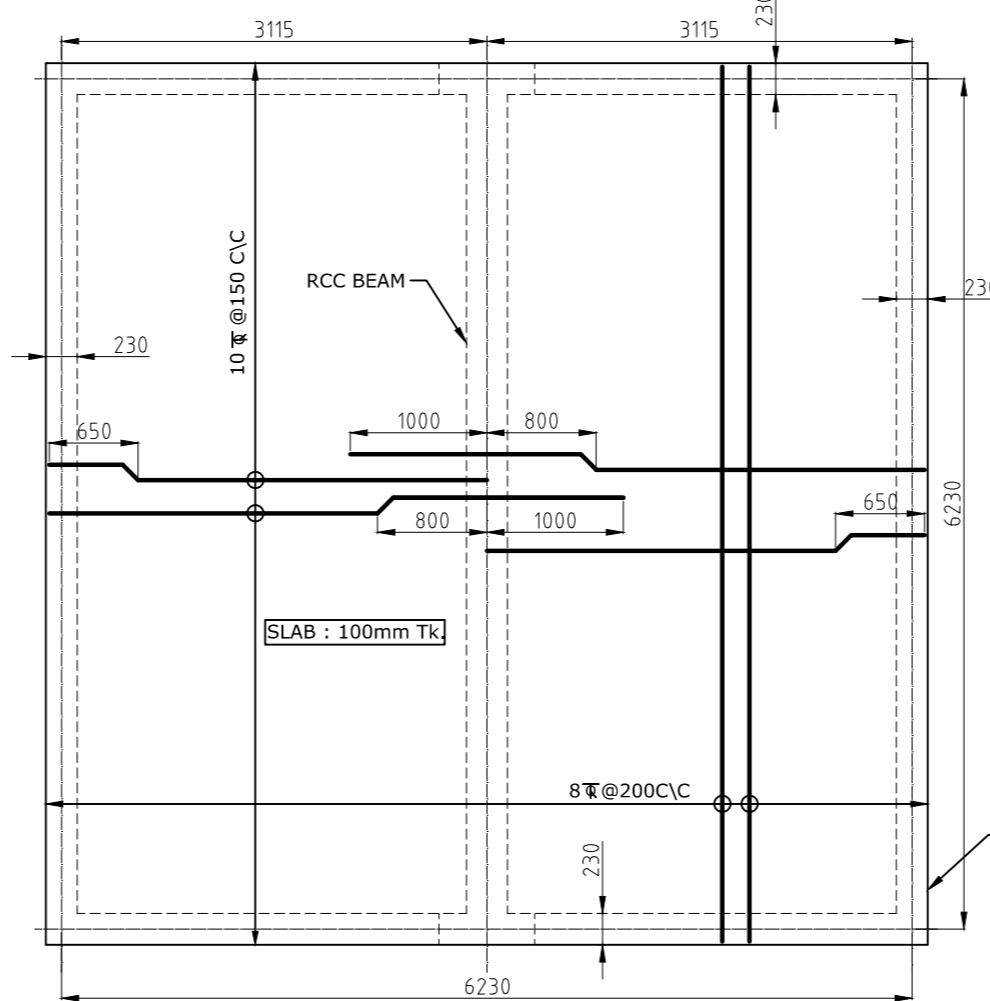


REINFORCEMENT DETAILS OF ROOF SLAB

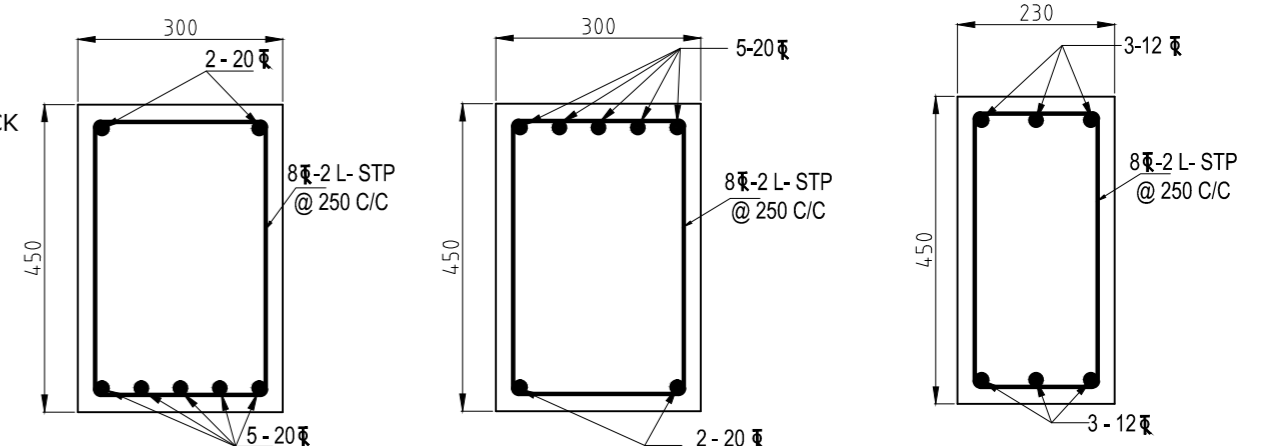


SECTION E-E

SECTION G-G


SECTION F-F
DETAILS OF BED BLOCK

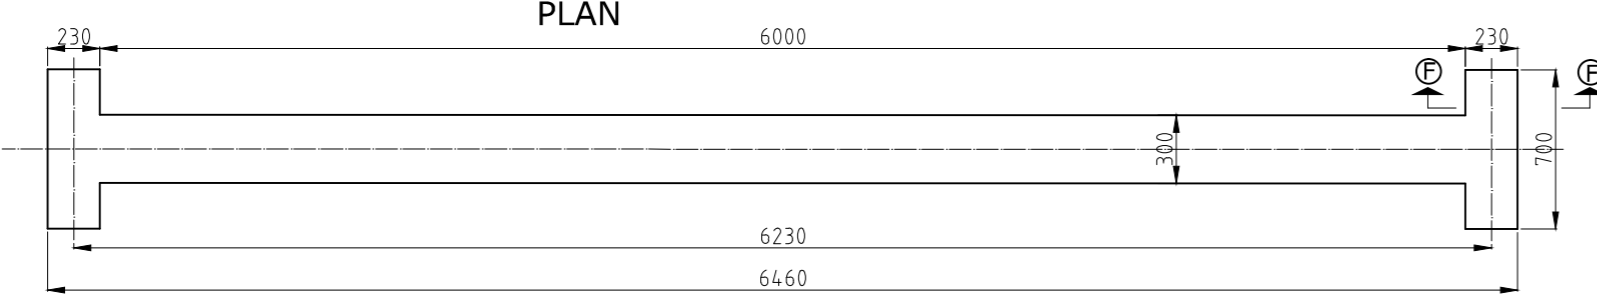

PLAN FOR BEAM WITH BED BLOCK

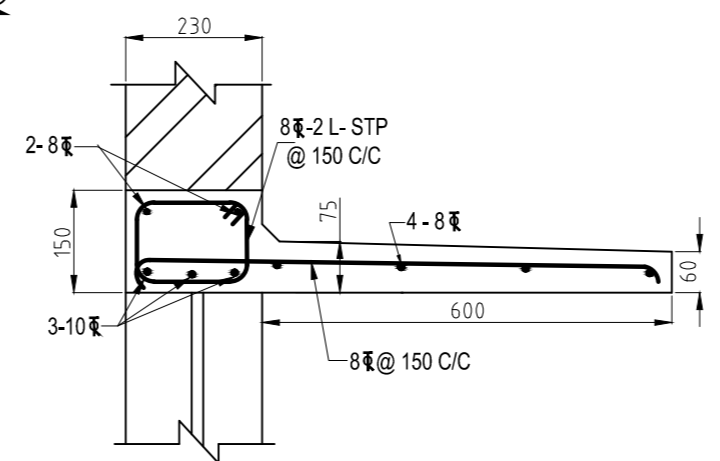







DETAILS OF LINTEL CUM SUNSHADE

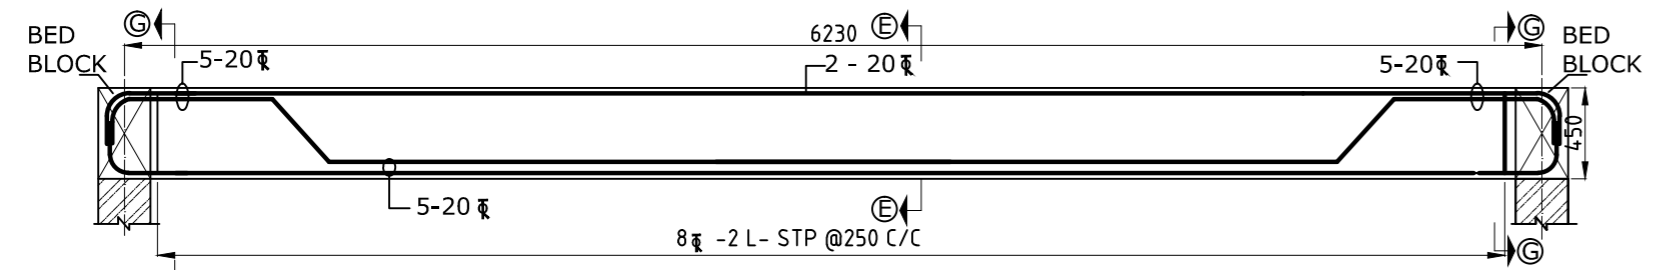

LONGITUDINAL SECTION OF BEAM

CAUTION: The information on this drawing is the property of BHARAT HEAVY ELECTRICALS. It is not to be used, directly or indirectly, in any way detrimental to the interest of the company.

TYPE OF PRODUCT OR NAME OF CUSTOMER/PROJECT		58-CANTEEN						
Bharat Heavy Electricals Ltd UNIT: HIGH PRESSURE BOILER PLANT TIRUCHIRAPALLI - 620014		NAME	SIGNATURE	DATE	NO OF VAR			
		DRN	MAHESHWARI B	10.10.14				
		CHD	AARUYIR YOGAA T	10.10.14				
		APPD	K.GUNASEKARAN	10.10.14				
DEPT	CIVIL	GRADE OF UNITS DIM	C/M/F	SCALE	WEIGHT (Kg)	REF TO ASSY / OLD DWG	ITEM NO	NO OF ITEMS
CODE	2200							
TITLE		CARD CODE	DRAWING NO :		REV			
GENERAL ARRANGEMENT & DETAILS OF ELECTRICAL ROOM		U 01	2-TP-CEG-01643		00			

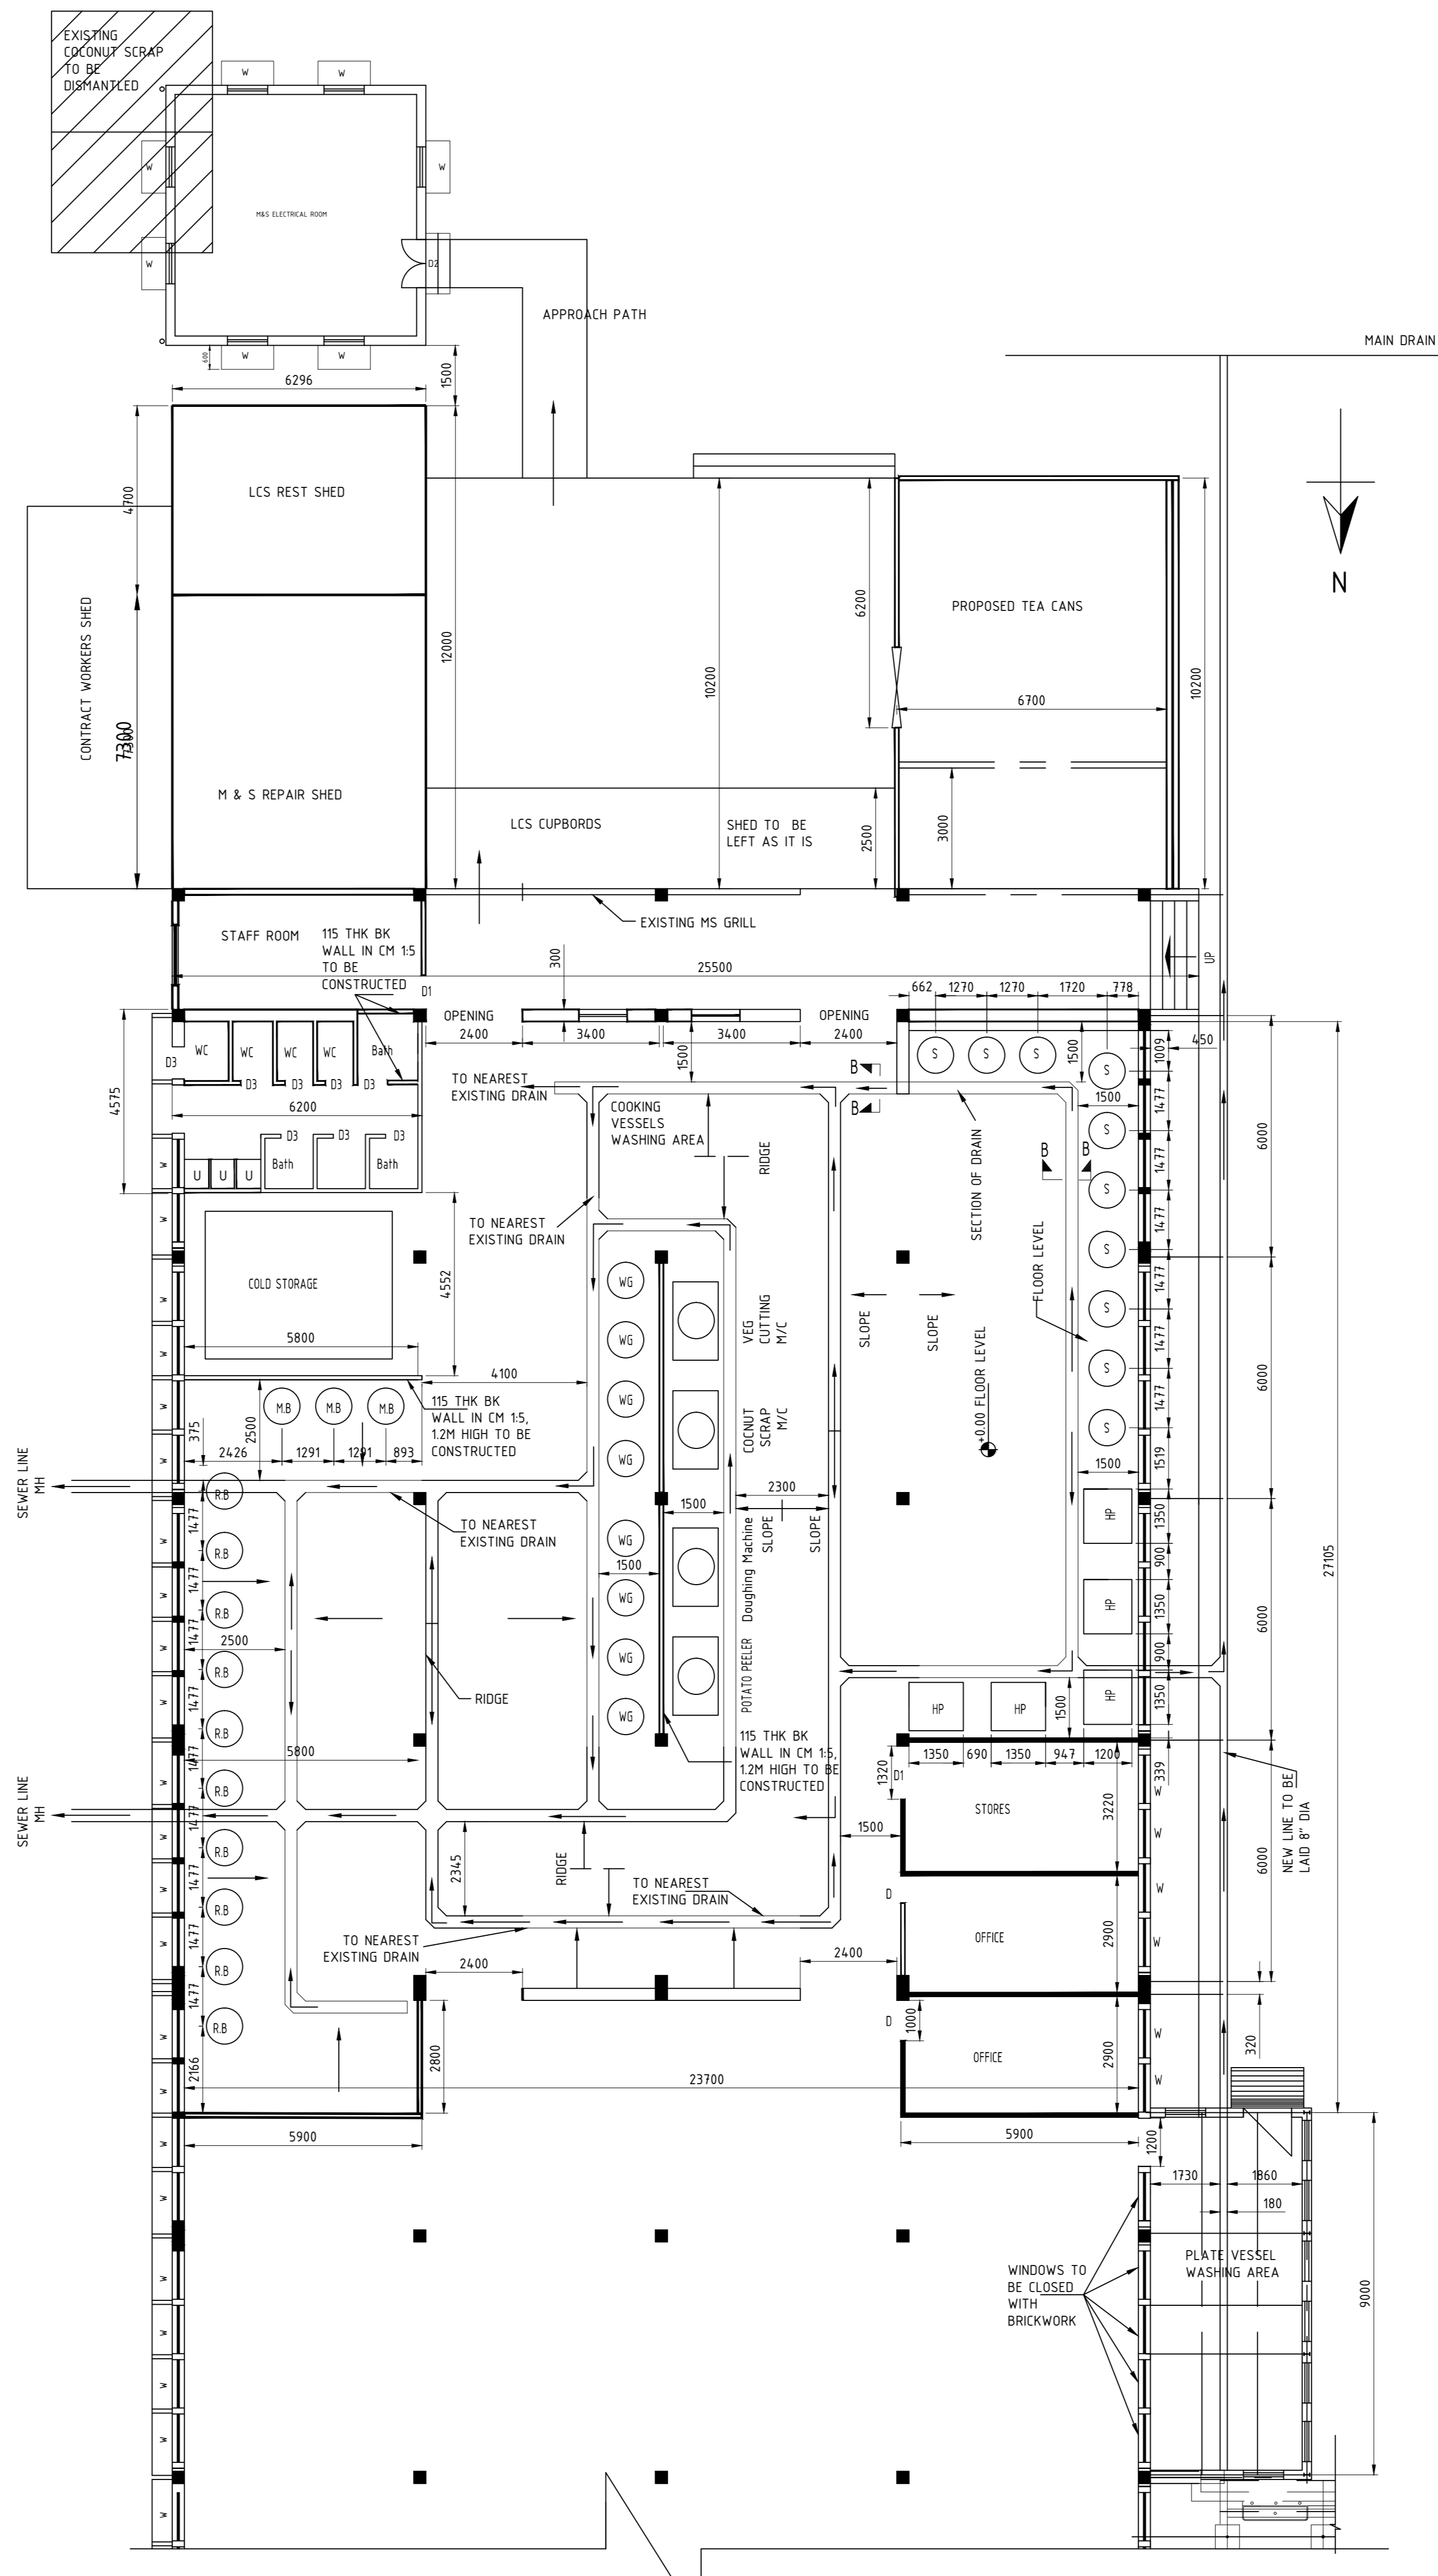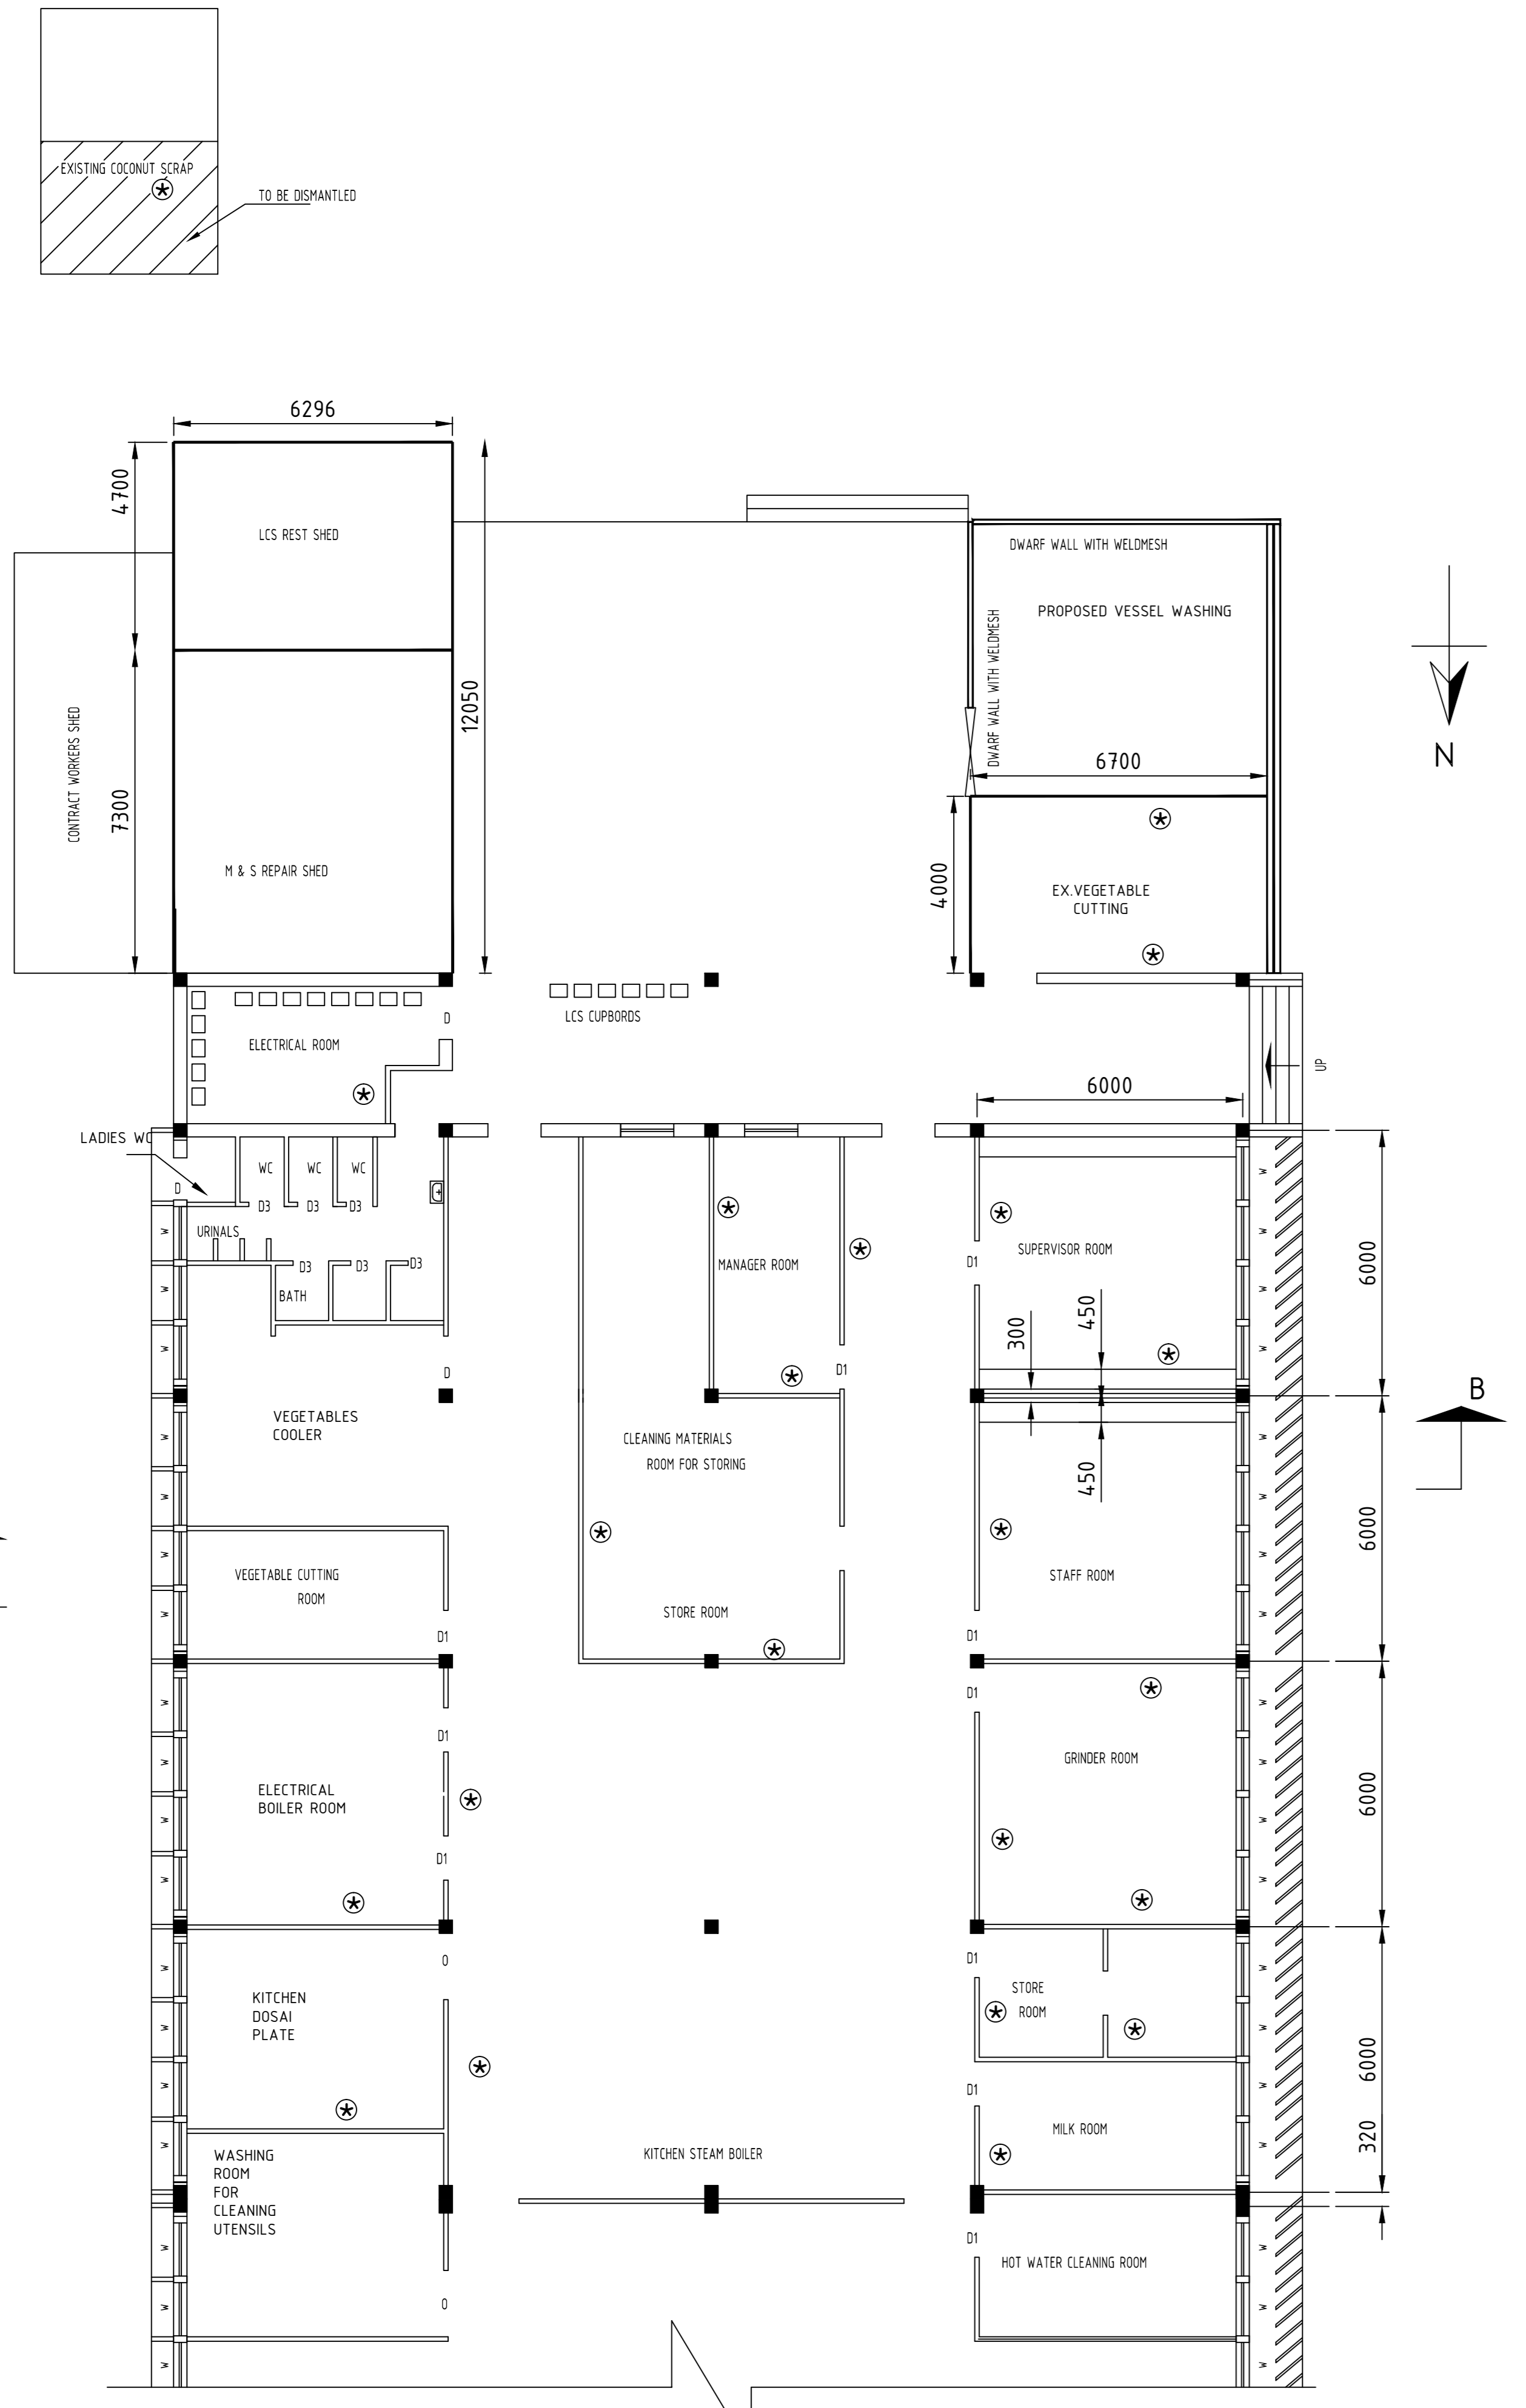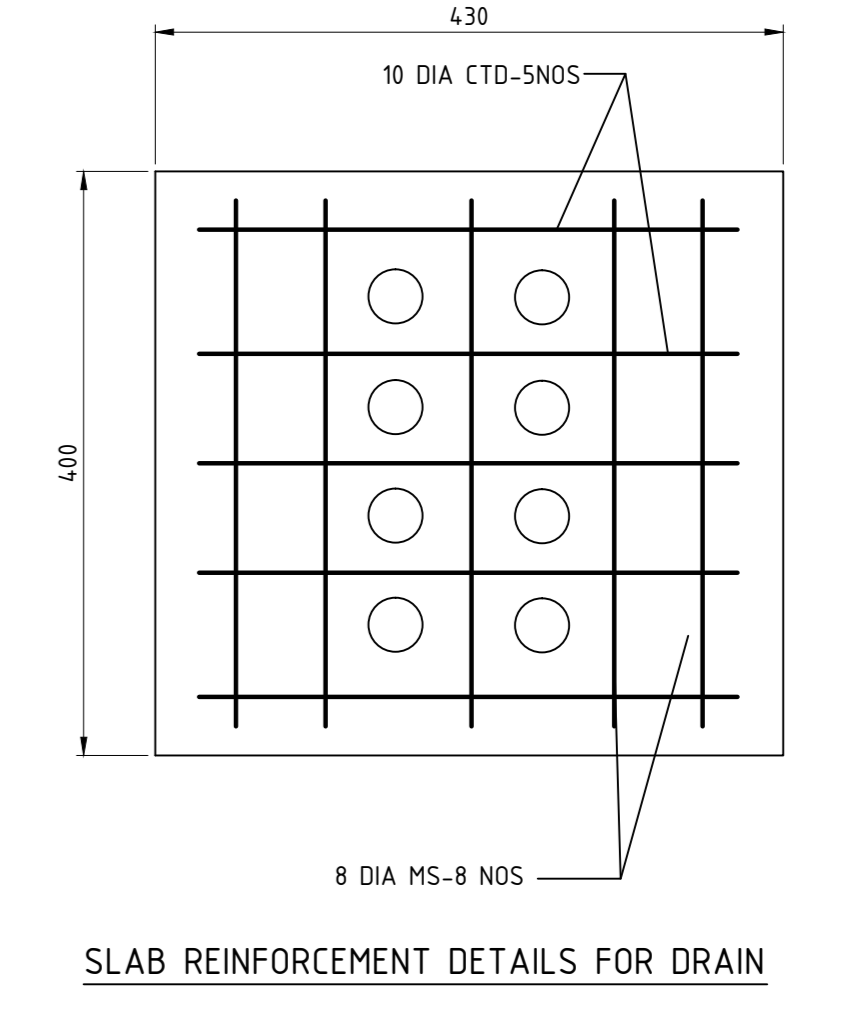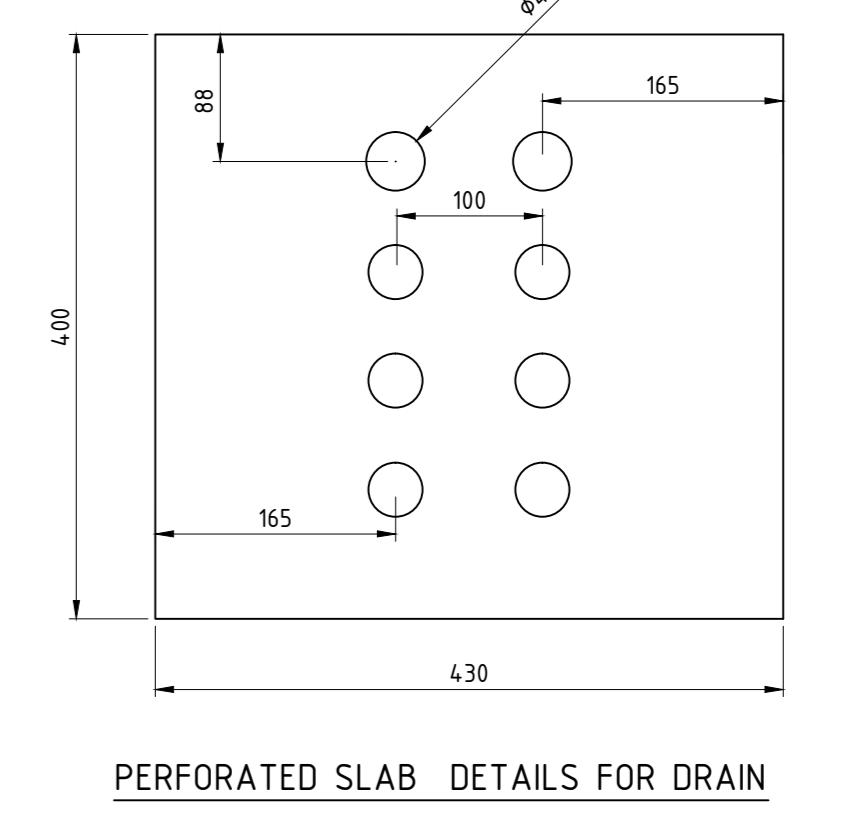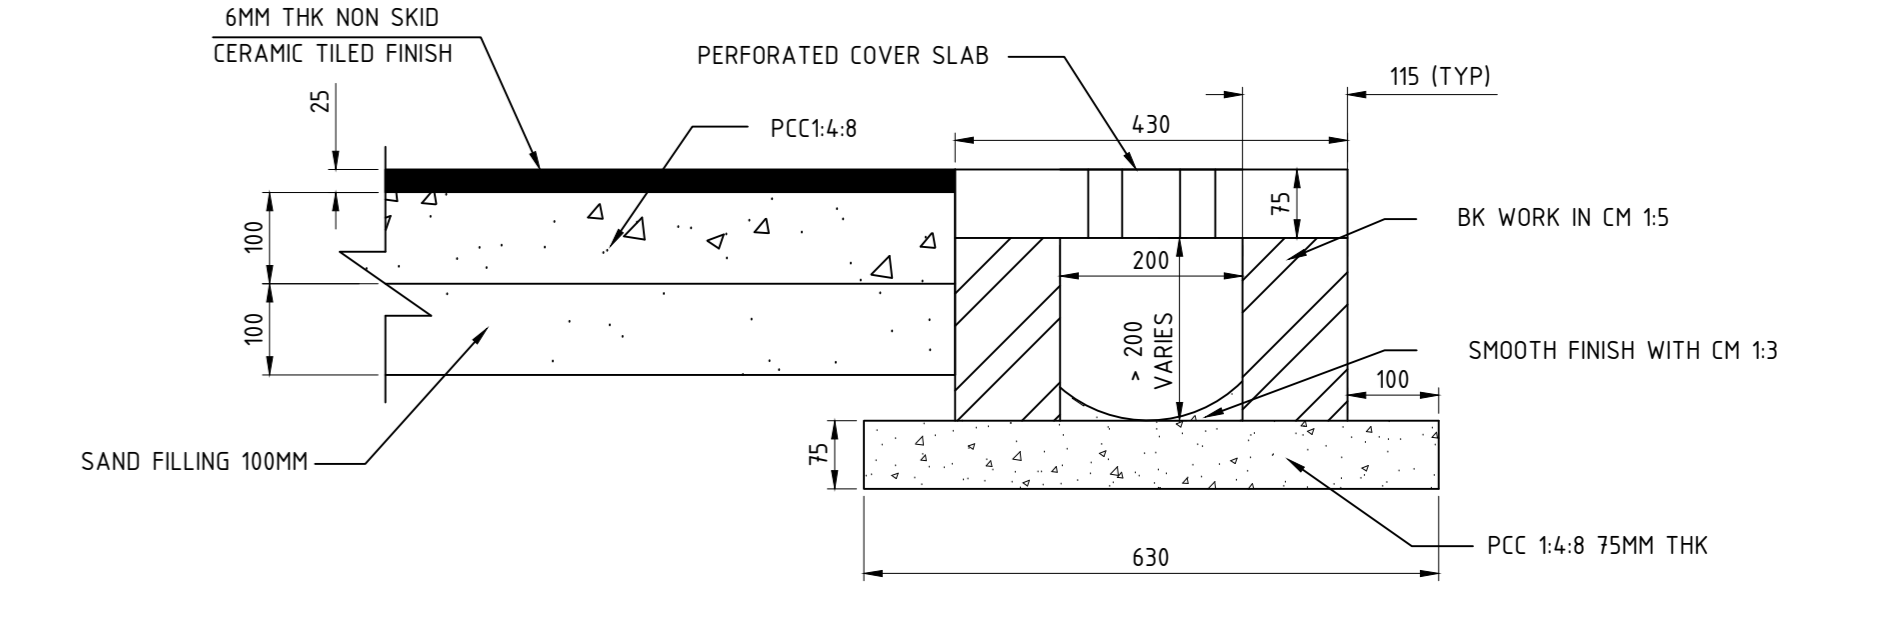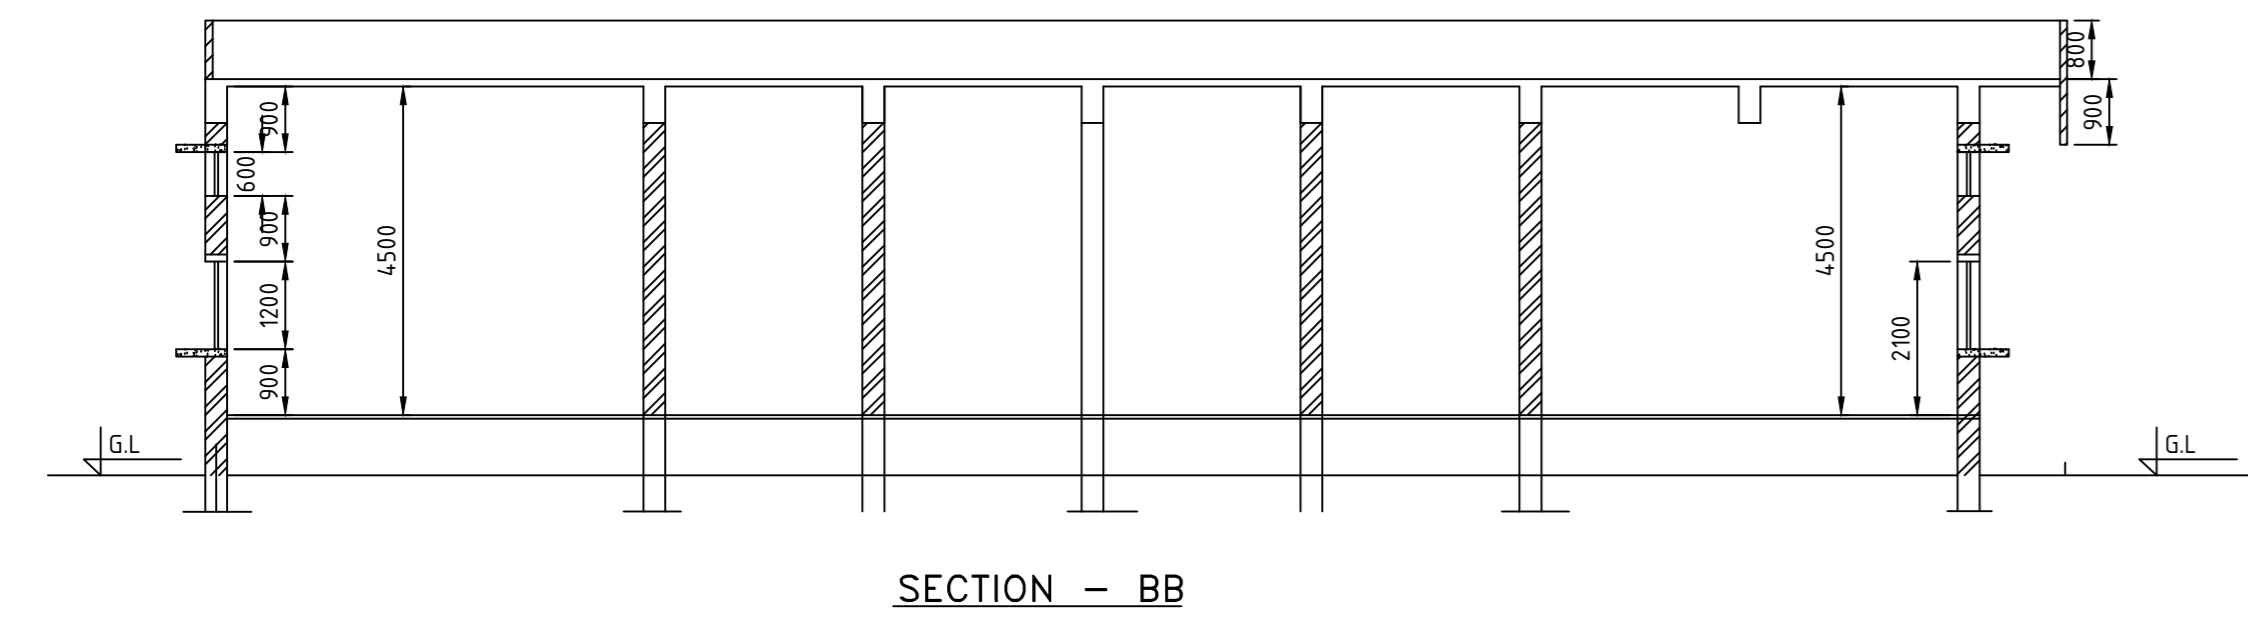

- NOTES:**
- ALL DIMENSIONS ARE IN MM AND LEVELS ARE IN METRES
 - FOR DETAILS OF PROPOSED ELECTRICAL ROOM REFER 2-TP-CEG-01643 LATEST
 - WALLS ARE TO BE DISMANTLED
- LEGENDS:**
- D - GLAZED ALUMINIUM DOOR - 1000X2100
 - D1 - GLAZED STEEL DOOR - 1000X2100
 - D2 - GLAZED STEEL DOOR - 1200X2100
 - D3 - P.V.C DOOR - 900 X2000
 - W - GLAZED ALUMINIUM SLIDING WINDOW WITH GRILL - 1200X1200
 - WC - WATER CLOSET
 - U - URINAL
 - MH - MAN HOLE

TYPE OF PRODUCT OR NAME OF CUSTOMER/PROJECT		58 CANTEEN			
Bharat Heavy Electricals Ltd UNIT: HIGH PRESSURE BOILER PLANT TIRUCHIRAPALLI - 620014		DRW	NAME	SIGNATURE	DATE
DEPT	SCALE	WEIGHT (KG)	REF TO ASSY / OLD DWG	REV	NO. OF PAGES
CODE	1:50				
TITLE		DRAWING NO :		REV	
MODIFICATION TO EXISTING KITCHEN AREA		U 01		0-TP-CEG-01639 00	

