


LAYOUT PLAN OF UNIT-7 & 8 420kV SWITCHYARD

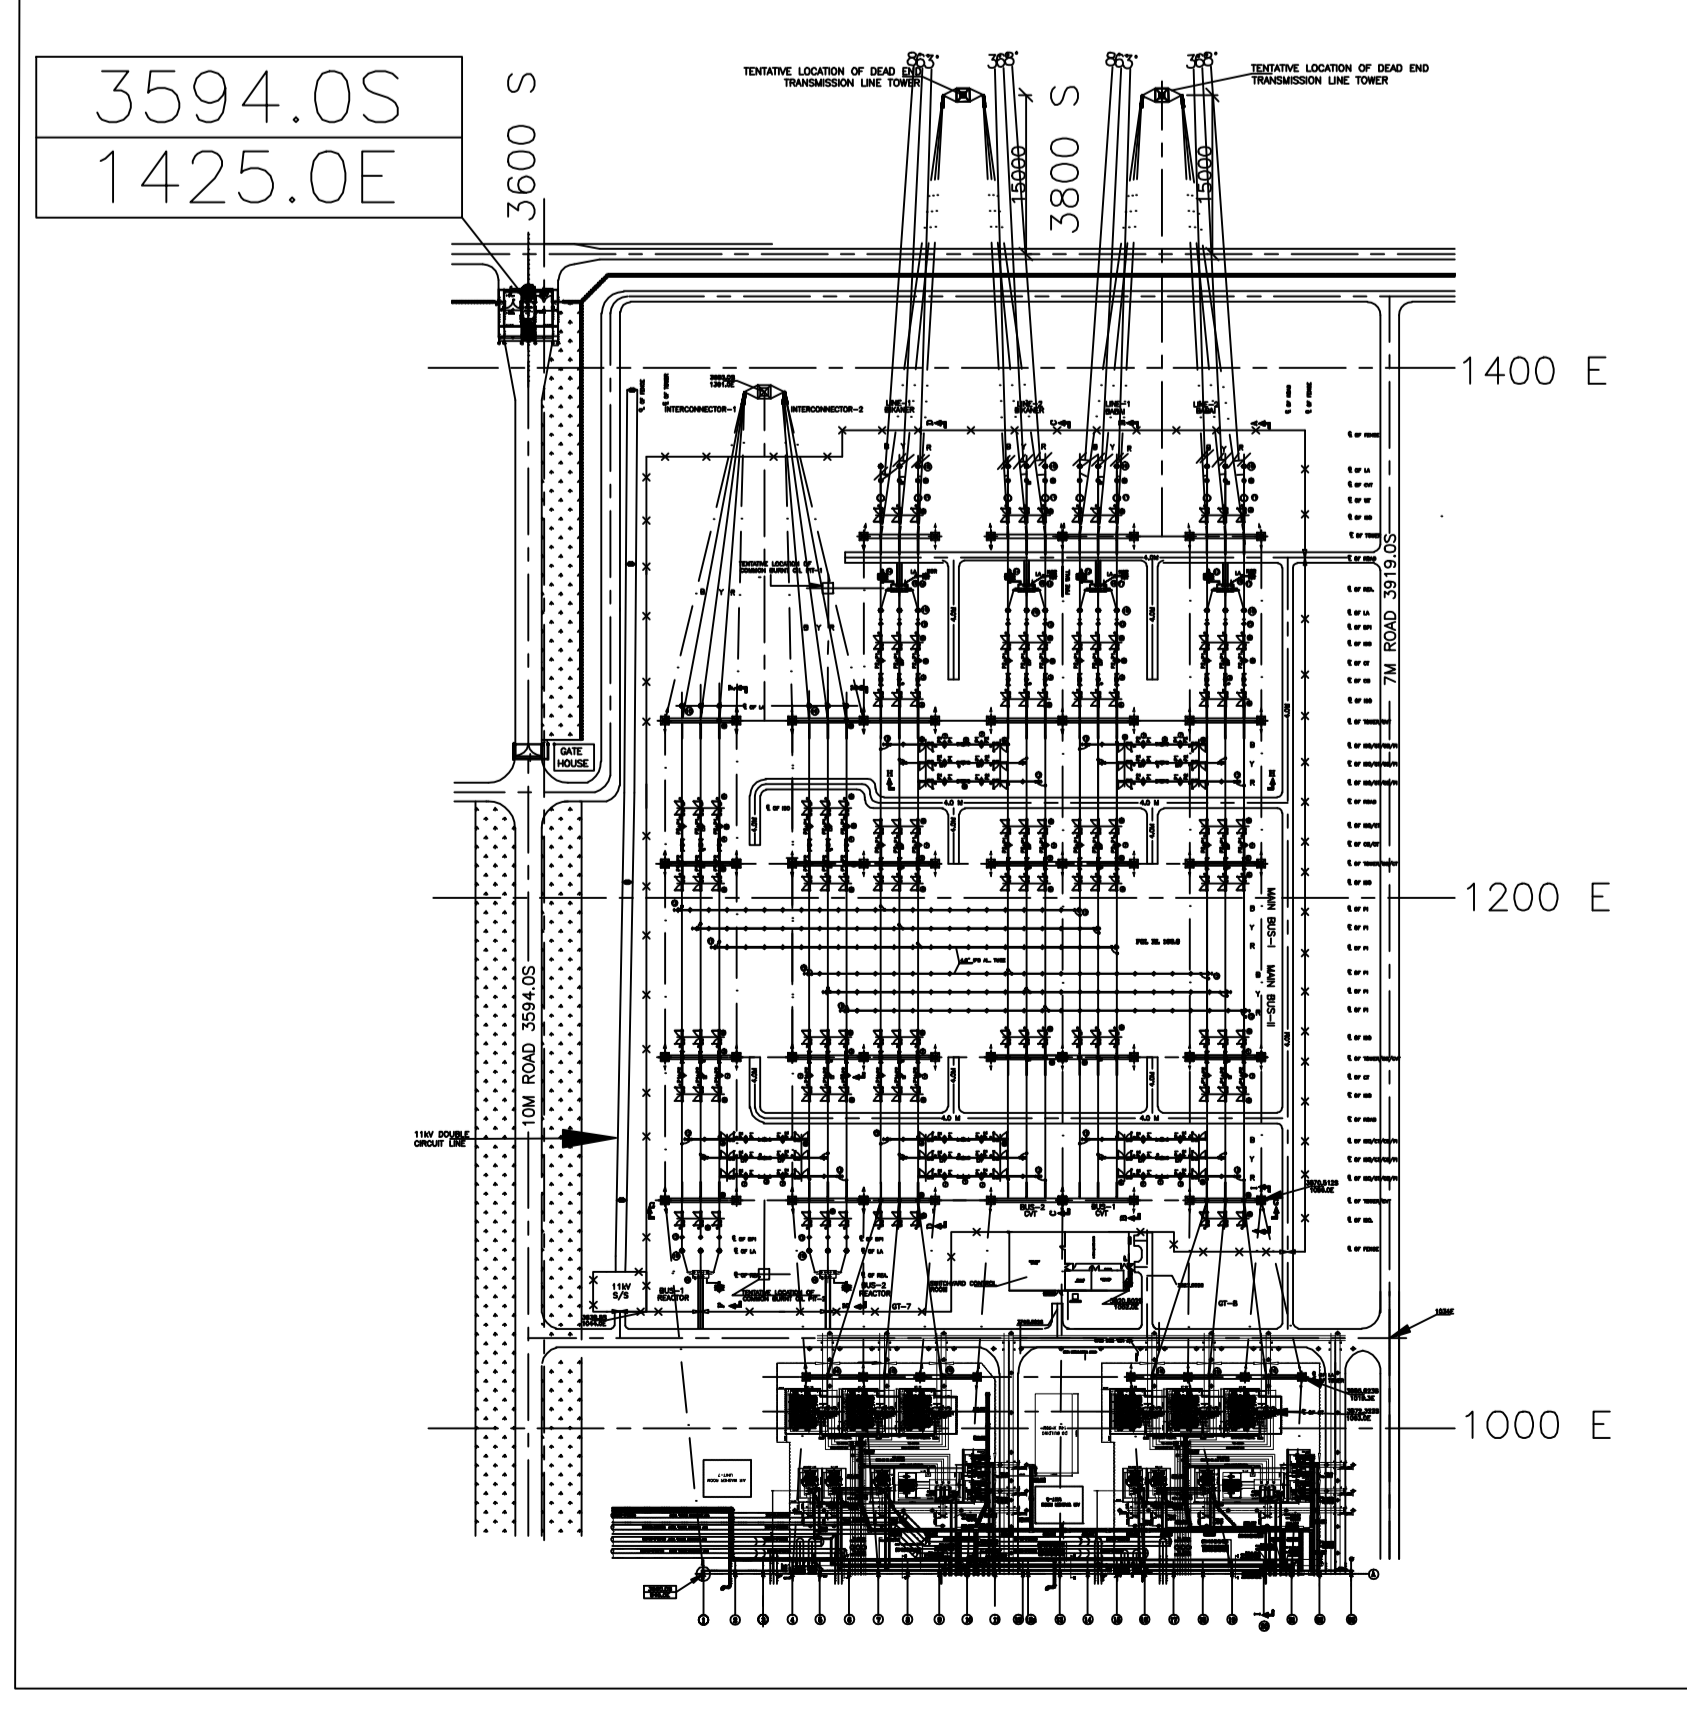

KEY PLAN

03	13.08.14	AS PER TCE LETTER DATED 27.02.14	RK	SK	SKS	RS
02	05.02.14	AS PER TCE LETTER DATED 29.11.13	RK	SK -SD-	SKS -SD-	RS -SD-
01	04.10.13	AS PER TCE LETTER DATED 16.09.13	RK	SK -SD-	SKS -SD-	RS -SD-
REV.	DATE	REASONS FOR REVISION	DRN.	PREPARED BY	CHECKED BY	APPROVED BY
OWNER RAJASTHAN RAJYA VIDYUT UTPANDAN NIGAM LIMITED						
PROJECT 2X660MW THERMAL POWER PLANT, SURAT GARH STAGE -V, UNIT 7 & 8 AT SURATGARH , RAJASTHAN						
OWNER'S ENGINEER TATA CONSULTING ENGINEERS LIMITED						
EPC CONTRACTOR BHARAT HEAVY ELECTRICALS LTD TRANSMISSION BUSINESS GROUP						
DEPT CODE	NAME	SIGN.	DATE			
422	DRN RK	-SD-	05.08.13			
	DESIGN SK	-SD-				
	CHD SKS	-SD-				
	APPD SS					
TITLE LAYOUT PLAN FOR 400kV S/S AT SURATGARH						
CV	ME	EL	I&C	DEPT. SCALE 1:650	BHEL/SUB VENDOR DRG NO. TB-0-360-316-002	
				SIGN	SHT. No 02 OF 02 REV. 03	
				DATE		