
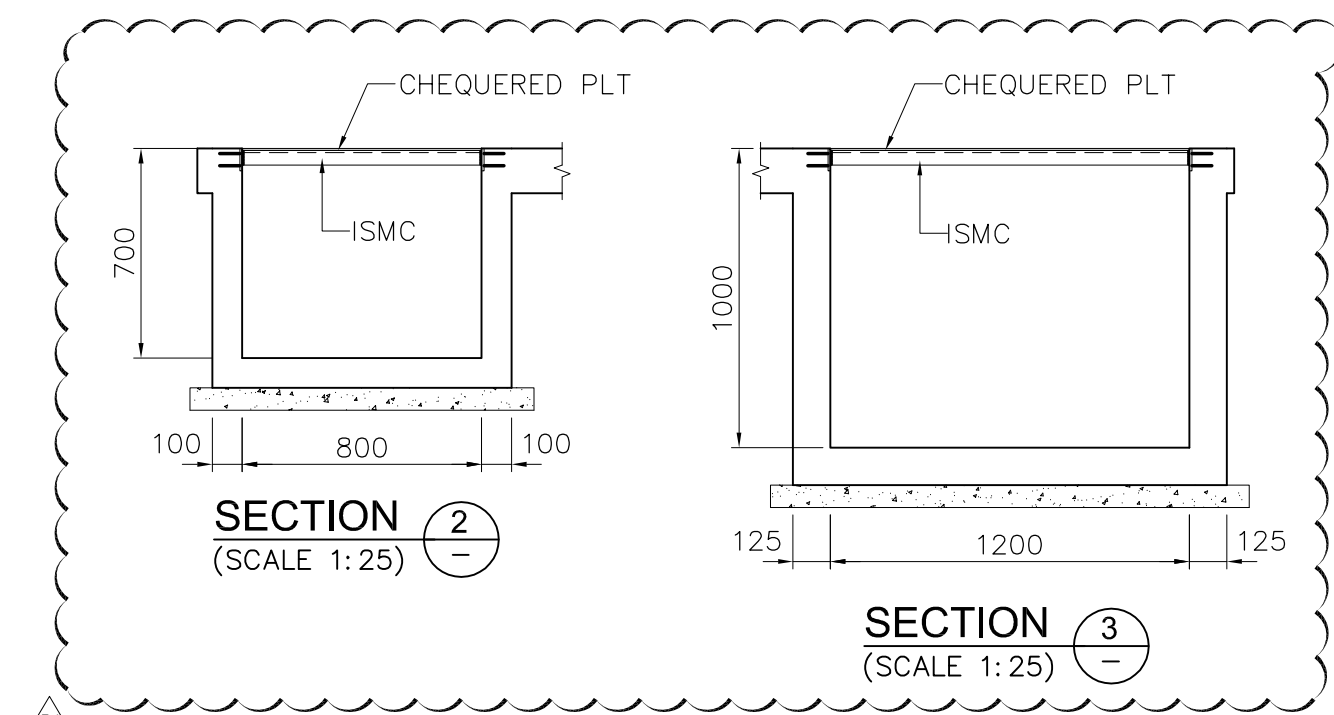
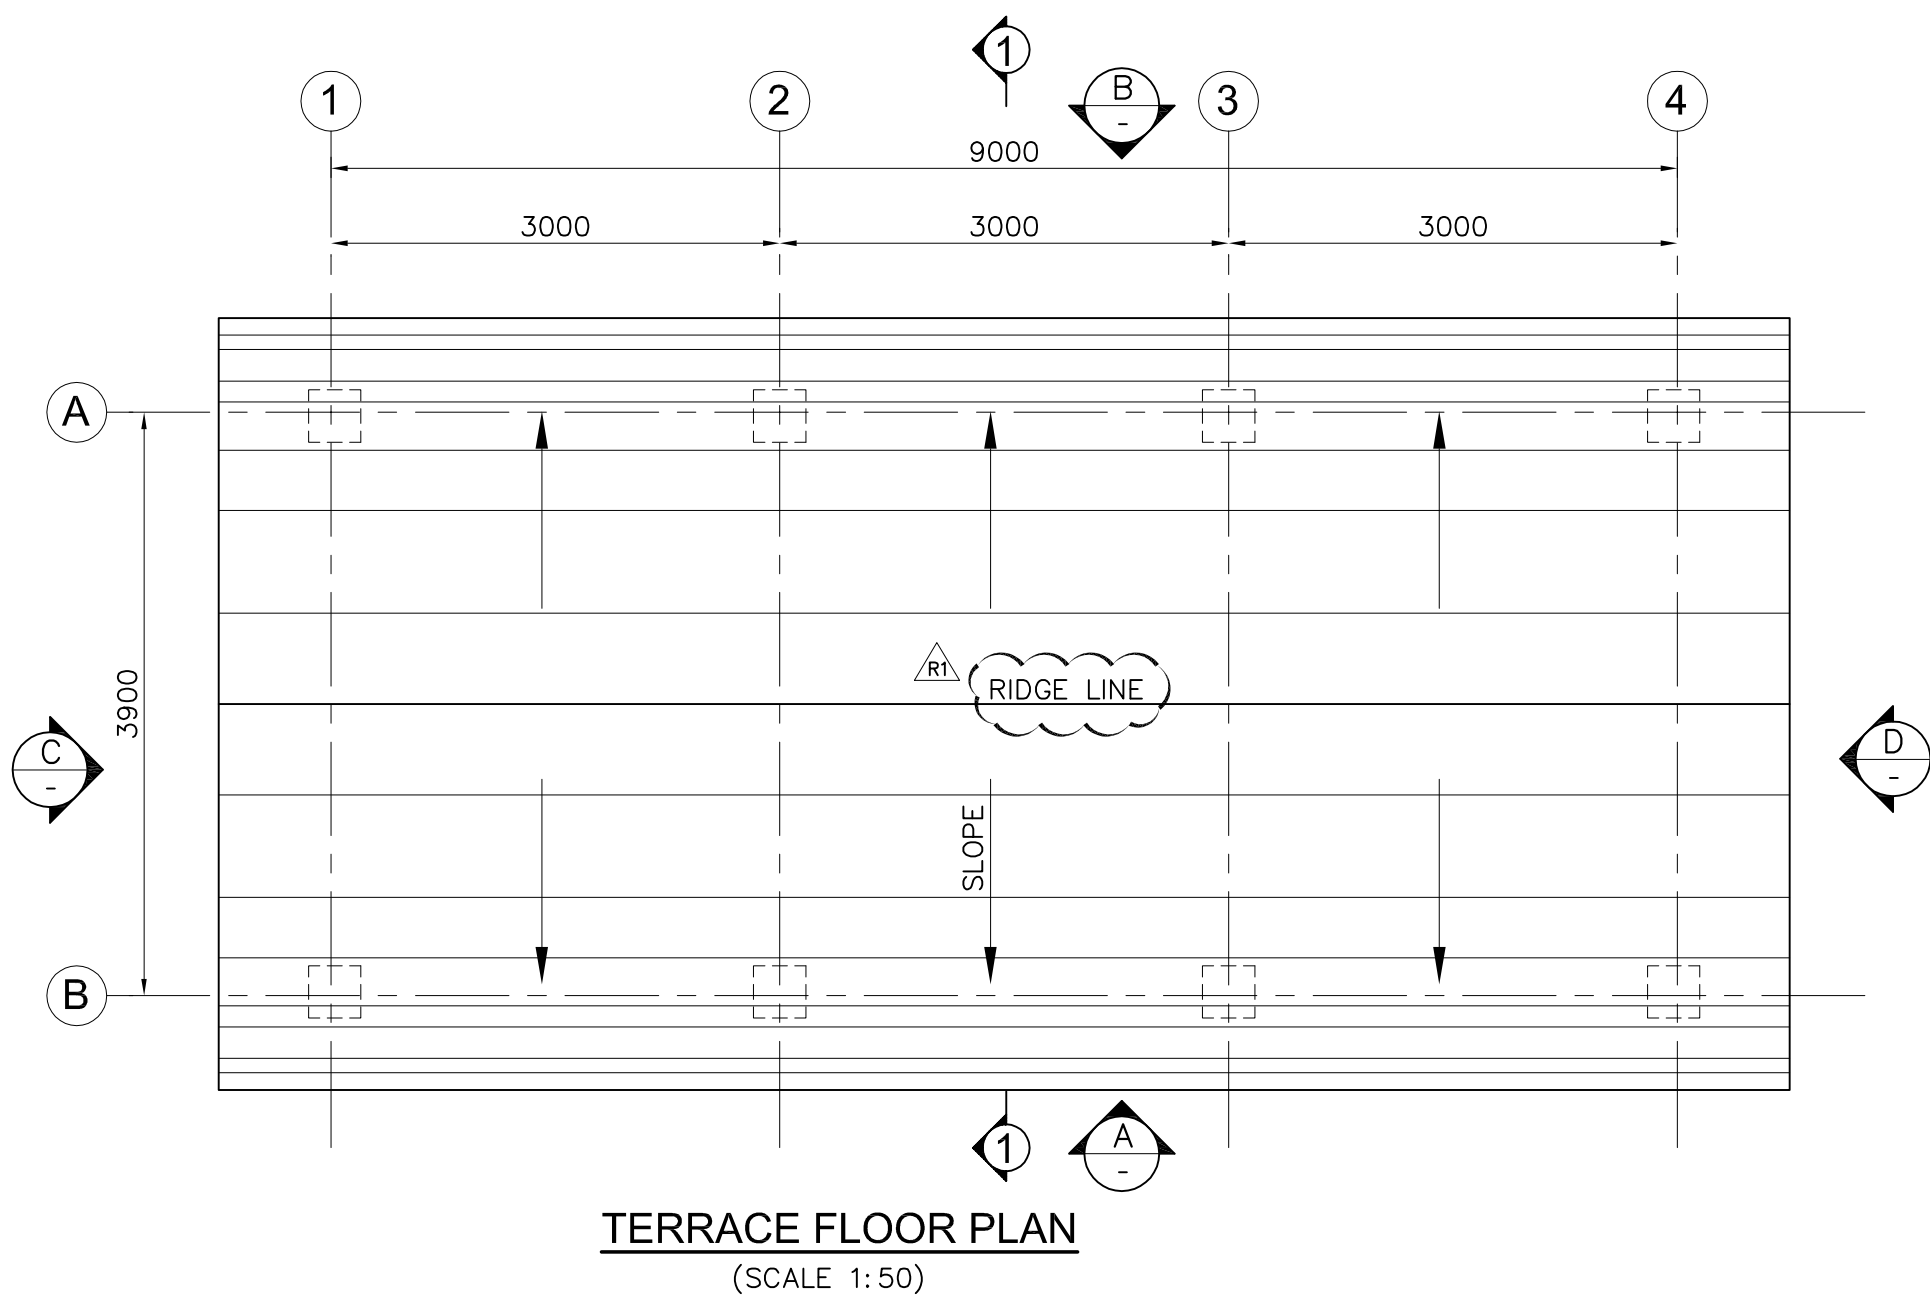


FOR TENDER PURPOSE ONLY

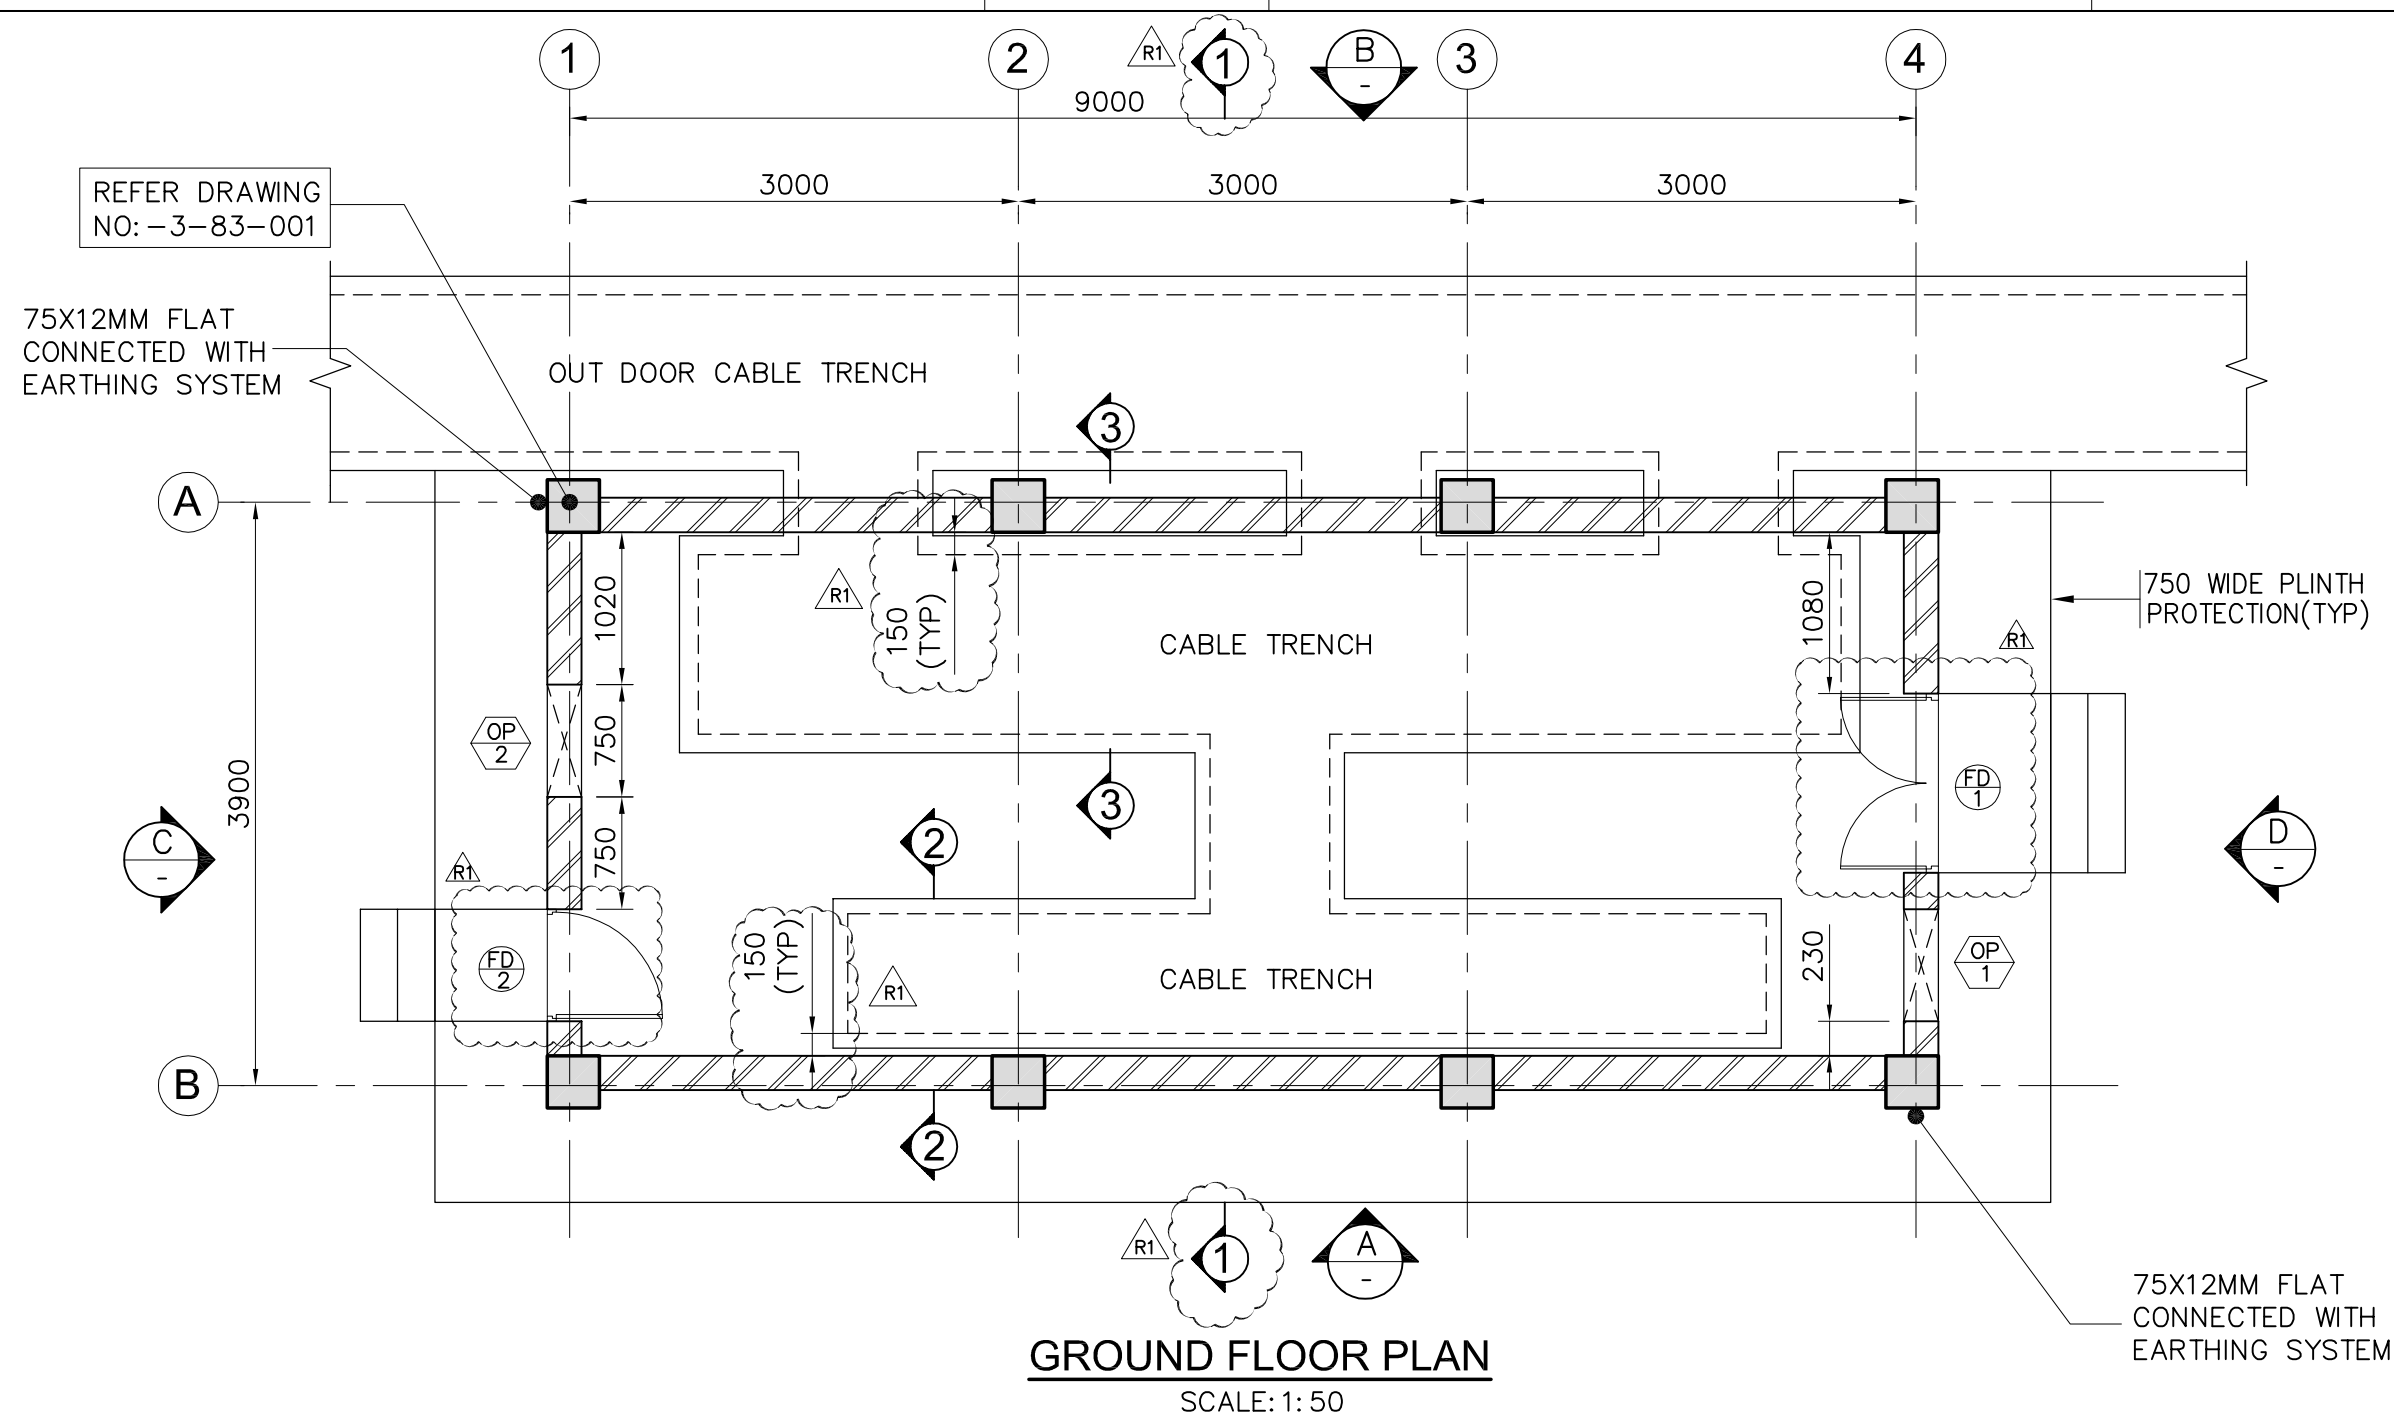

NOTES:

1. ALL DIMENSIONS ARE IN MILLIMETER AND LEVELS ARE IN METERS, UNO.
2. THIS DRAWING SHALL BE READ IN CONJUNCTION WITH CONTRACT TERMS AND CONDITIONS AND SPECIFICATION.
3. OPENING ARE PROVIDED FOR INSTALLATION OF ACS IN CASE ONE AC IS PROVIDED, OTHER OPENING SHALL BE CLOSED.
4. 22G X 12MM, CHICKEN WIRE MESH TO BE PROVIDED FOR ALL WALL, FLOORING AND ROOF, CHICKEN WIRE MESH SHALL BE CONNECTED WITH EARTHING SYSTEM THROUGH 75 X 12 MM FLAT FIXED ON DIAGONALLY OPPOSITE COLUMNS ON ITS OUTER SURFACE.
5. OPENING SHALL BE SEALED PROPERLY (AFTER LAYING OF ALL CABLES) BY FIRE SEALING COMPOUND.

LEGEND:

- 230 THK BRICK WALL
- FGL FINISHED GROUND LEVEL
- FFL FINISHED FLOOR LEVEL
- FPL FINISHED PAVING LEVEL
- TYP TYPICAL
- THK THICKNESS






REFERENCE DRAWINGS

(CONSTRUCTION)

- 3-00-004 - GENERAL NOTES FOR MASONRY STRUCTURES
- 3-83-001 - LAYOUT OF RELAY BUILDING

(ENGINEERING)

- TB-0-343-316-115 - TRENCH LAYOUT HVDC - AGRA
- 1JNL100409-604-R2 - OVER ALL LAYOUT - AGRA
- C-ENGG-STD-PR-ARCH-3000 -R2- ARCHITECTURAL DRAWING OF PANEL ROOM
- 3-00-010 - GENERAL NOTES- DOOR SCHEDULE
- 3-00-011 - GENERAL NOTES- WINDOW SCHEDULE

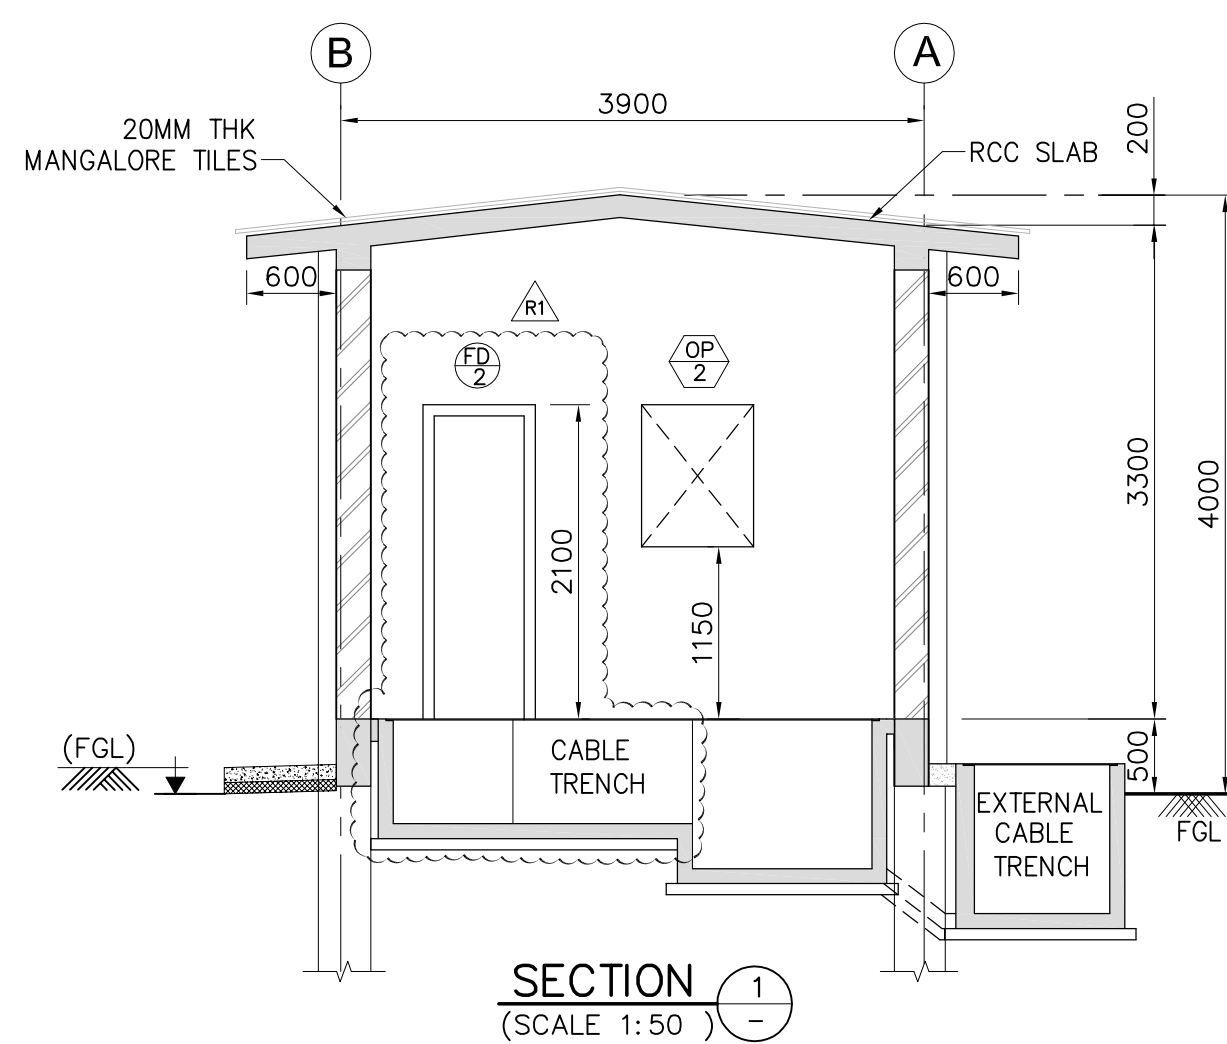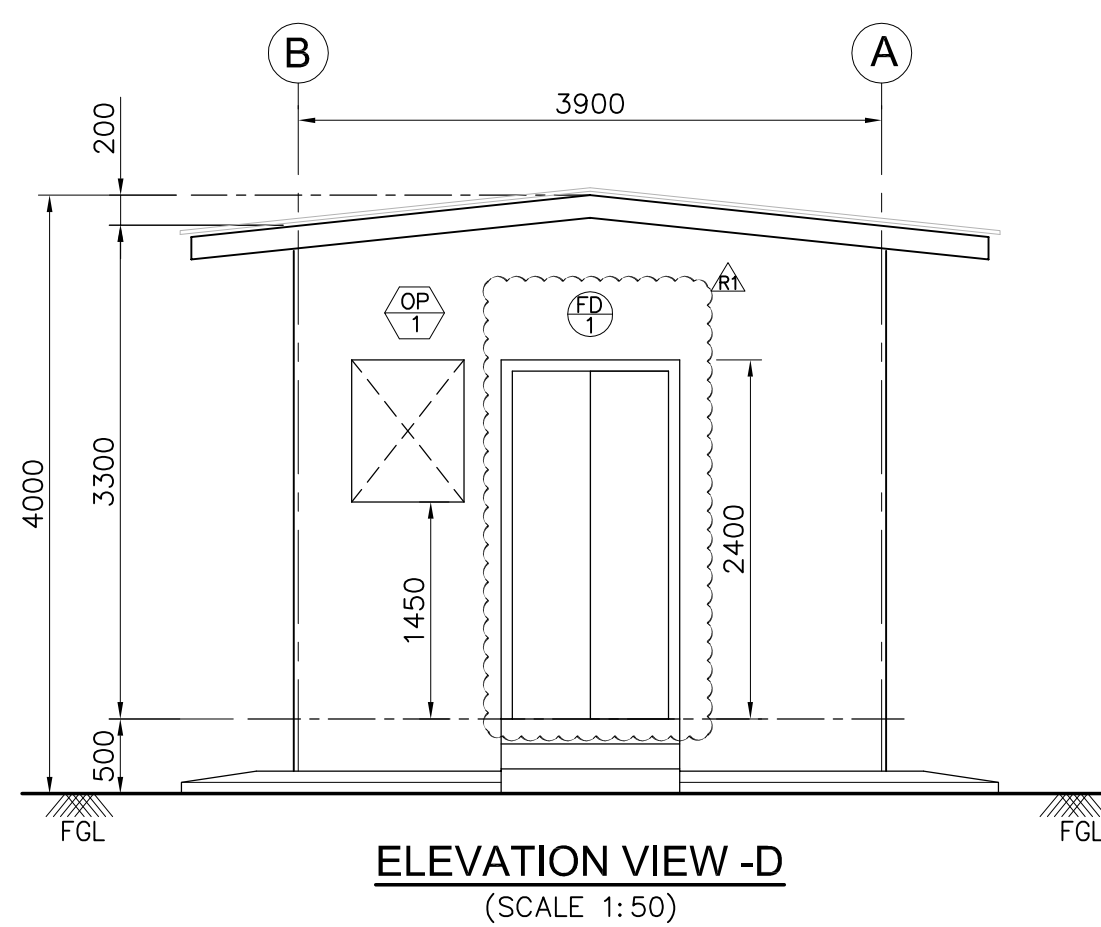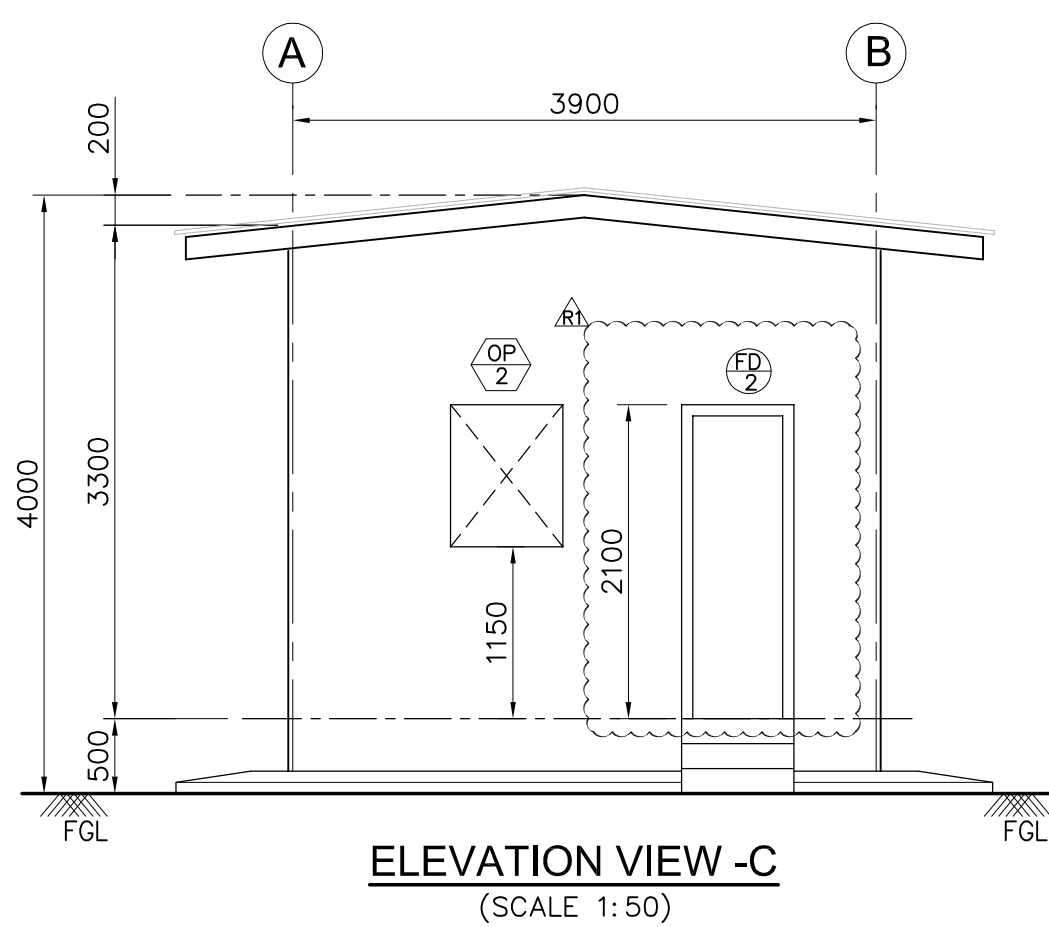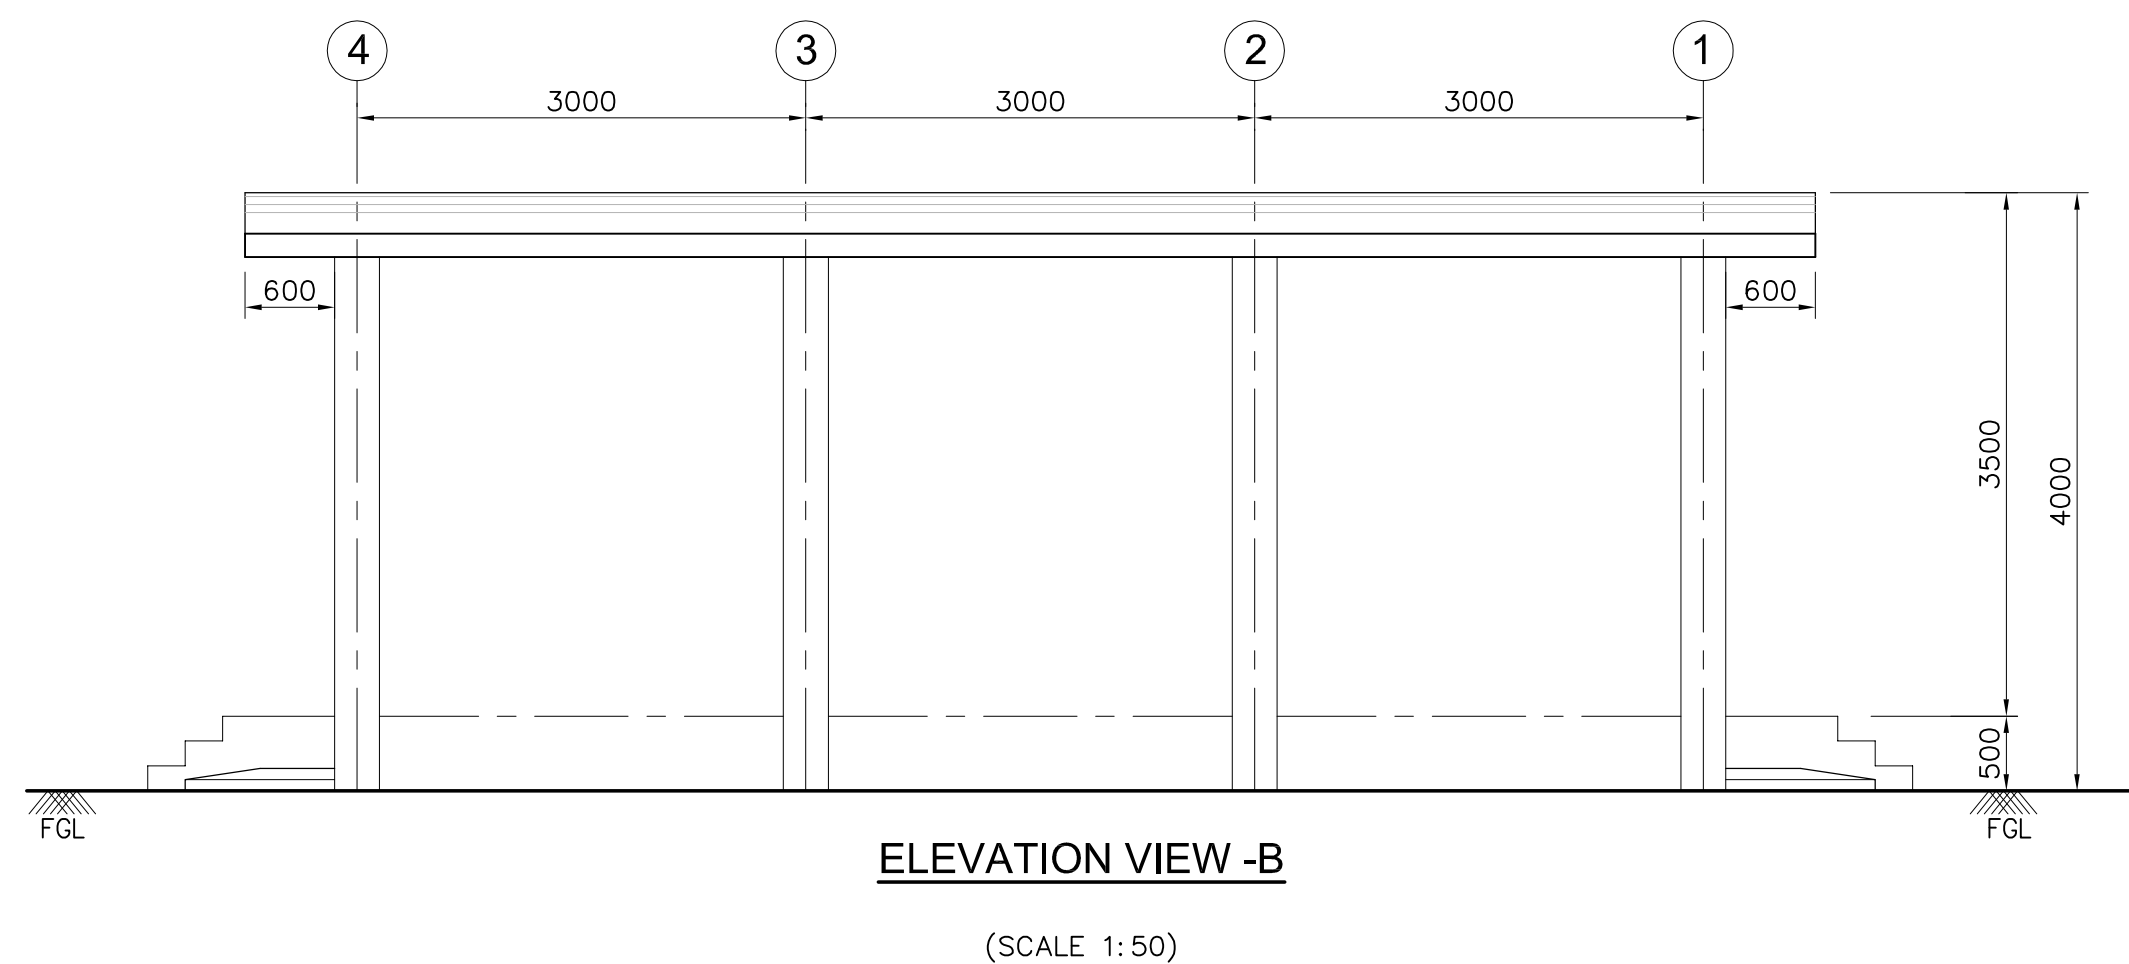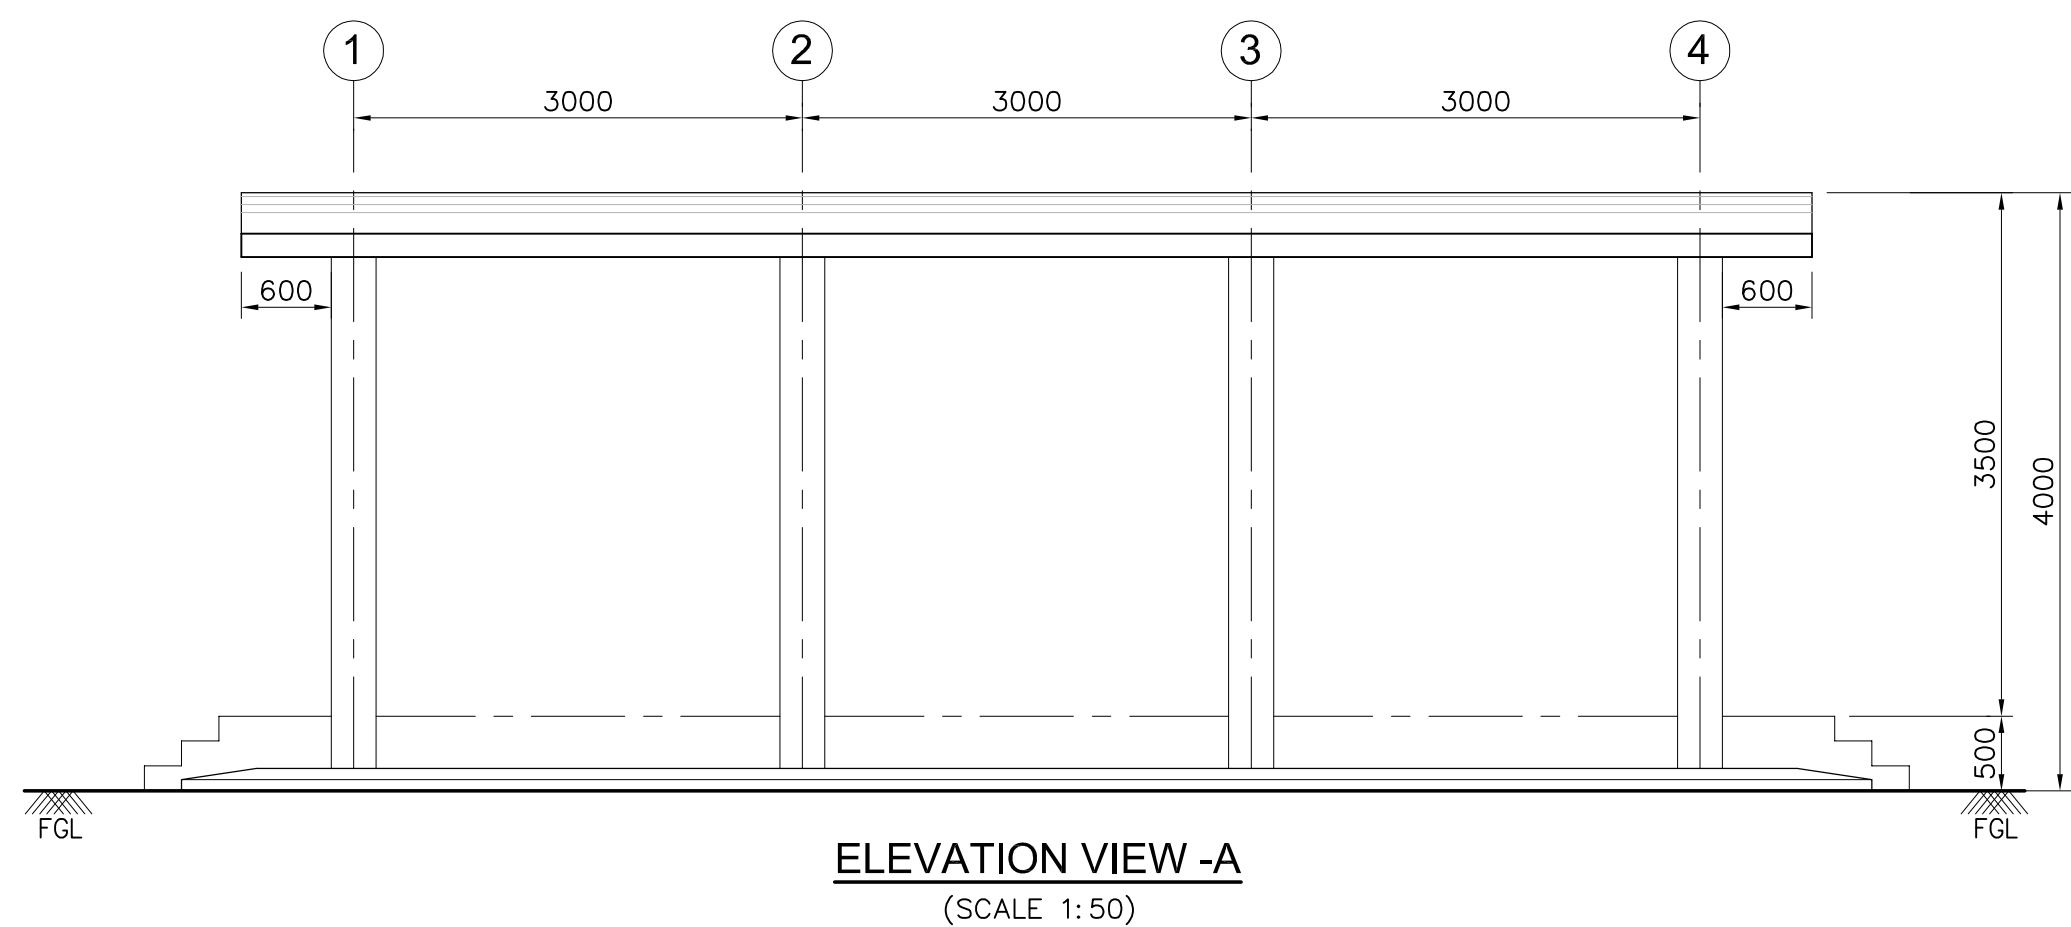


FINISH SCHEDULE:

SERIAL NUMBER	ROOMS	FLOORS	INTERNAL WALLS	CEILING	EXTERNAL WALL
		POLISHED VITRIFIED TILES	CERAMIC TILES OVER 12MM PLASTER WITH CHICKEN WIRE MESH ON ENTIRE SURFACE OF THE WALL	6MM THK PLASTER OVER CHICKEN WIRE MESH PAINTED WITH OIL BOUND DISTEMPER	18MM THK PLASTER IN THREE LAYERS OVER CHICKEN WIRE MESH AND PAINTED WITH NOVALUX EXTERIOR PAINT
01	PANEL ROOM	•	•	•	•

NOTE: FOR EARLIER REVISION REFER 3-83-002-DATED 05.06.12

R1	REVISED AS PER COMMENTS	21.08.12	ST	Date	Drawn by	Checked by	Scale (AI-Print)	Drawing No.	Rev
RO	ISSUED FOR APPROVAL	05.06.12	ST	5.06.2012	SSN	MMPS/MKK	1:50	5517-3-83-002	R1
Rev/ind	Revision	Year Week	Appd						

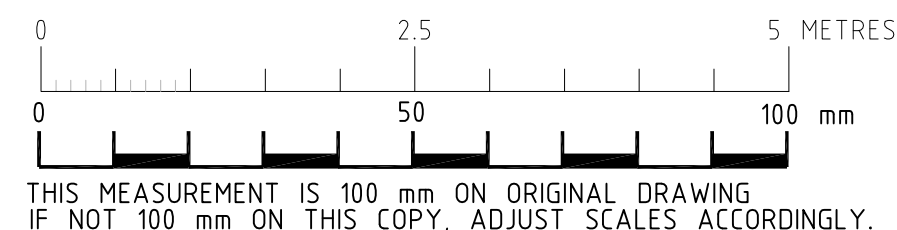

SCHEDULE OF JOINERY					
SYMBOL	Nos.	MASONRY OPENING WIDTH	HEIGHT	REMARKS	
FD 1	01	1200	2400	FIRE PROOF STEEL DOOR - DOUBLE SHUTTER	
FD 2	01	750	2100	FIRE PROOF STEEL DOOR - SINGLE SHUTTER	
OP 1	01	750	950	OPENING FOR FIXING AIR CONDITIONS	
OP 2	01	750	950	OPENING FOR FIXING AIR CONDITIONS	

FOR APPROVAL

POWER GRID CORPORATION OF INDIA LIMITED
(A government of India Enterprise)

±800 kV 6000 MW HVDC Multi Terminal
NER/ER - NR/WR Interconnector-I

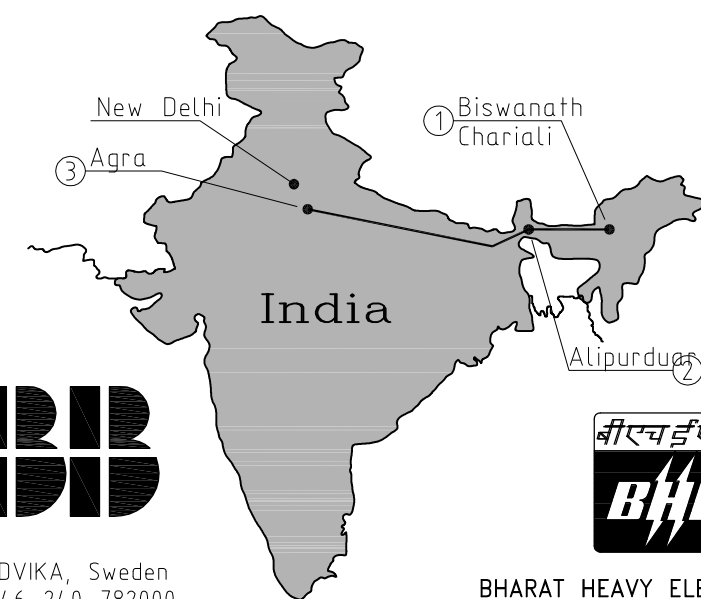


ABB AB
S-771 80 LUDVIKA, Sweden
Telephone: +46 240 782000



BHARAT HEAVY ELECTRICALS LTD.
TRANSMISSION PROJECTS DIVISION

Civil and Building Works incl EL and Mech. Services.

CONSULTANT

FICHTNER Consulting
Engineers (India)
Private Limited
Chennai.

AGRA CONVERTER STATION
RELAY BUILDING - (TYPE-1)
ARCHITECTURAL PLANS
SECTION AND ELEVATIONS