
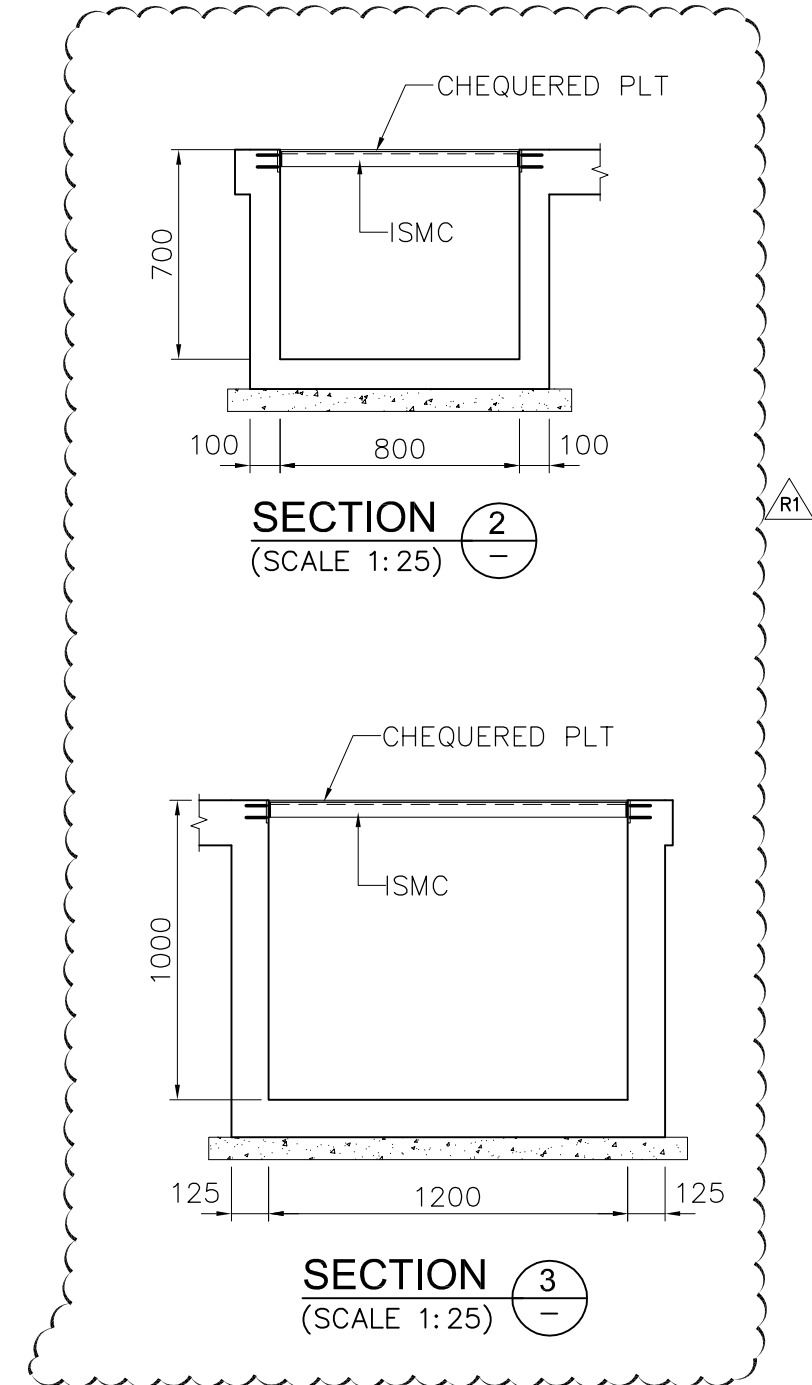
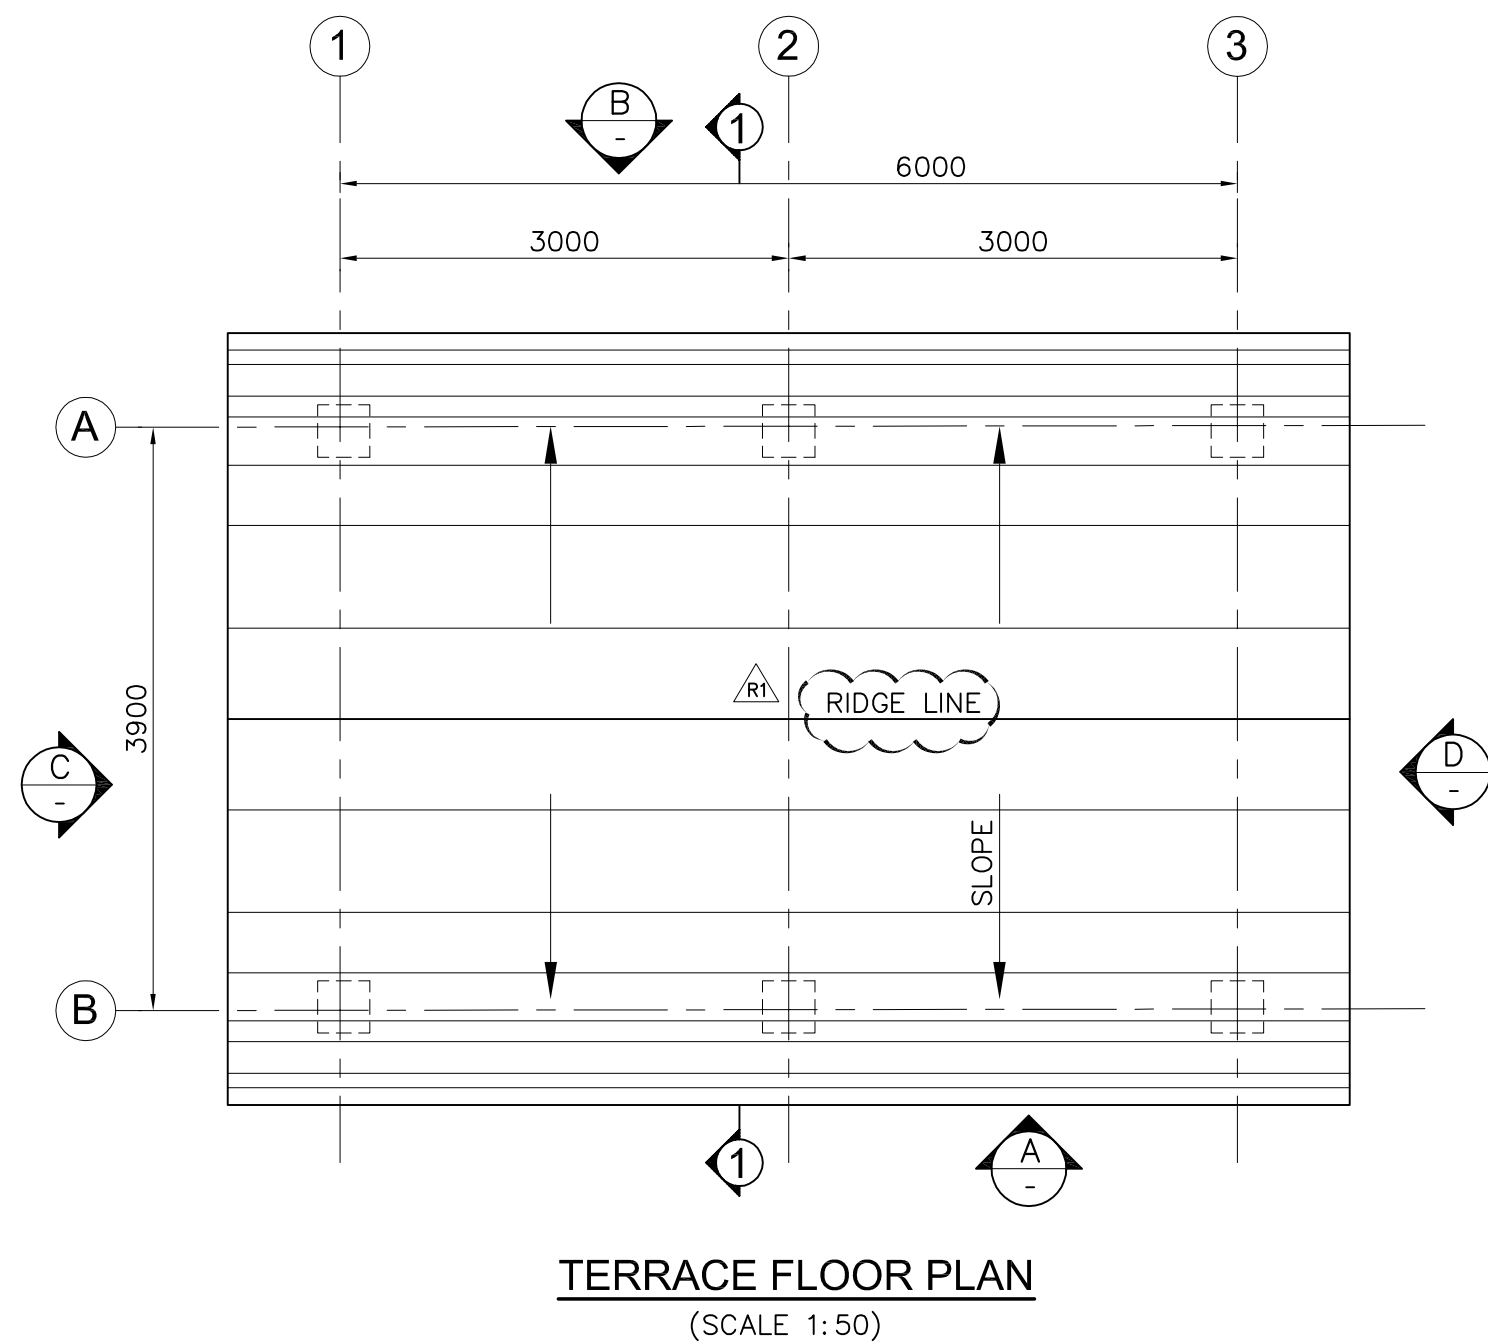


FOR TENDER PURPOSE ONLY

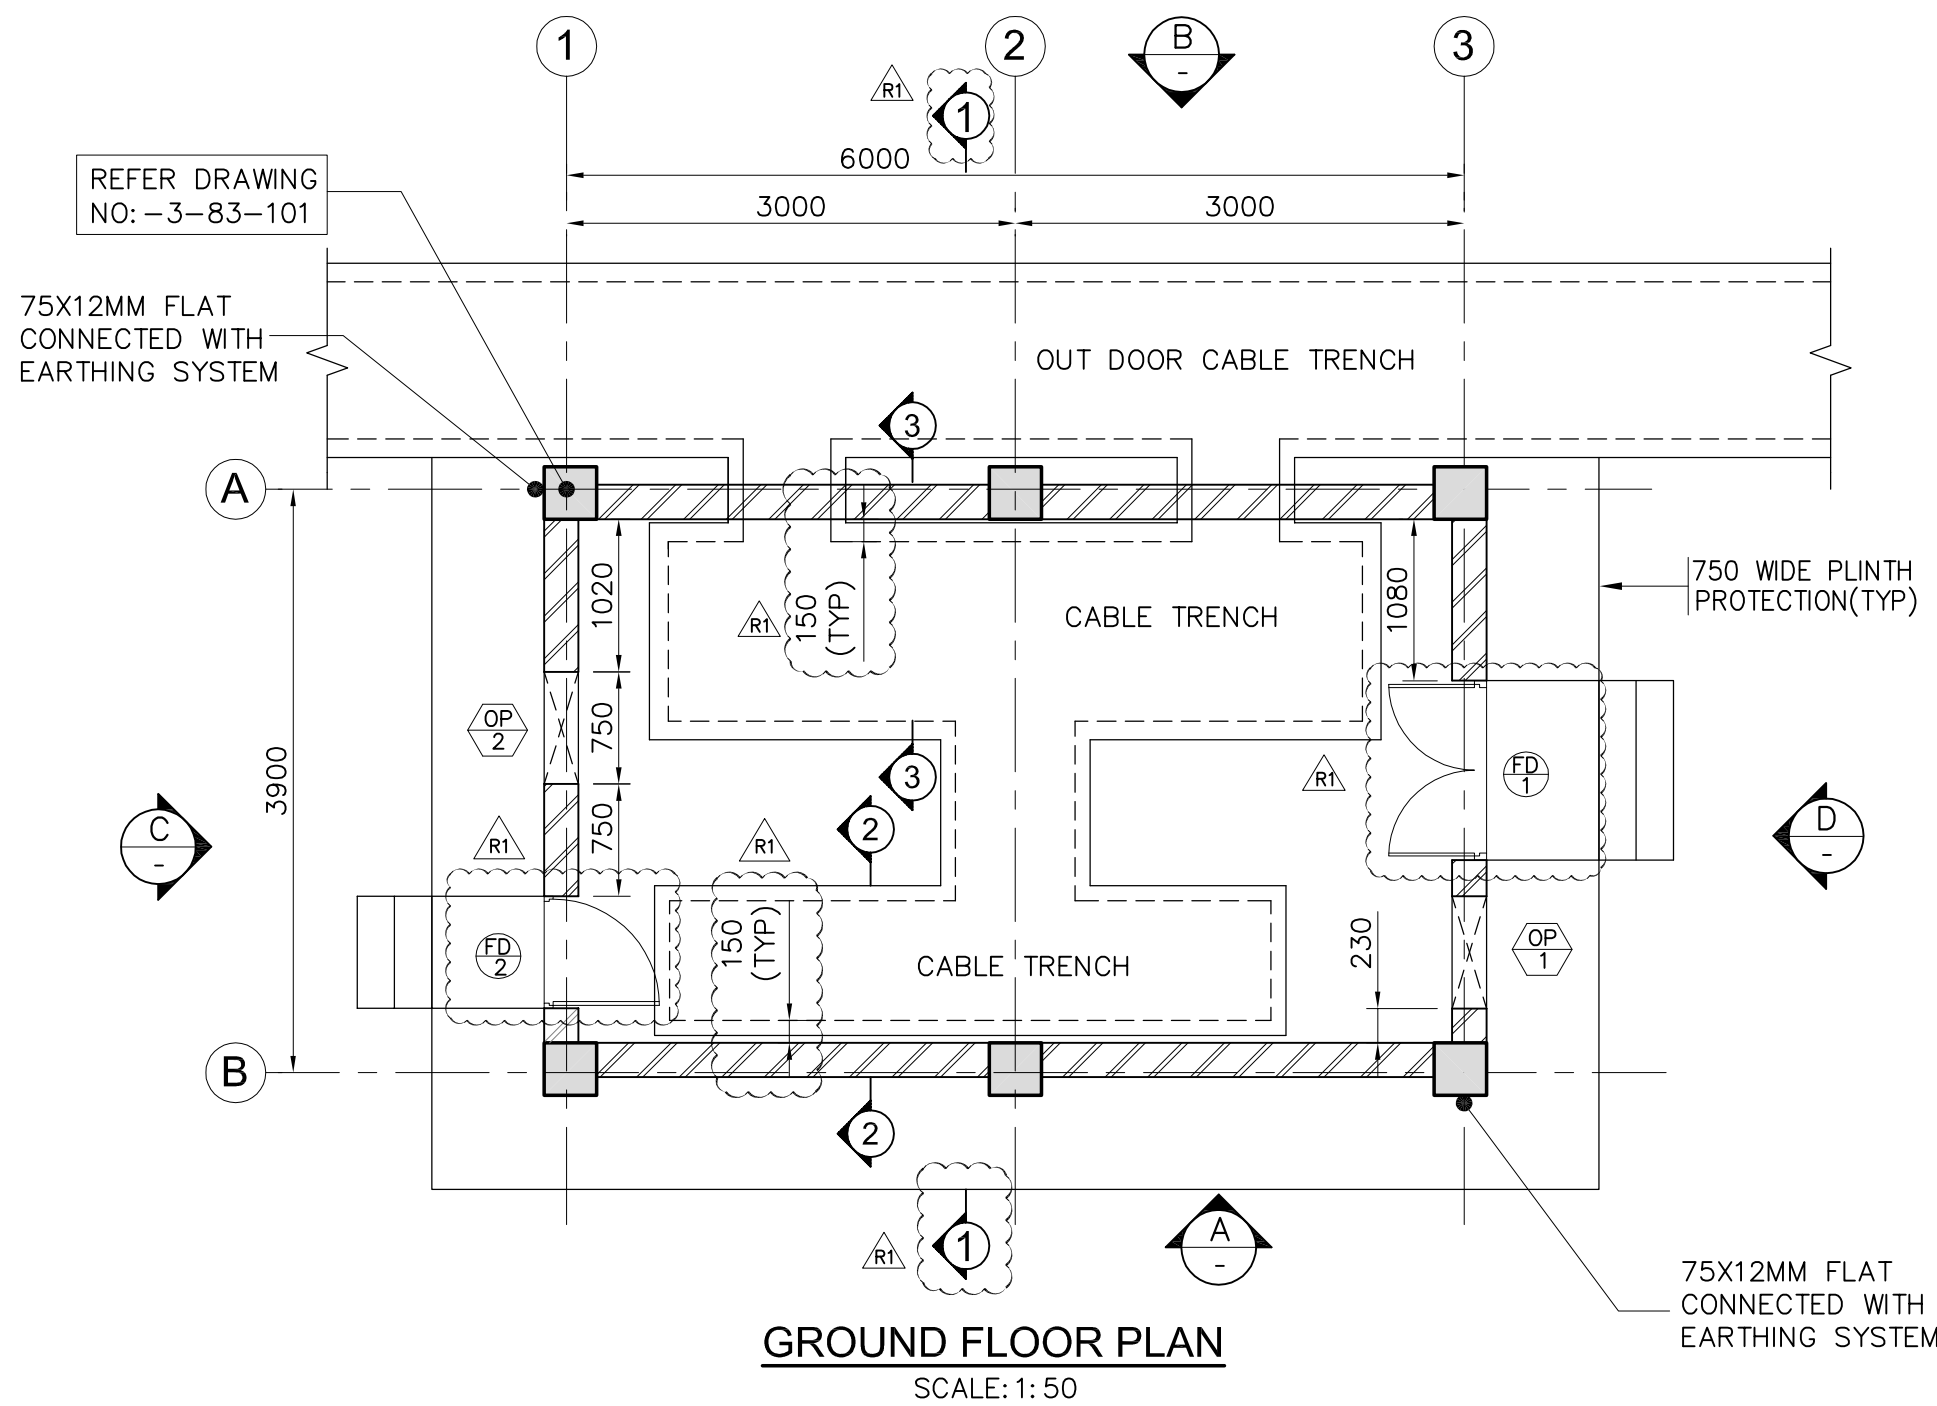






- NOTES:**
1. ALL DIMENSIONS ARE IN MILLIMETER AND LEVELS ARE IN METERS, UNO.
  2. THIS DRAWING SHALL BE READ IN CONJUNCTION WITH CONTRACT TERMS AND CONDITIONS AND SPECIFICATION.
  3. OPENING ARE PROVIDED FOR INSTALLATION OF ACS IN CASE ONE AC IS PROVIDED, OTHER OPENING SHALL BE CLOSED.
  4. 22G X 12MM, CHICKEN WIRE MESH TO BE PROVIDED FOR ALL WALL, FLOORING AND ROOF, CHICKEN WIRE MESH SHALL BE CONNECTED WITH EARTHING SYSTEM THROUGH 75 X 12 MM FLAT FIXED ON DIAGONALLY OPPOSITE COLUMNS ON ITS OUTER SURFACE.
  5. OPENING SHALL BE SEALED PROPERLY (AFTER LAYING OF ALL CABLES) BY FIRE SEALING COMPOUND.

**LEGEND:**

- 230 THK BRICK WALL
- FGL FINISHED GROUND LEVEL
- FFL FINISHED FLOOR LEVEL
- FPL FINISHED PAVING LEVEL
- TYP TYPICAL
- THK THICKNESS

**REFERENCE DRAWINGS**

- (CONSTRUCTION)
- 3-00-004 - GENERAL NOTES FOR MASONRY STRUCTURES
- 3-83-101 - LAYOUT OF RELAY BUILDING
- (ENGINEERING)
- TB-0-343-316-115 - TRENCH LAYOUT HVDC - AGRA
- 1JNL100409-604-R2 - OVER ALL LAYOUT - AGRA
- C-ENG-STD-PR-ARCH-3000 -R2- ARCHITECTURAL DRAWING OF PANEL ROOM
- 3-00-010 - GENERAL NOTES- DOOR SCHEDULE
- 3-00-011 - GENERAL NOTES- WINDOW SCHEDULE

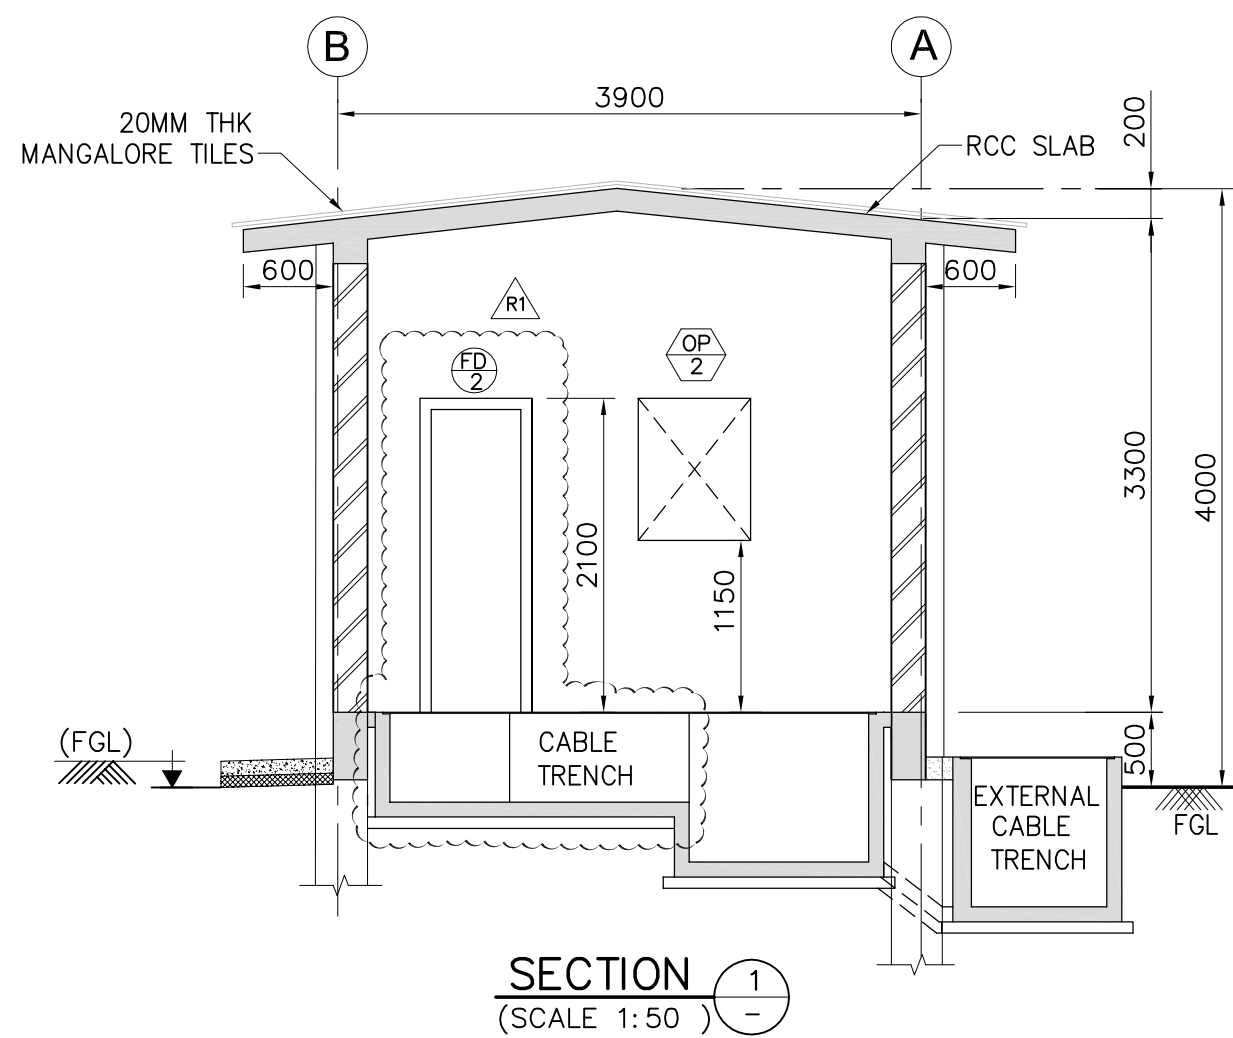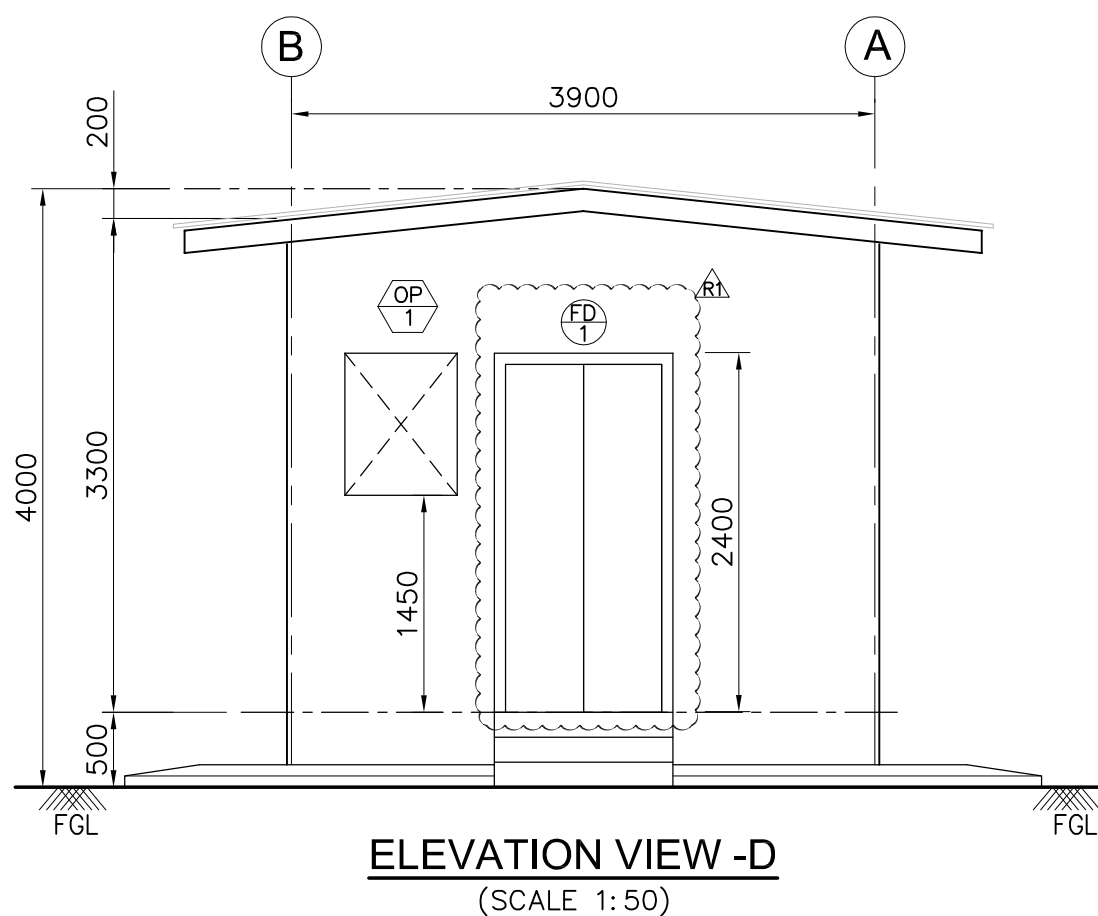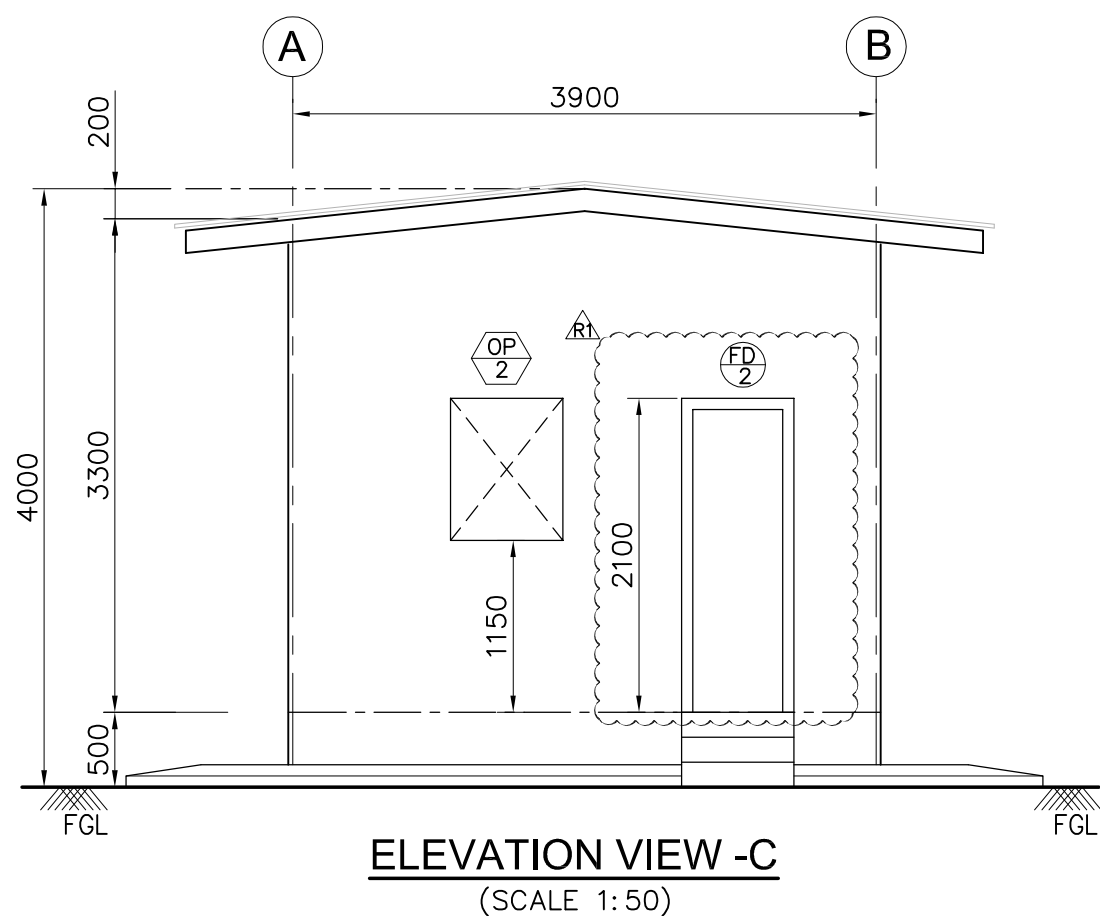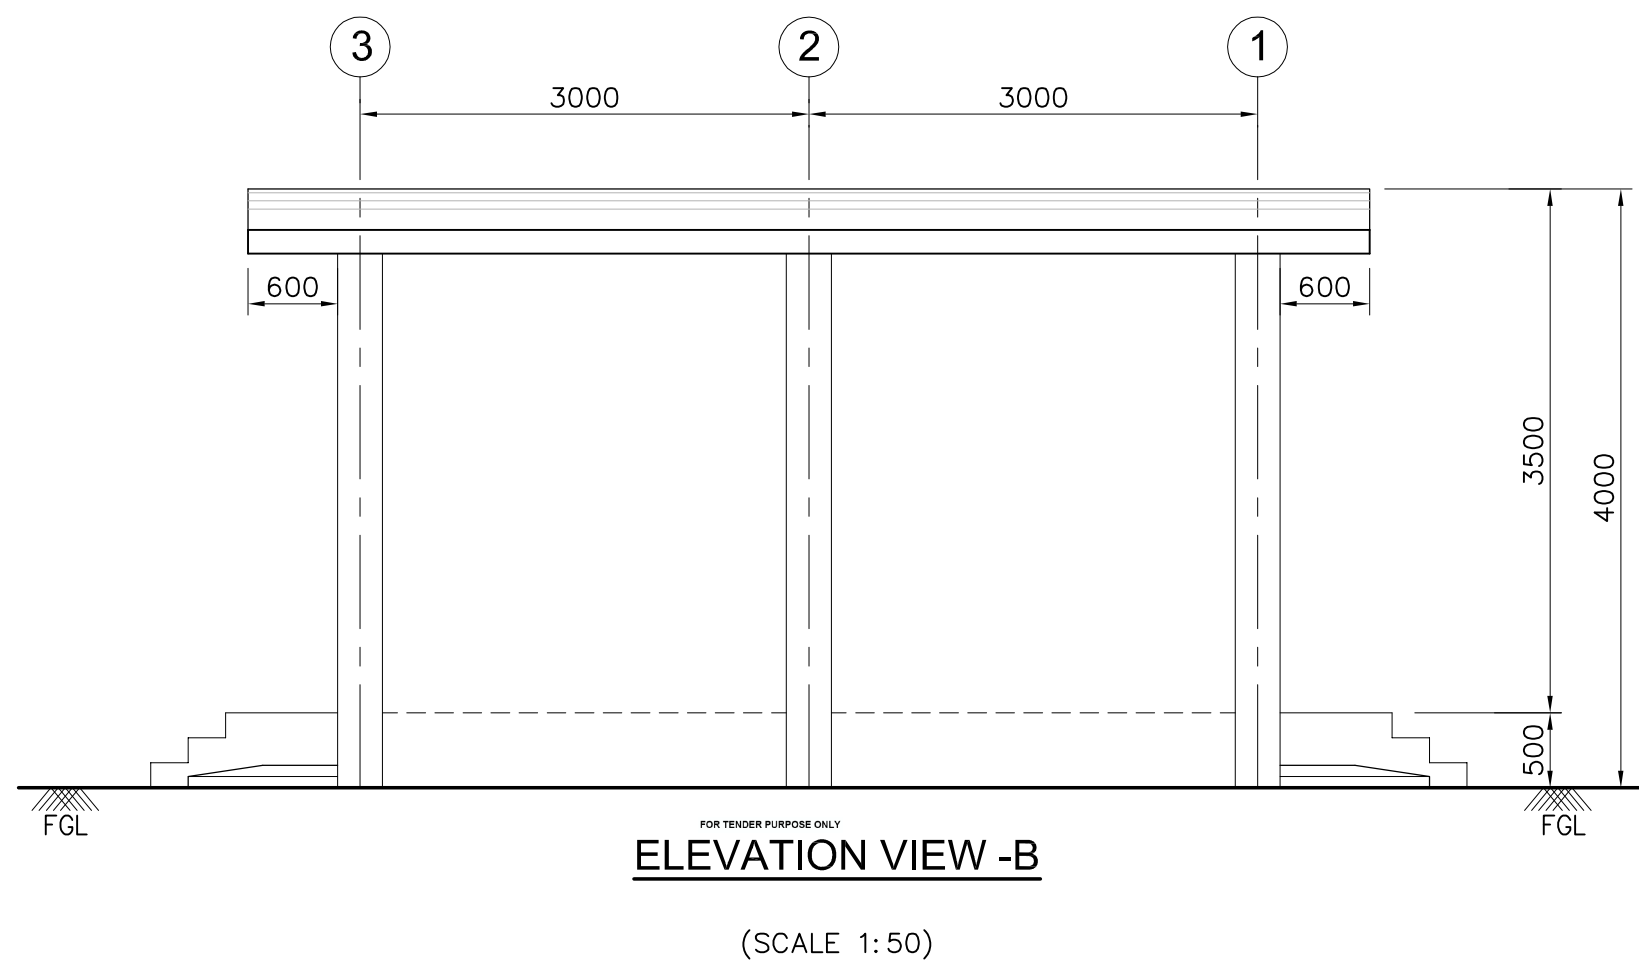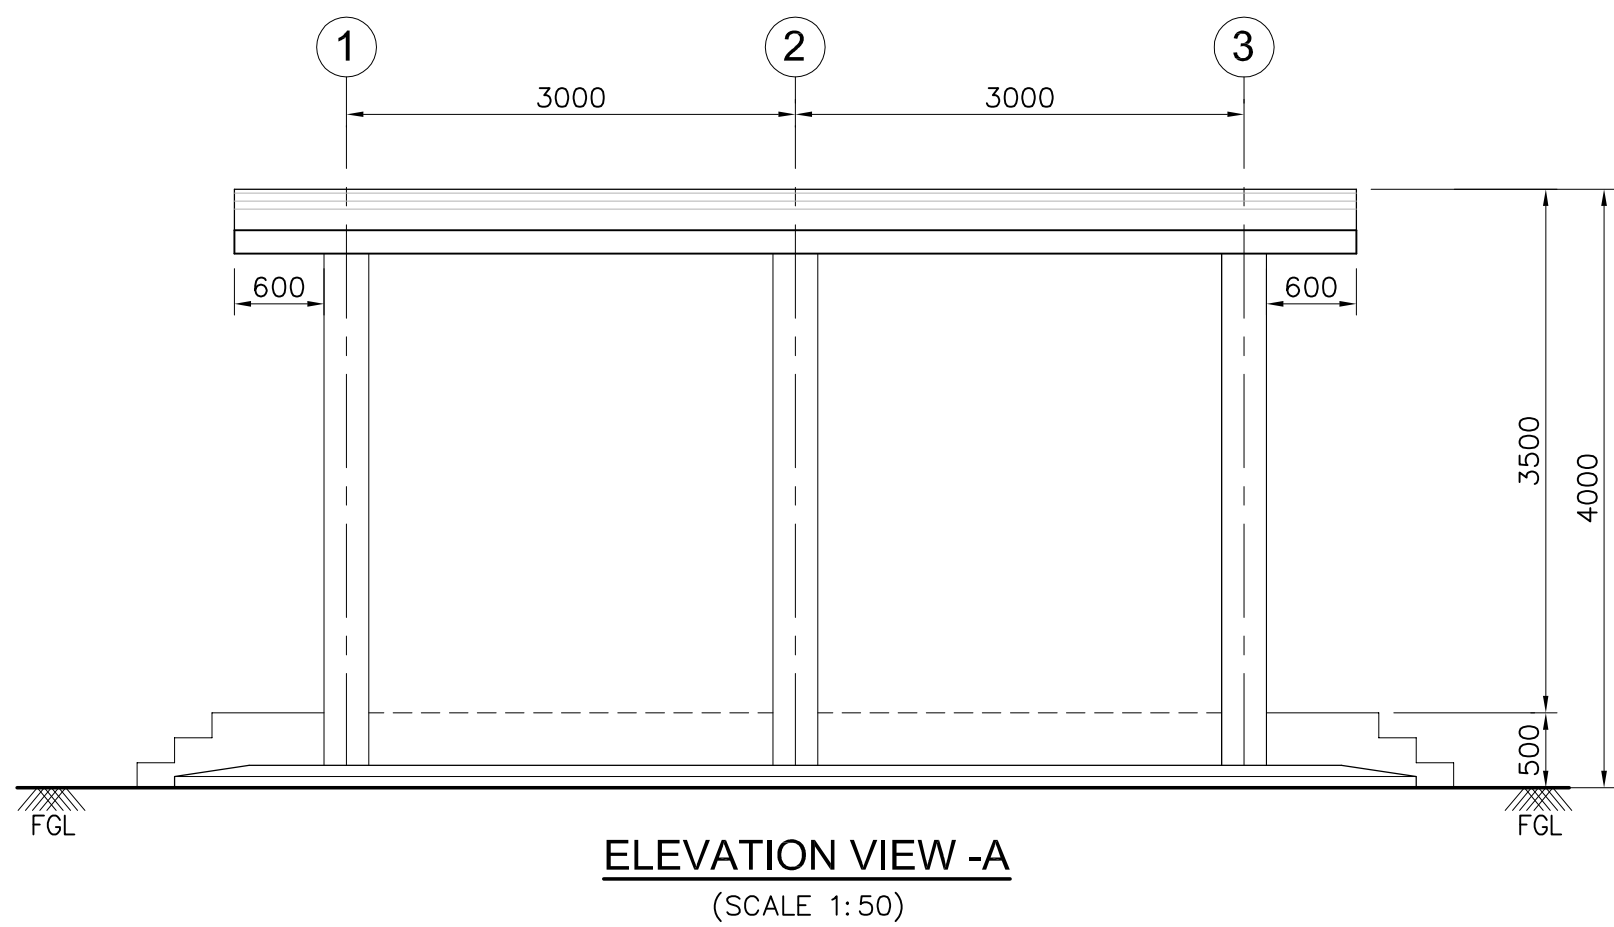


**FINISH SCHEDULE:**

SERIAL NUMBER	ROOMS	FLOORS	INTERNAL WALLS	CEILING	EXTERNAL WALL
01	PANEL ROOM				

NOTE: FOR EARLIER REVISION REFER 3-83-102-DATED 05.06.12

R1	REVISED AS PER COMMENTS	21.08.12	ST
RO	ISSUED FOR APPROVAL	05.06.12	ST
Revind	Revision	Year Week	Appd

SCHEDULE OF JOINERY				
SYMBOL	Nos.	MASONRY OPENING WIDTH	HEIGHT	REMARKS
OP 1	01	1200	2400	FIRE PROOF STEEL DOOR - DOUBLE SHUTTER
OP 2	01	750	2100	FIRE PROOF STEEL DOOR - SINGLE SHUTTER
OP 3	01	750	950	OPENING FOR FIXING AIR CONDITIONS
OP 4	01	750	950	OPENING FOR FIXING AIR CONDITIONS

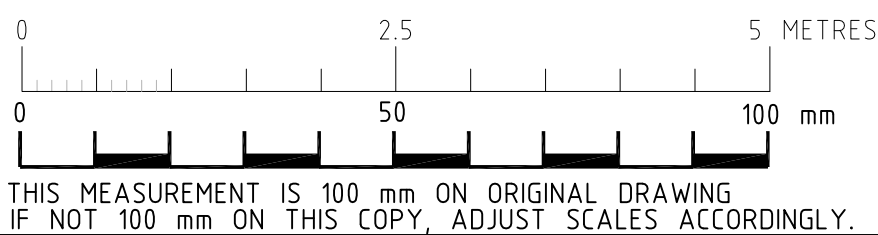

**FOR APPROVAL**

POWER GRID CORPORATION OF INDIA LIMITED  
(A government of India Enterprise)

±800 kV 6000 MW HVDC Multi Terminal  
NER/ER - NR/WR Interconnector-I

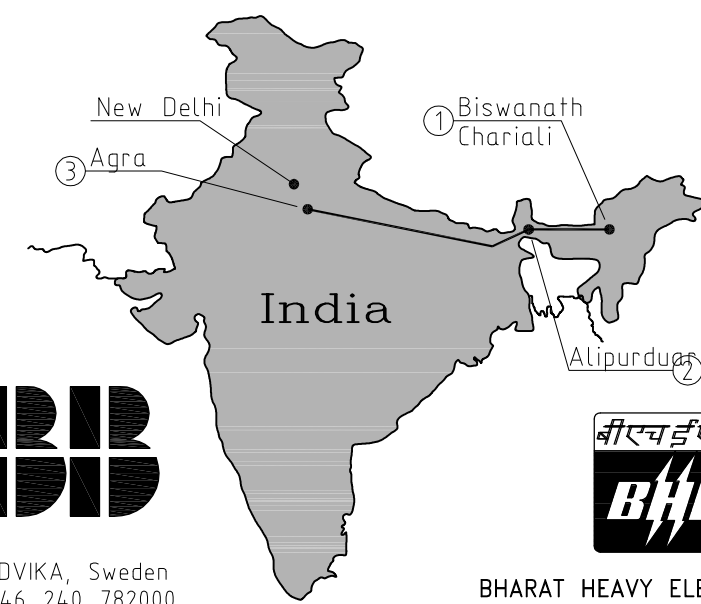


ABB AB  
S-771 80 LUDVIKA, Sweden  
Telephone: +46 240 782000

भारत भारती  
BHARAT

BARAT HEAVY ELECTRICALS LTD.  
TRANSMISSION PROJECTS DIVISION

Civil and Building Works incl EL and Mech. Services.

**CONSULTANT**

FICTNER Consulting  
Engineers (India)  
Private Limited  
Chennai.

AGRA CONVERTER STATION  
RELAY BUILDING - (TYPE-2)  
ARCHITECTURAL PLANS  
SECTION AND ELEVATIONS

Scale (AI-Print) 1:50  
Drawing No. 5517-3-83-102  
Rev R1